
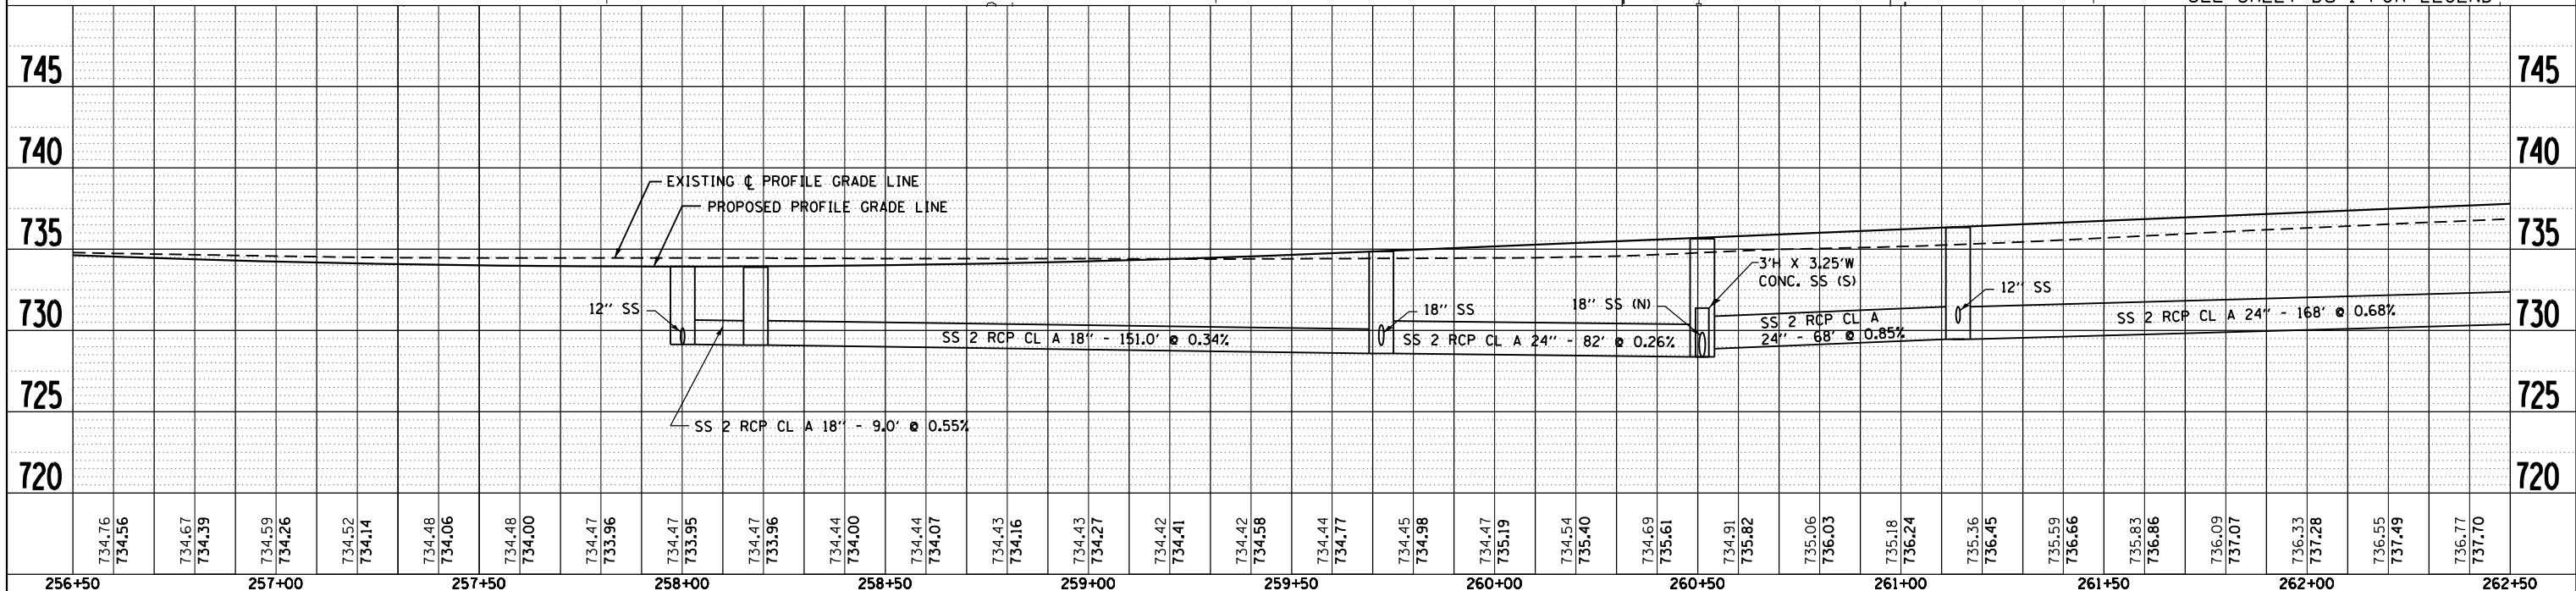


PLAN	SURVEYED	DATE
	PLOTTED	BY
	ALIGNED	
	CHECKED	
	FILED	
	NO.	

PROFILE	SURVEYED	DATE
	PLOTTED	BY
	GRADES	
	CHECKED	
	STRUCTURE	
	NOTATIONS	
	CPAD	
	NO.	

McDonough Associates Inc.
 Engineers / Architects
 130 East Randolph Street Chicago, Illinois 60601

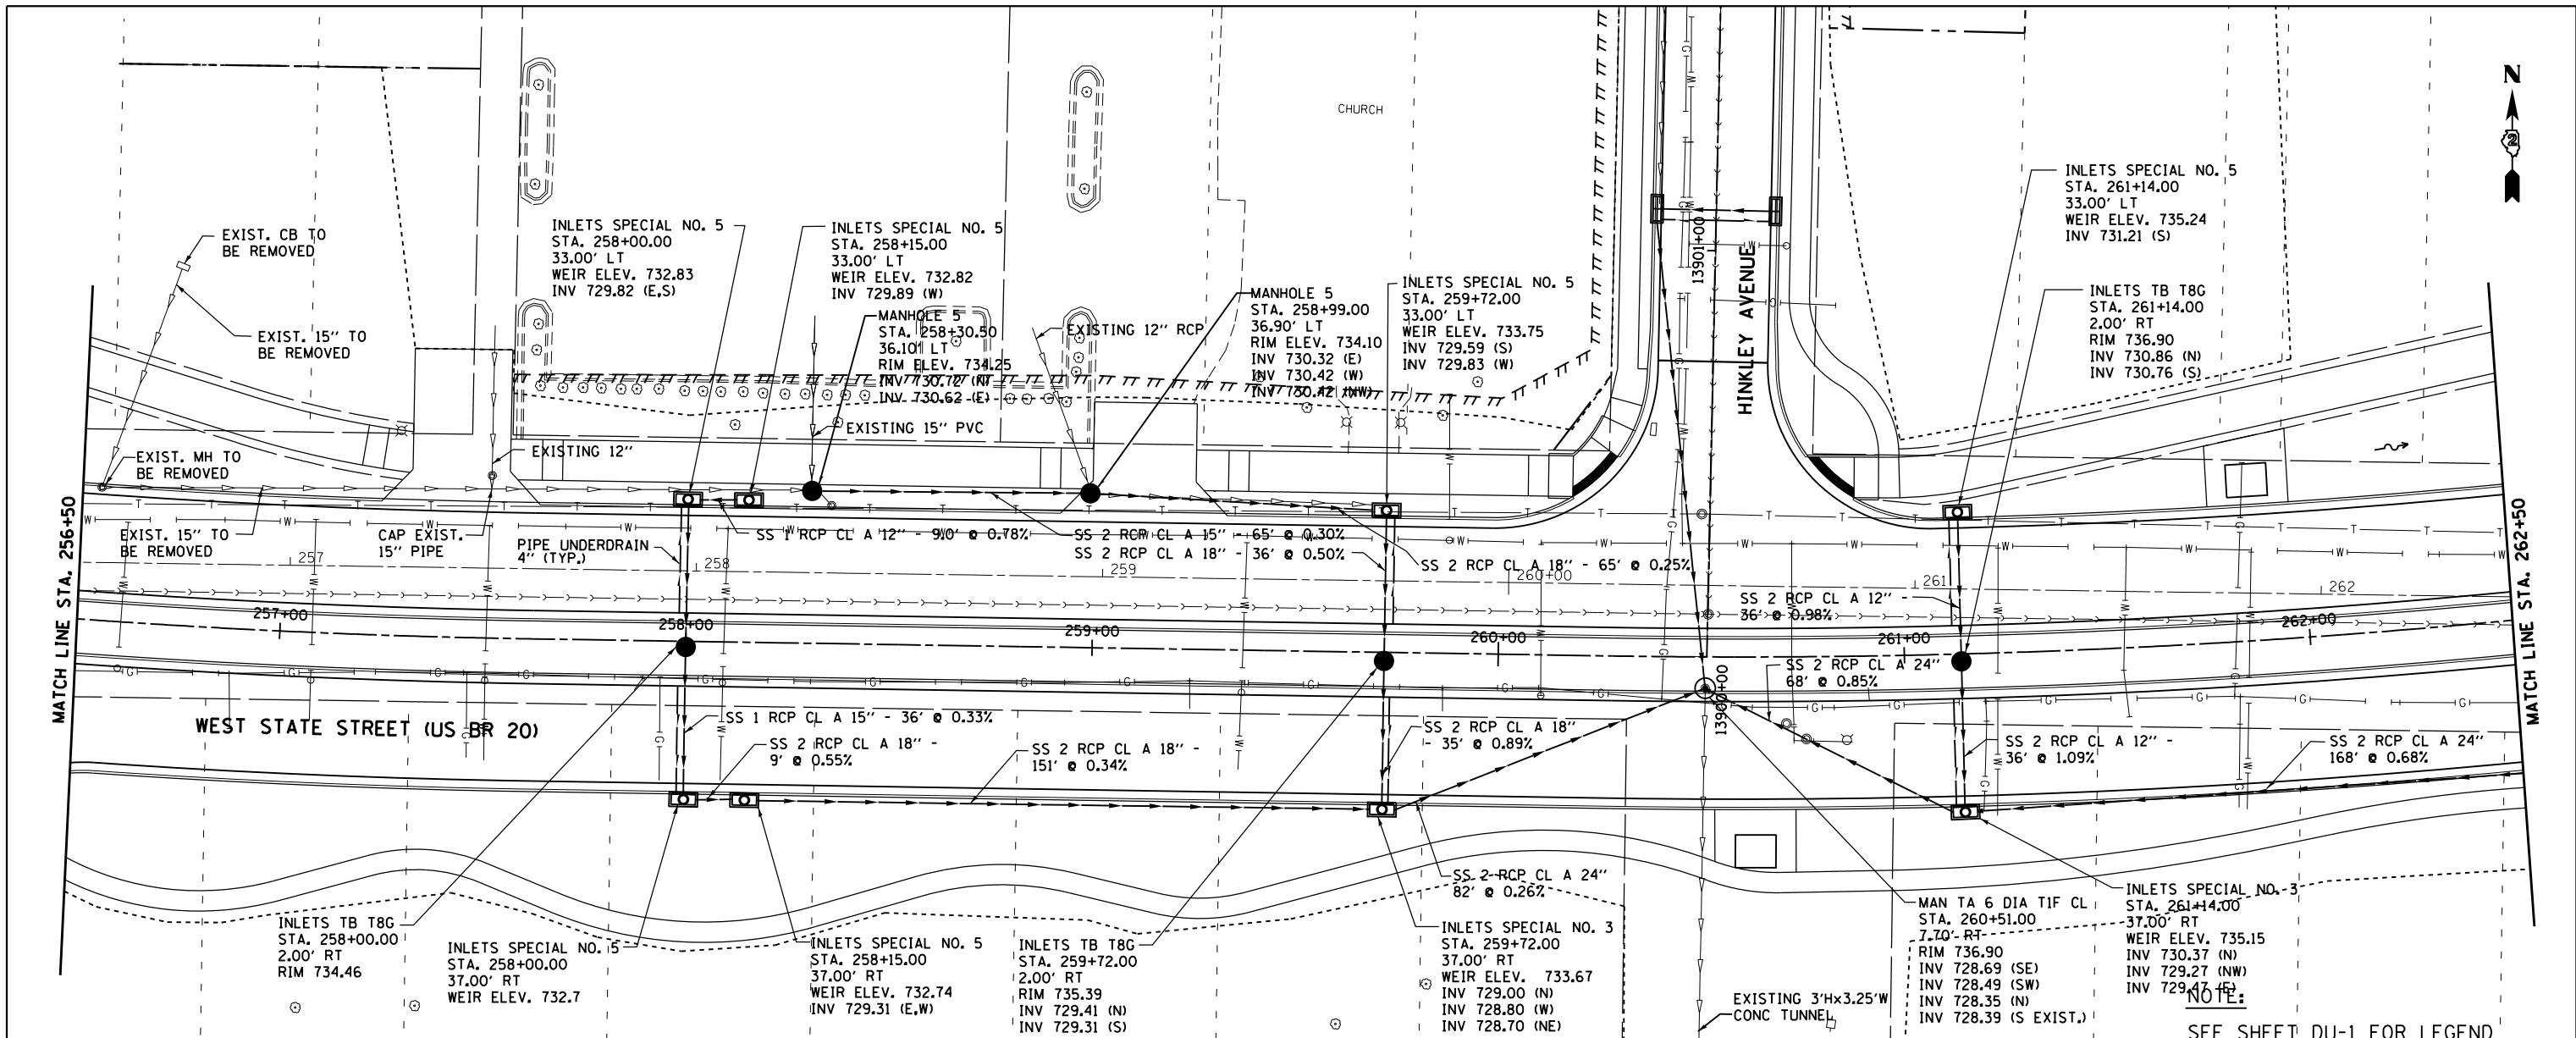

FILE NAME =	USER NAME = dssdd	DESIGNED - EJD	REVISED -	STATE OF ILLINOIS DEPARTMENT OF TRANSPORTATION	PROPOSED DRAINAGE PLAN AND PROFILE WEST STATE ST (US BUS 20)	F.A.P. RT. = 303	SECTION = 41R	COUNTY = WINNEBAGO	TOTAL SHEETS = 327	SHEET NO. = 148	
CONTRACT NO. = 64750	DATE = *SUBDATE*	CHECKED - RCH	REVISED -			SCALE:	SHEET NO. 4 OF 21 SHEETS	STA. TO STA.	FED. ROAD DIST. NO. 2 ILLINOIS FED. AID PROJECT		
PLOT SCALE = 40.0000' / in.		DATE = *SUBDATE*	REVISED -								
PLOT DATE = Mon Dec 17 14:50:29 2012											