



PLAN	SURVEYED	DATE
	PLOTTED	
	ALIGNED	
	CHECKED	
	FILED	
	NO.	

PROFILE	SURVEYED	DATE
	PLOTTED	
	GRADES CHECKED	
	STRUCTURE NOTATIONS OK'D	
	NO.	

McDonough Associates Inc.
 Engineers/Architects
 130 East Randolph Street Chicago, Illinois 60601

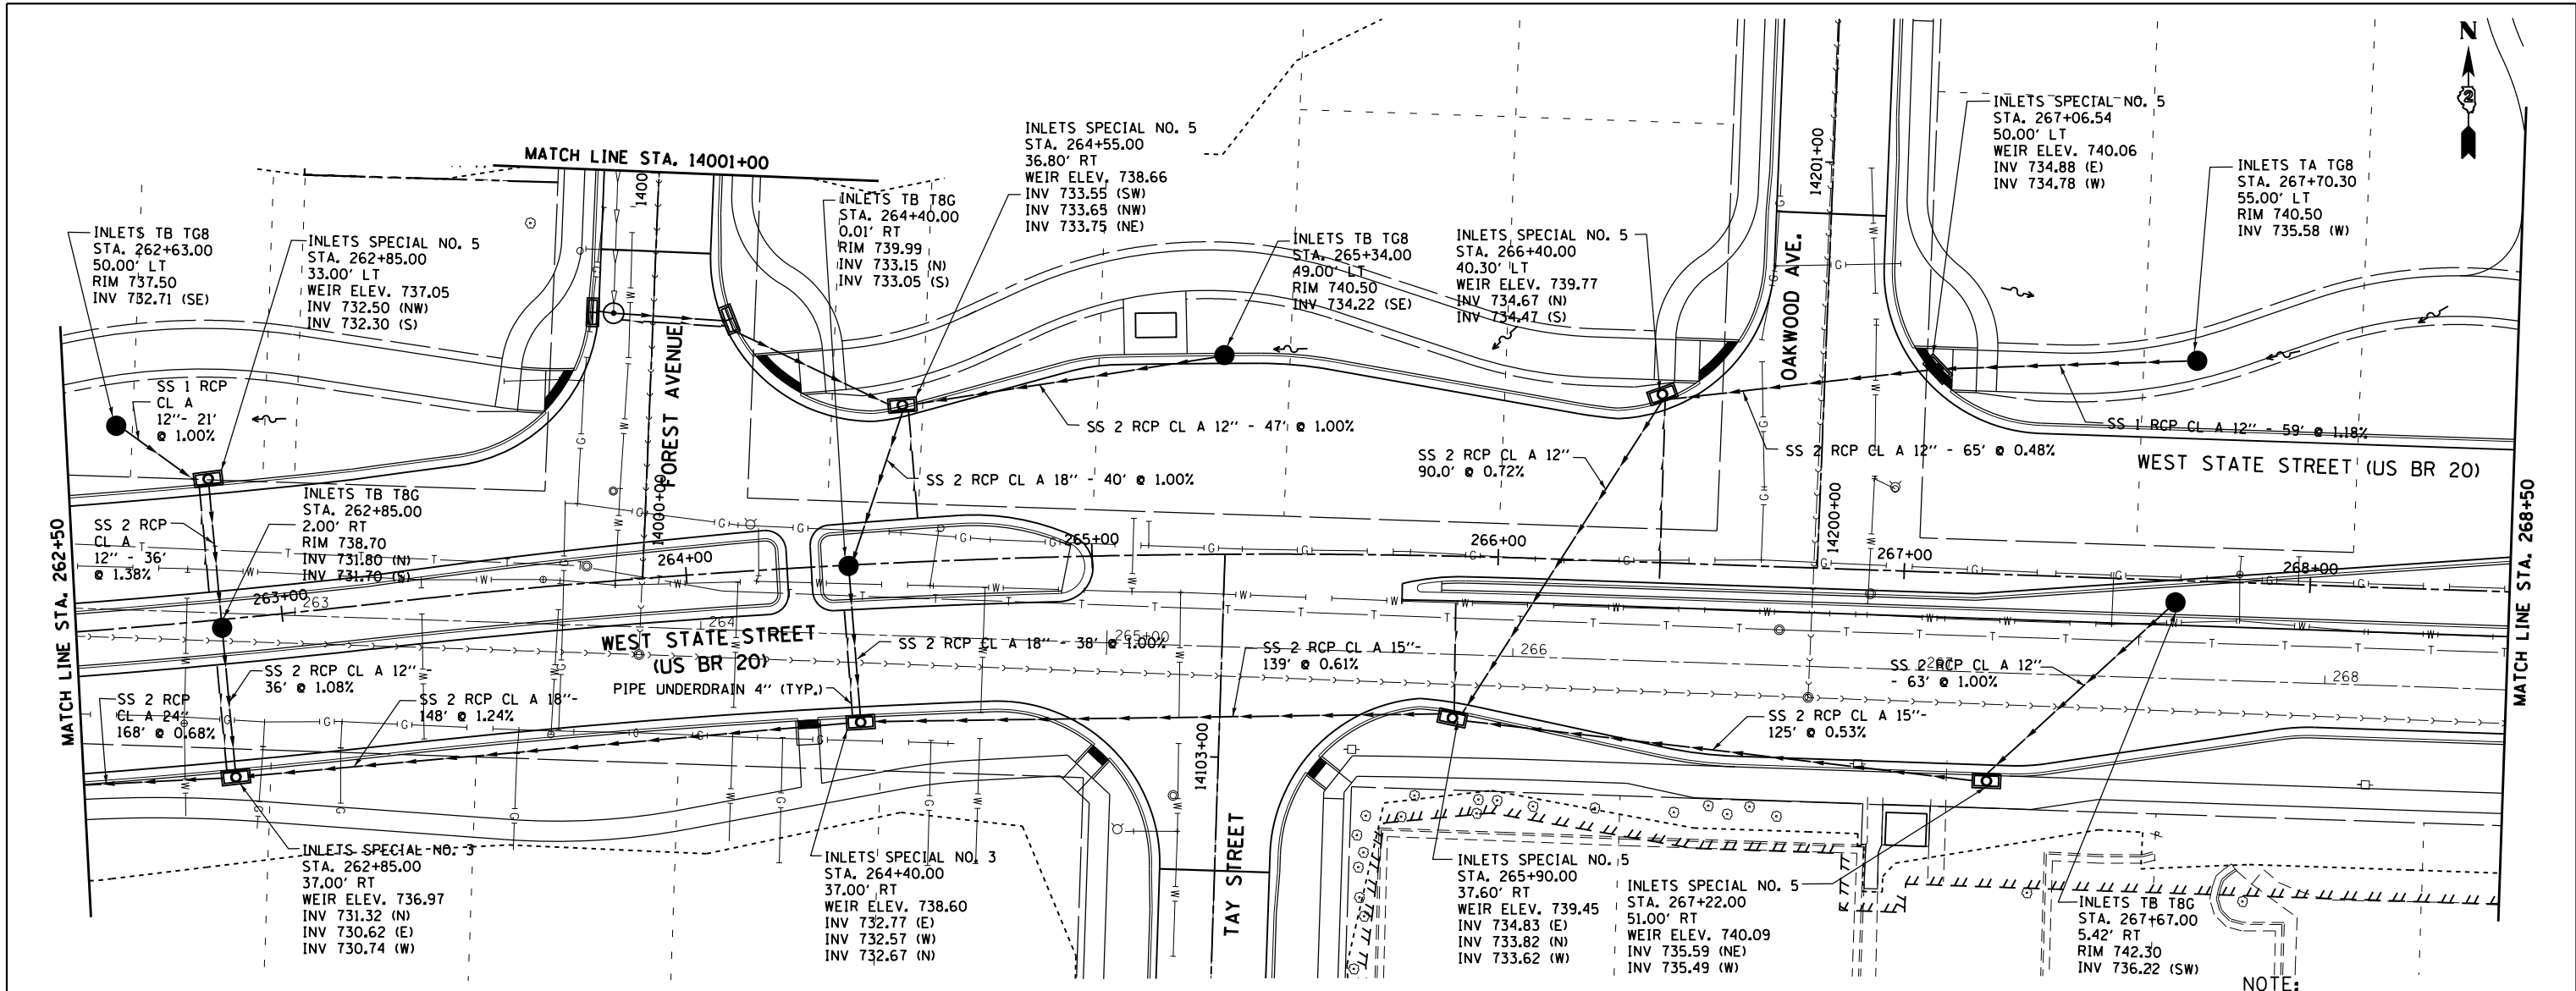

NOTE:
SEE SHEET DU-1 FOR LEGEND

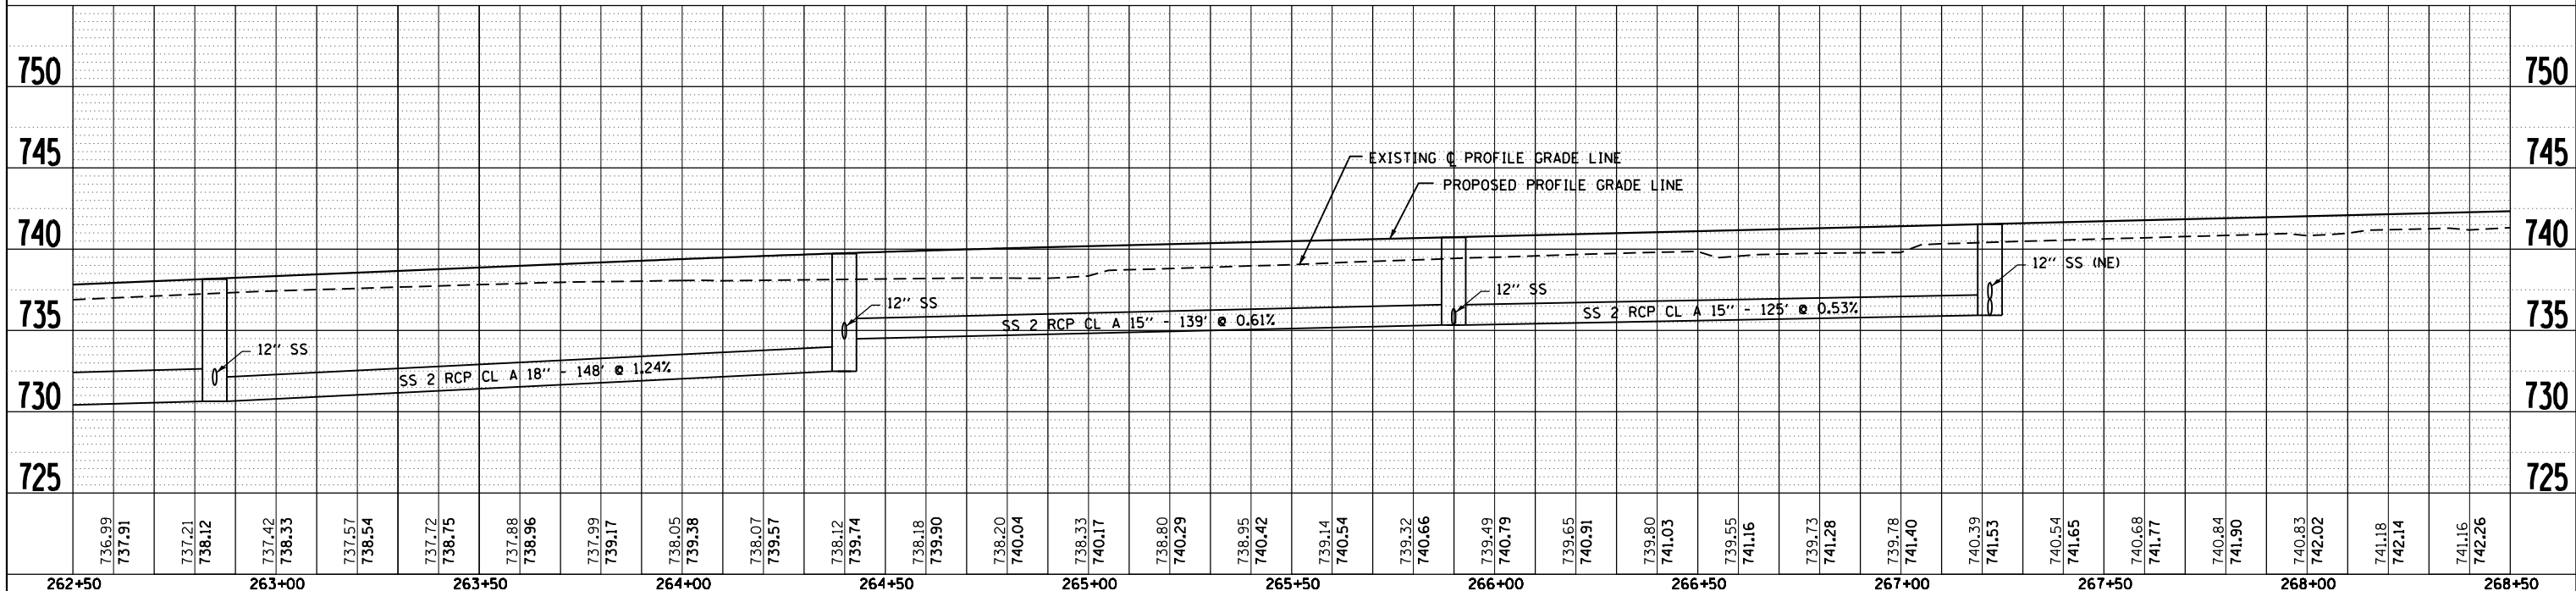

736.99	737.91	737.21	738.12	737.42	738.33	737.57	738.54	737.72	738.75	737.88	738.96	737.99	739.17	738.05	739.38	738.07	739.57	738.12	739.74	738.18	739.90	738.20	740.04	738.33	740.17	738.80	740.29	738.95	740.42	739.14	740.54	739.32	740.66	739.49	740.79	739.65	740.91	739.80	741.03	739.55	741.16	739.73	741.28	739.78	741.40	740.39	741.53	740.54	741.65	740.68	741.77	740.84	741.90	740.83	742.02	741.18	742.14	741.16	742.26	262+50	263+00	263+50	264+00	264+50	265+00	265+50	266+00	266+50	267+00	267+50	268+00	268+50
FILE NAME =		USER NAME = dssdd		DESIGNED - EJD		REVISED -		DRAWN - EJD		REVISED -		CHECKED - RCH		REVISED -		DATE - \$SUBDATE\$		REVISED -		STATE OF ILLINOIS DEPARTMENT OF TRANSPORTATION										PROPOSED DRAINAGE PLAN AND PROFILE WEST STATE ST (US BUS 20)										SCALE:		SHEET NO. 5 OF 21 SHEETS		STA. TO STA.		F.A.P. RTE. SECTION COUNTY TOTAL SHEETS SHEET NO.																										
c:\pwork\pwork\dssdd\0317619\0264750		sh-t-drain-149.dgn																																						303		41R		WINNEBAGO 327 149		CONTRACT NO. 64750																										
PLOT SCALE = 40.0000' / in.		PLOT DATE = Mon Dec 17 14:51:01 2012		DATE - \$SUBDATE\$																																				FED. ROAD DIST. NO. 2 ILLINOIS FED. AID PROJECT																																