



PLAN	SURVEYED	DATE
	PLOTTED	
	NOTE BOOK	
	NO.	
	CHECKED	
	FILE NAME	

PROFILE	SURVEYED	DATE
	PLOTTED	
	GRADES CHECKED	
	STRUCTURE NOTATIONS CHECKED	
	NO.	

McDonough Associates Inc.
 Engineers / Architects
 130 East Randolph Street Chicago, Illinois 60601

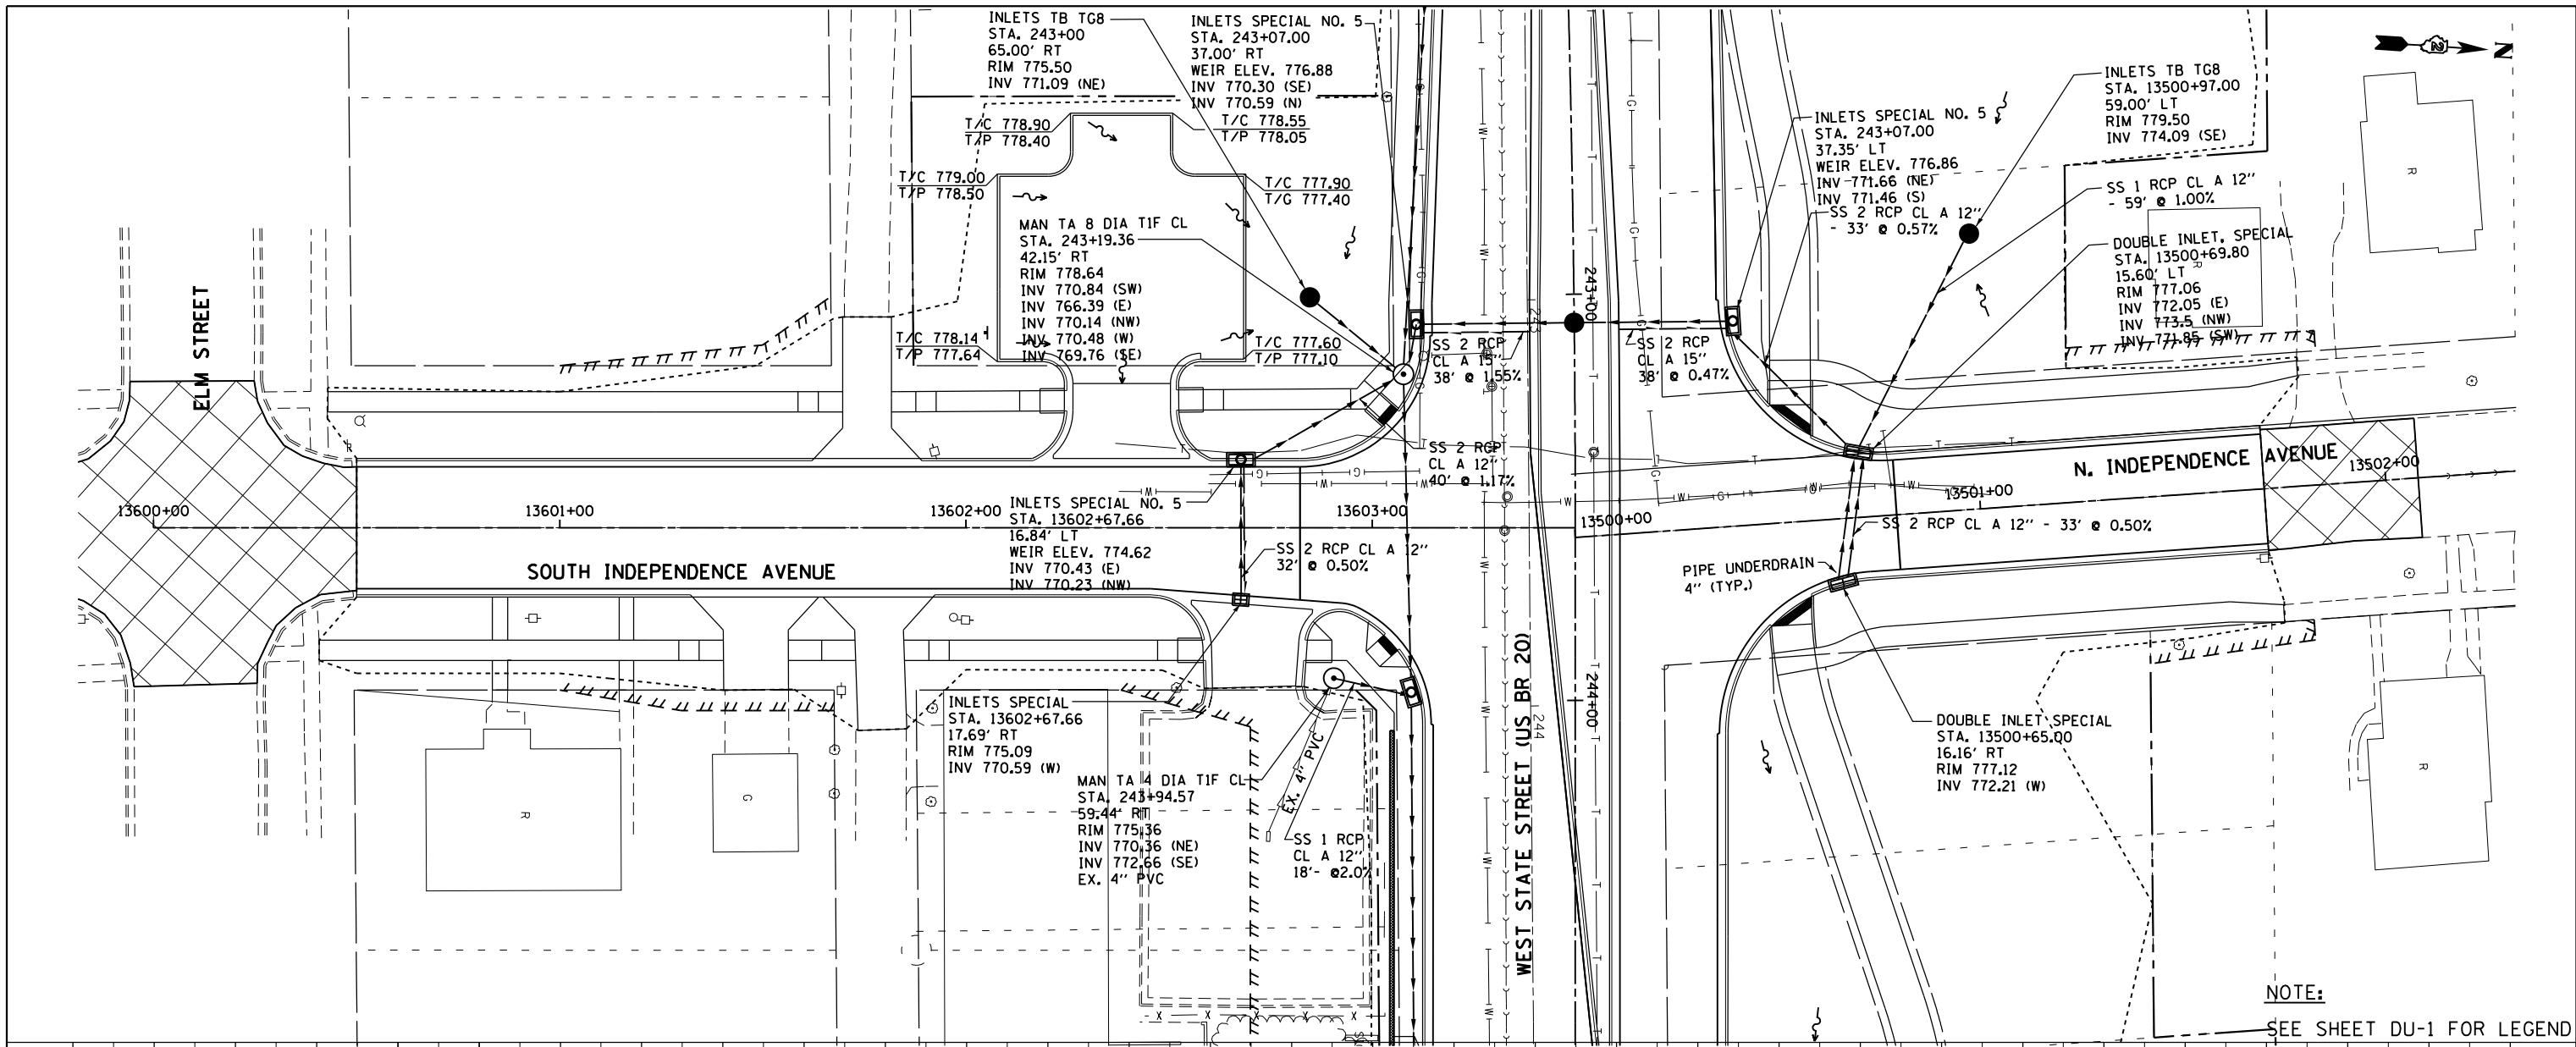

NOTE:
 SEE SHEET DU-1 FOR LEGEND

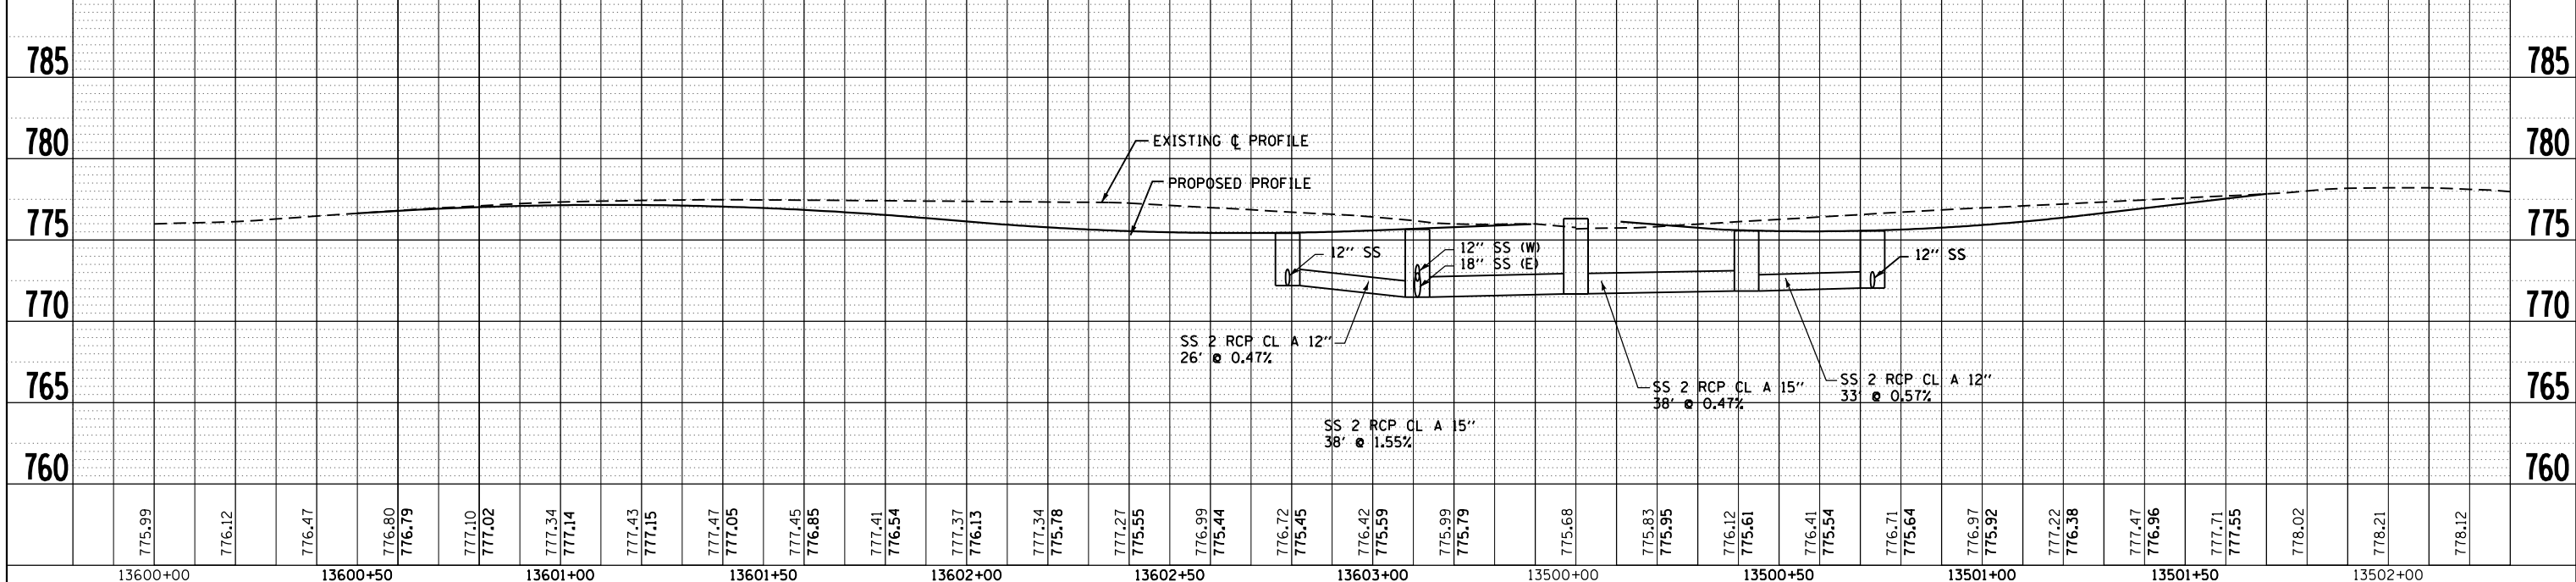

FILE NAME =	USER NAME = dossed	DESIGNED - EJD	REVISED -
c:\pwork\pwork\dossed\0317619\0264750	shd-drain-153.dgn	DRAWN - EJD	REVISED -
PLOT SCALE = 40.0000' / in.	CHECKED - RCH	REVISED -	REVISED -
PLOT DATE = Mon Dec 17 15:30:17 2012	DATE - \$SUBDATE\$	REVISED -	REVISED -

STATE OF ILLINOIS
 DEPARTMENT OF TRANSPORTATION

PROPOSED DRAINAGE PLAN AND PROFILE
 INDEPENDENCE AVENUE

SCALE: SHEET NO. 9 OF 21 SHEETS STA. TO STA.

F.A.P. RFE.	SECTION	COUNTY	TOTAL SHEETS	SHEET NO.
303	41R	WINNEBAGO	327	153
FED. ROAD DIST. NO. 2 ILLINOIS FED. AID PROJECT			CONTRACT NO. 64750	