


PLAN	SURVEYED	DATE
	PLOTTED	
	ALIGNED	
	CHECKED	
	FILE NAME	
	NO.	

PROFILE	SURVEYED	DATE
	PLOTTED	
	GRADES CHECKED	
	STRUCTURE NOTATIONS CHECKED	
	NO.	

McDonough Associates Inc.
 Engineers / Architects
 130 East Randolph Street Chicago, Illinois 60601

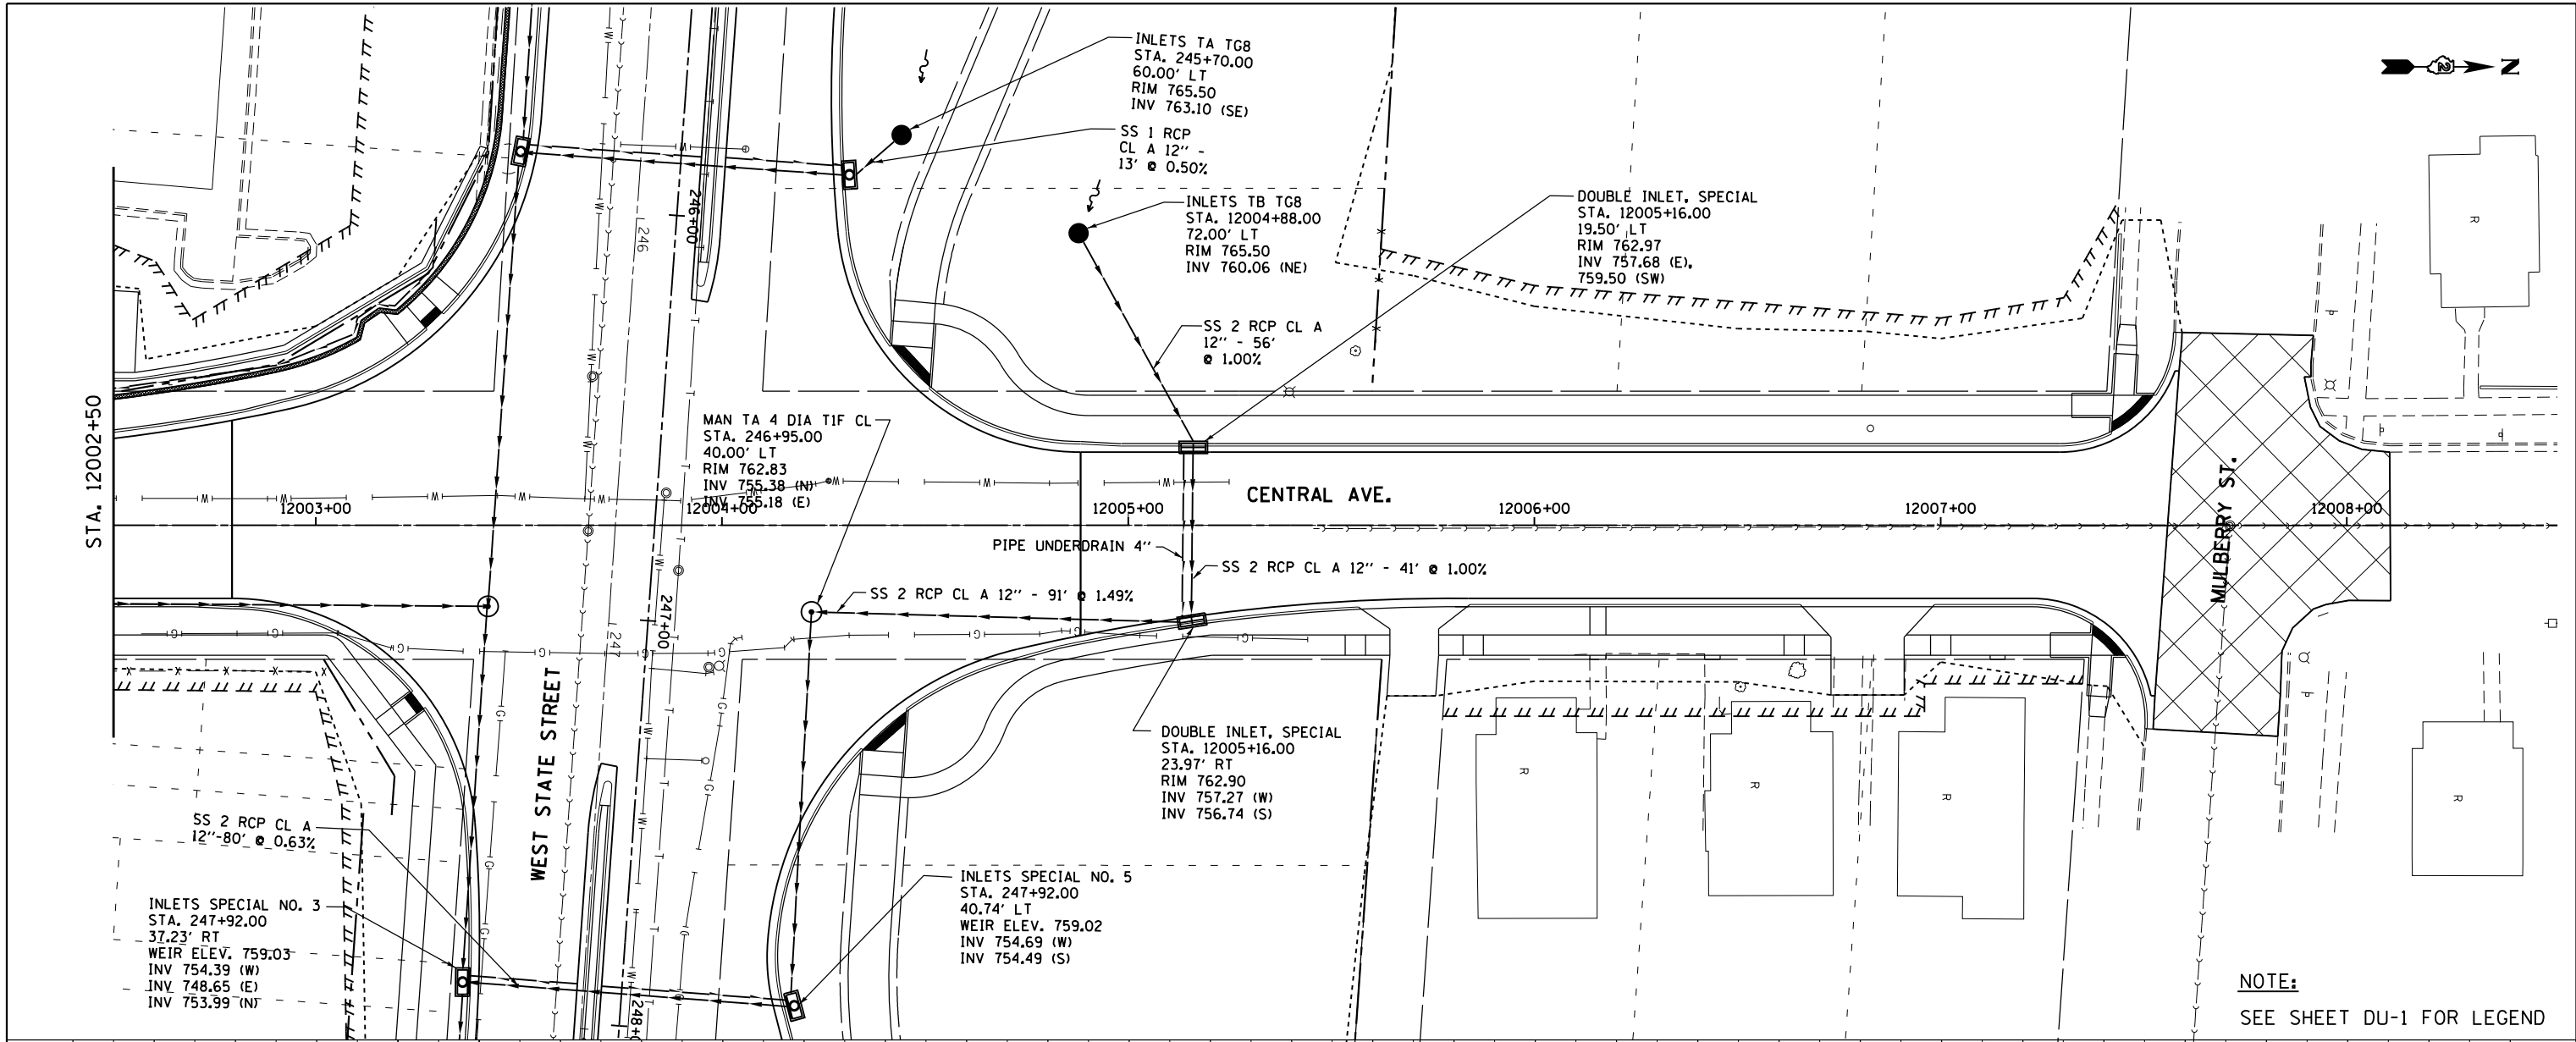

NOTE:
SEE SHEET DU-1 FOR LEGEND



FILE NAME =	USER NAME = dossed	DESIGNED - EJD	REVISED -	STATE OF ILLINOIS DEPARTMENT OF TRANSPORTATION	PROPOSED DRAINAGE PLAN AND PROFILE CENTRAL AVENUE		F.A.P. R.E.	SECTION	COUNTY	TOTAL SHEETS	SHEET NO.
c:\pwork\pwork\dossed\0317619\0264750	sh-drain-155.dgn	DRAWN - EJD	REVISED -		303	41R	WINNEBAGO	327	155		
		CHECKED - RCH	REVISED -		SCALE: SHEET NO. 11 OF 21 SHEETS STA. TO STA.		CONTRACT NO. 64750				
		DATE - \$SUBDATE\$	REVISED -		FED. ROAD DIST. NO. 2 ILLINOIS FED. AID PROJECT						