





PLAN	SURVEYED	DATE
	PLOTTED	
	ALIGNED	
	CHECKED	
	FILED	
	NO.	

PROFILE	SURVEYED	DATE
	PLOTTED	
	GRADES	
	CHECKED	
	STRUCTURE	
	NOTATIONS	
	CPAD	
	NO.	

McDonough Associates Inc.  
 Engineers / Architects  
 130 East Randolph Street Chicago, Illinois 60601

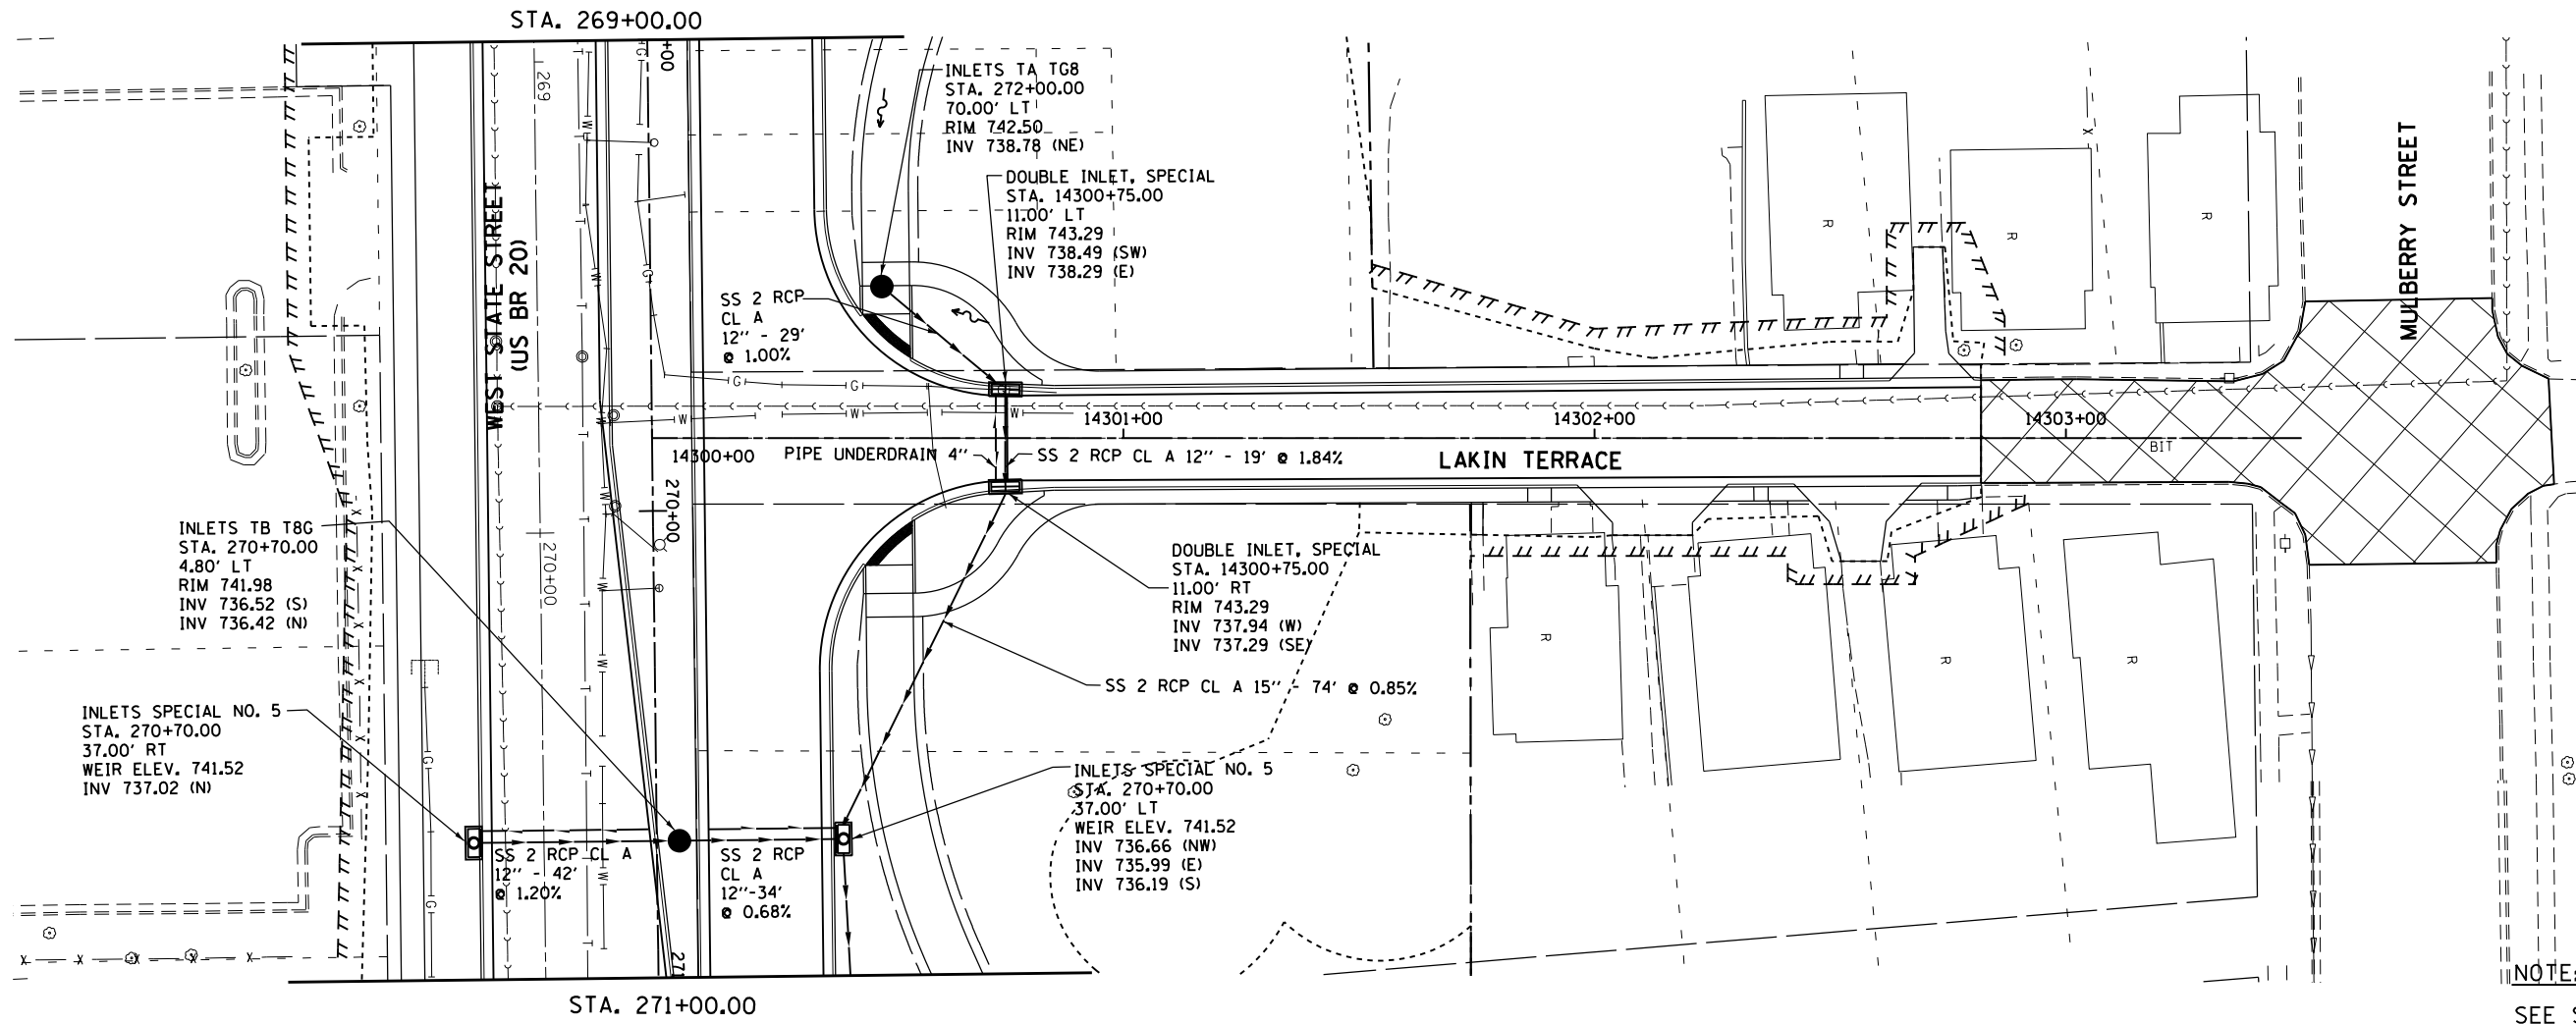

NOTE:  
 SEE SHEET DU-1 FOR LEGEND

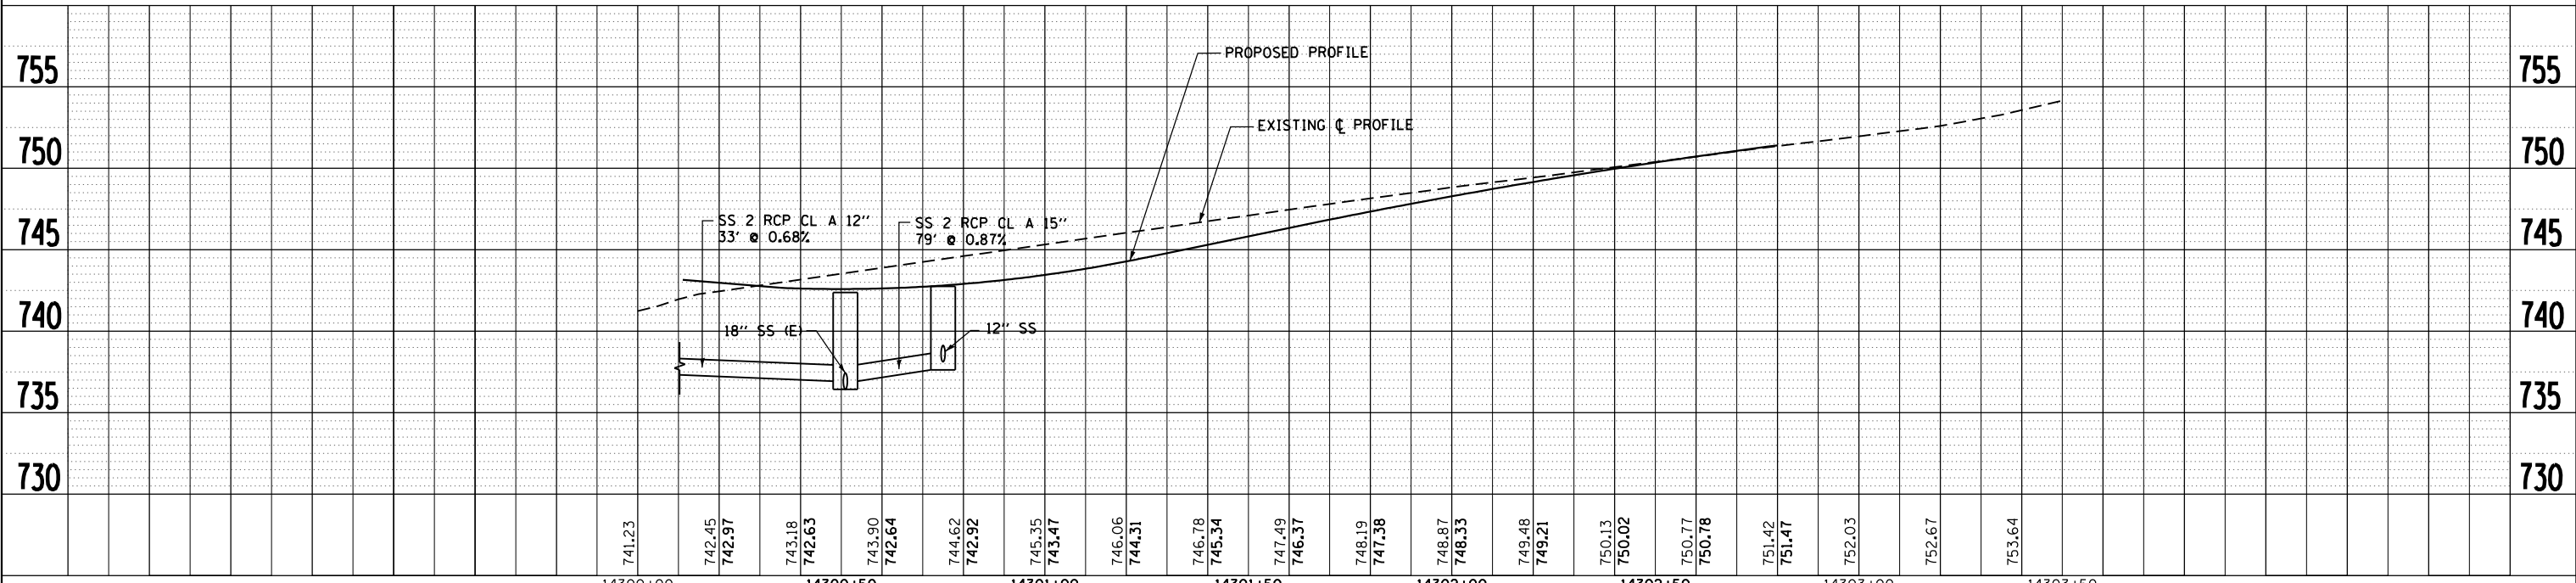

FILE NAME =	USER NAME = dssdd	DESIGNED - EJD	REVISED -	<b>STATE OF ILLINOIS DEPARTMENT OF TRANSPORTATION</b>	<b>PROPOSED DRAINAGE PLAN AND PROFILE LAKIN TERRACE</b>		F.A.P. R.E. = 303	SECTION = 41R	COUNTY = WINNEBAGO	TOTAL SHEETS = 327	SHEET NO. = 159
c:\pwork\pwork\dssdd\0317619\0264750	sh-t-drain-159.dgn	DRAWN - EJD	REVISED -		SCALE:	SHEET NO. 15 OF 21 SHEETS	STA. TO STA.	CONTRACT NO. 64750		FED. ROAD DIST. NO. 2 ILLINOIS FED. AID PROJECT	
		CHECKED - RCH	REVISED -								
		DATE - \$SUBDATE\$	REVISED -								