



PLAN	SURVEYED	BY	DATE
	PLOTTED		
	NOTE BOOK		
	NO.		
	ALIGNED		
	CHECKED		
	FILE NAME		

PROFILE	SURVEYED	BY	DATE
	PLOTTED		
	GRADES CHECKED		
	NO.		
	STRUCTURE		
	NOTATIONS		
	CPAD		

McDonough Associates Inc.  
 Engineers / Architects  
 130 East Randolph Street Chicago, Illinois 60601

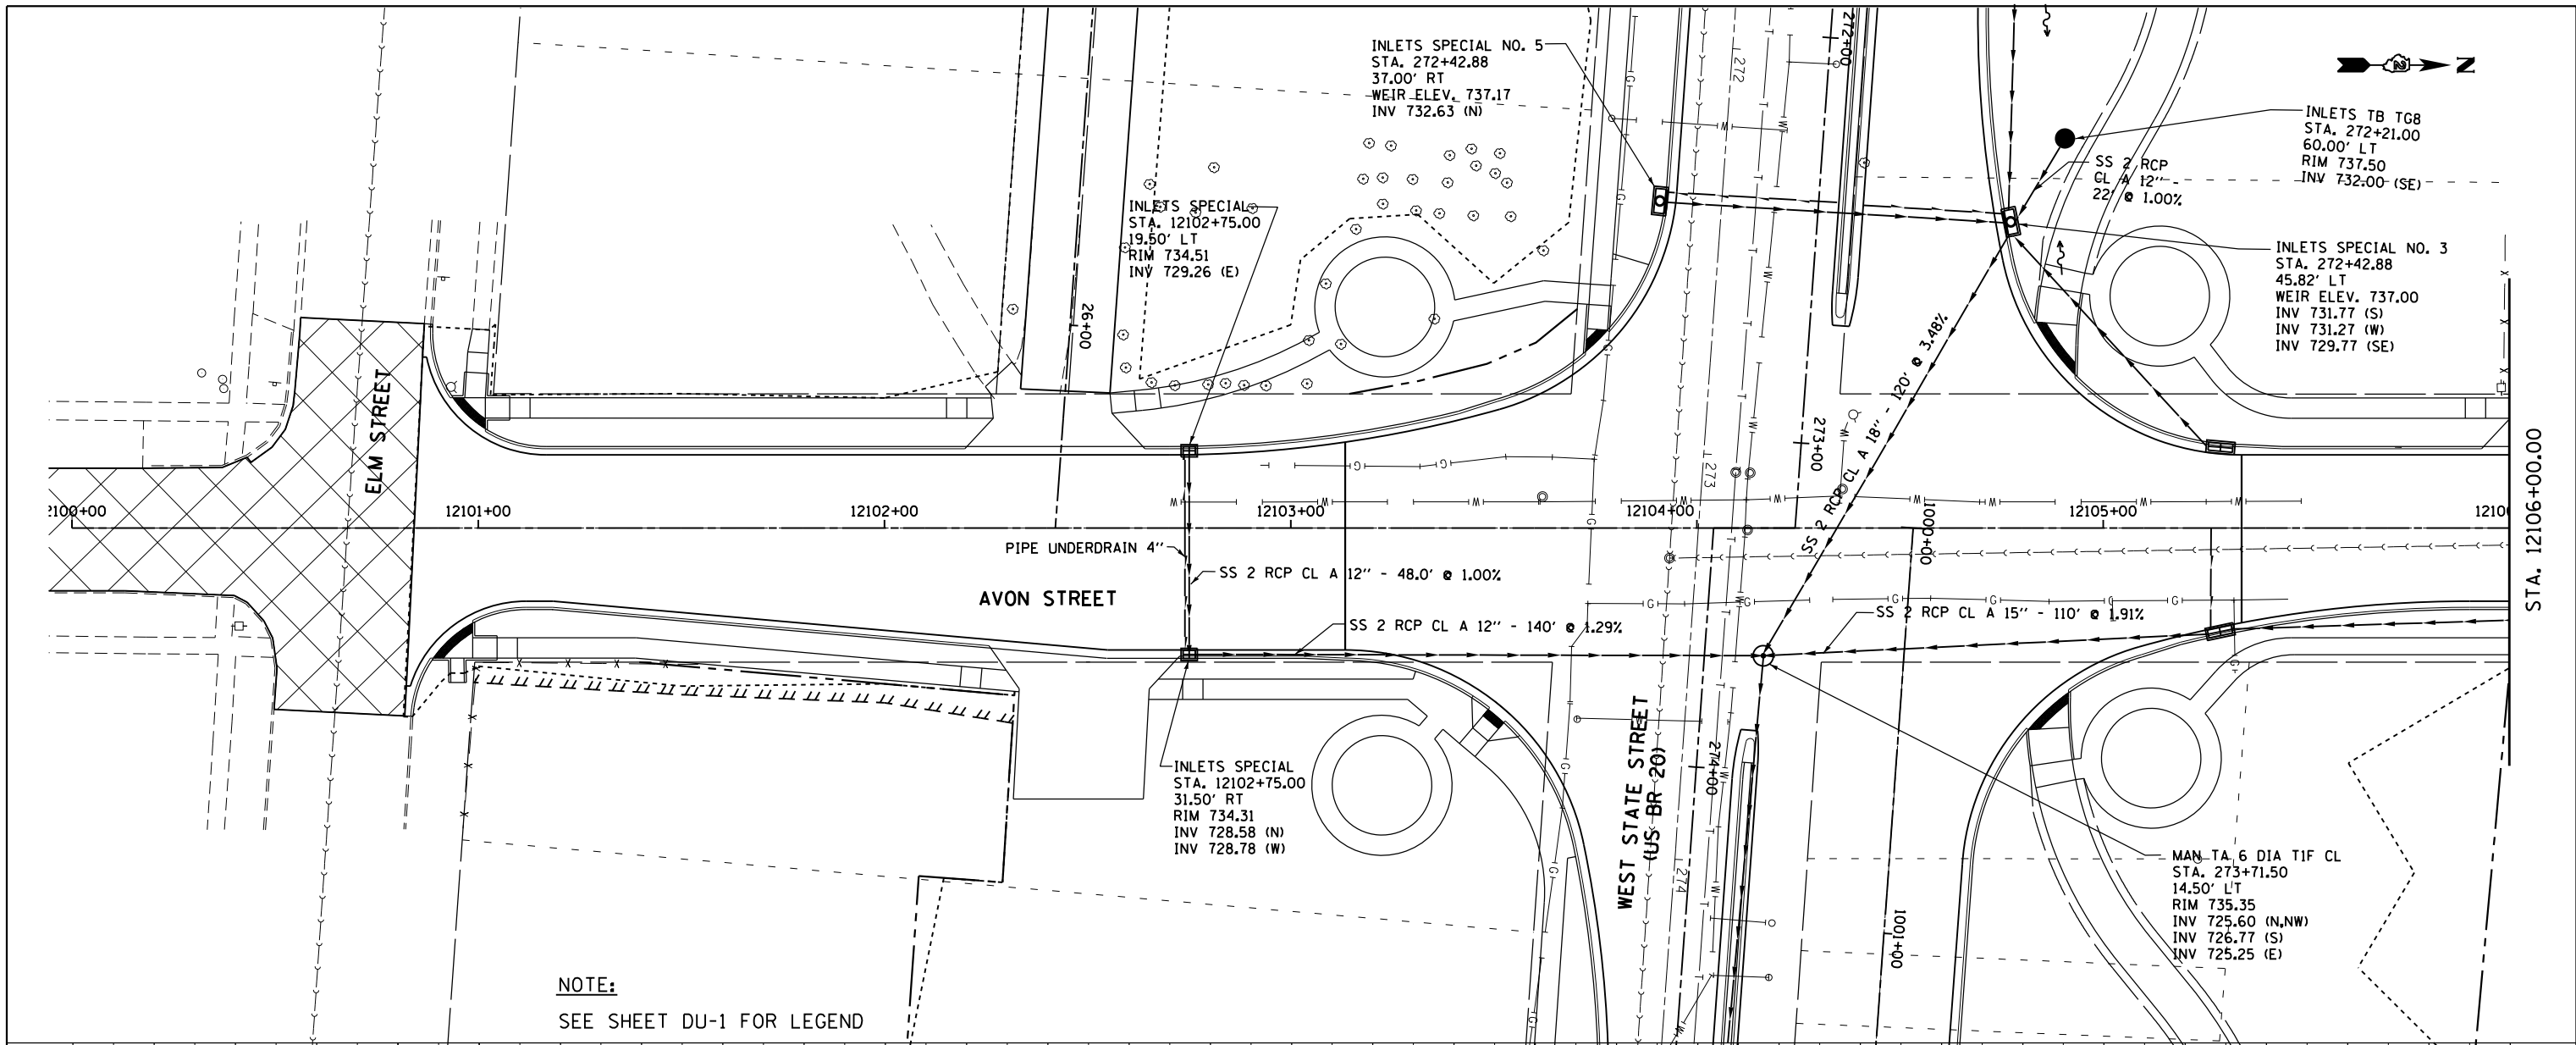

**NOTE:**  
 SEE SHEET DU-1 FOR LEGEND

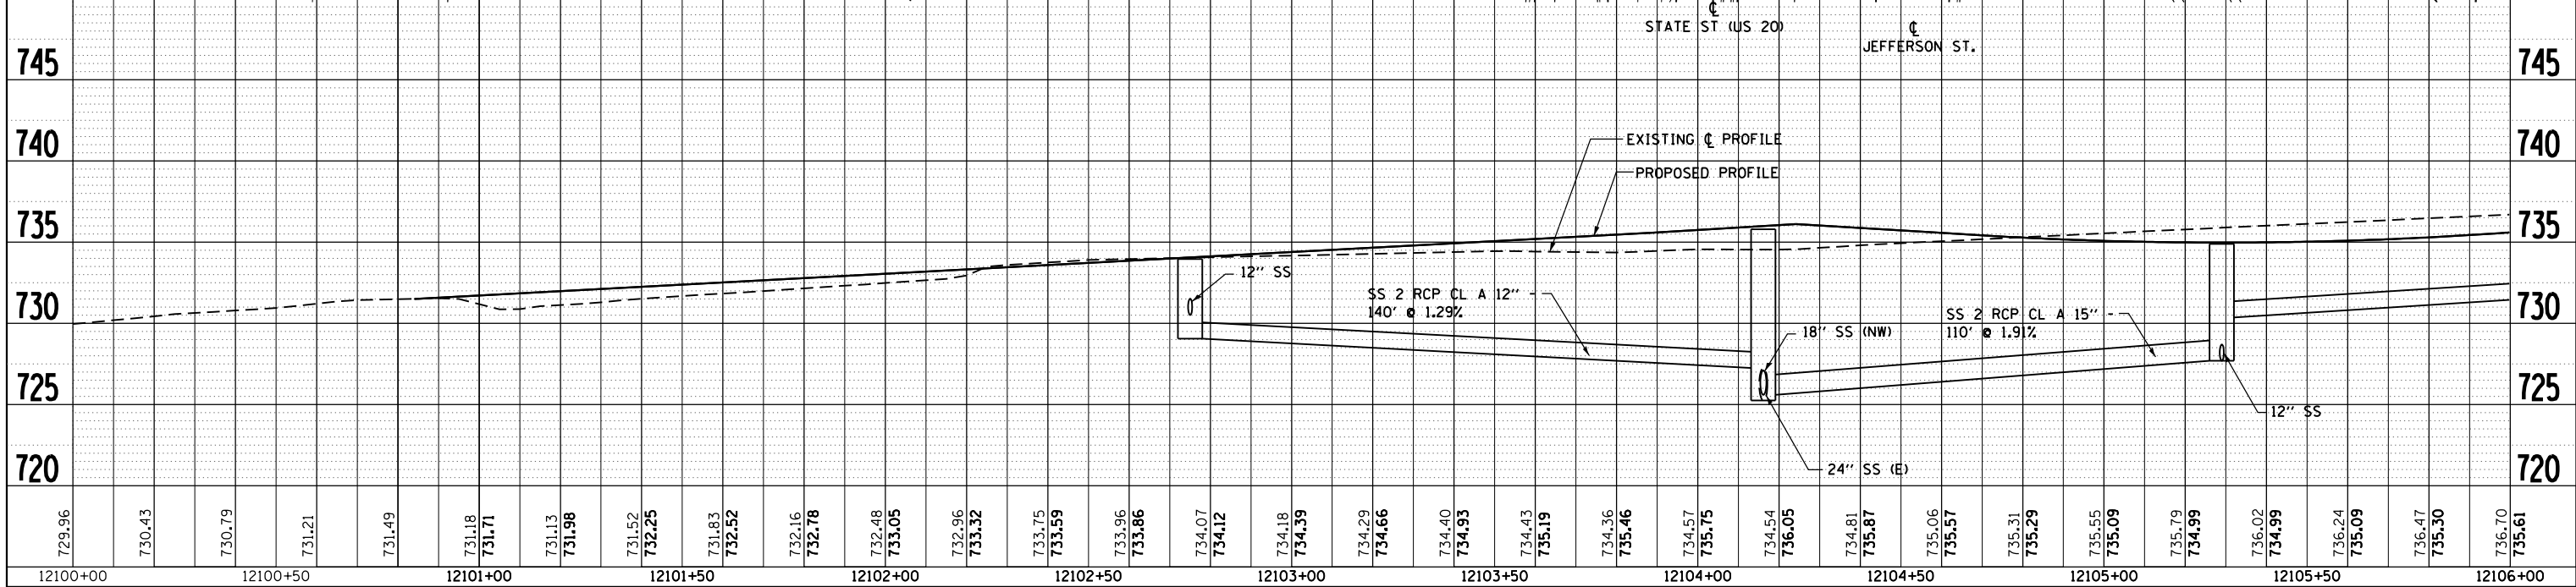

FILE NAME =	USER NAME = dssdd	DESIGNED - EJD	REVISED -	<b>STATE OF ILLINOIS</b> <b>DEPARTMENT OF TRANSPORTATION</b>	<b>PROPOSED DRAINAGE PLAN AND PROFILE</b> <b>AVON STREET</b>	F.A.P. RT. = 303	SECTION = 41R	COUNTY = WINNEBAGO	TOTAL SHEETS = 327	SHEET NO. = 160
ct:\pwork\pwork\dssdd\0317619\0264750	shd-drain-160.dgn	DRAWN - EJD	REVISED -			CONTRACT NO. = 64750				
PLOT SCALE = 48.0000' / in.	CHECKED - RCH	REVISED -				FED. ROAD DIST. NO. 2 ILLINOIS FED. AID PROJECT				
PLOT DATE = Mon Dec 17 15:34:33 2012	DATE - \$SUBDATE\$	REVISED -								