
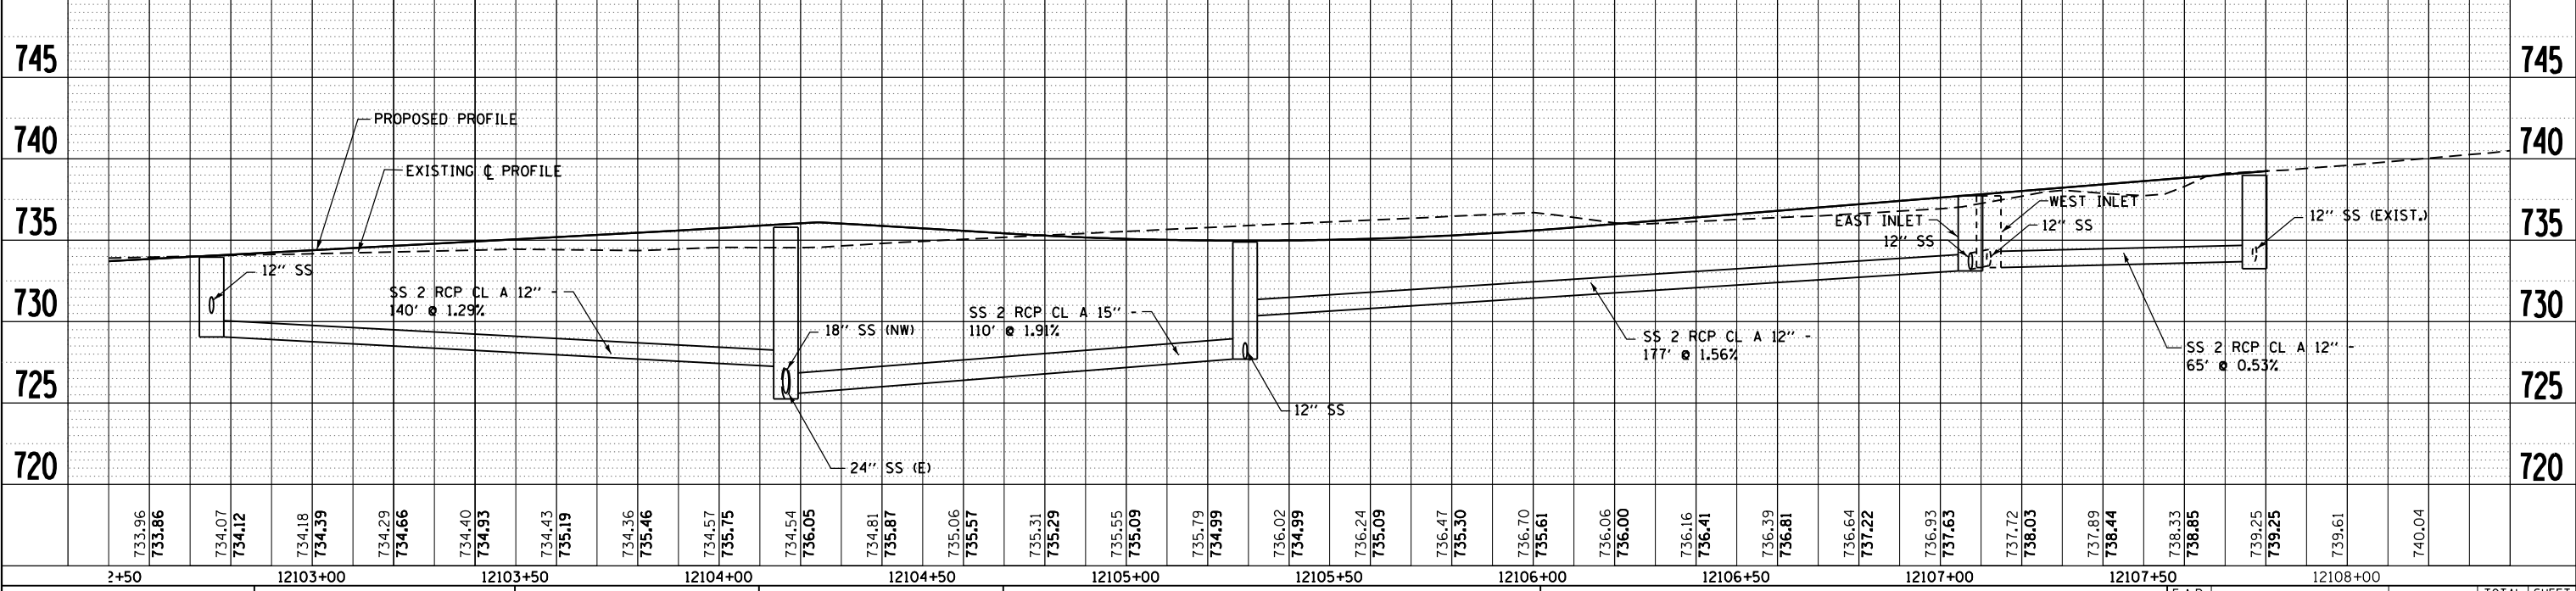


PLAN	SURVEYED	DATE
	PLOTTED	
	NOTE BOOK	
	NO.	

PROFILE	SURVEYED	DATE
	PLOTTED	
	NOTE BOOK	
	NO.	

McDonough Associates Inc.
 Engineers / Architects
 130 East Randolph Street Chicago, Illinois 60601

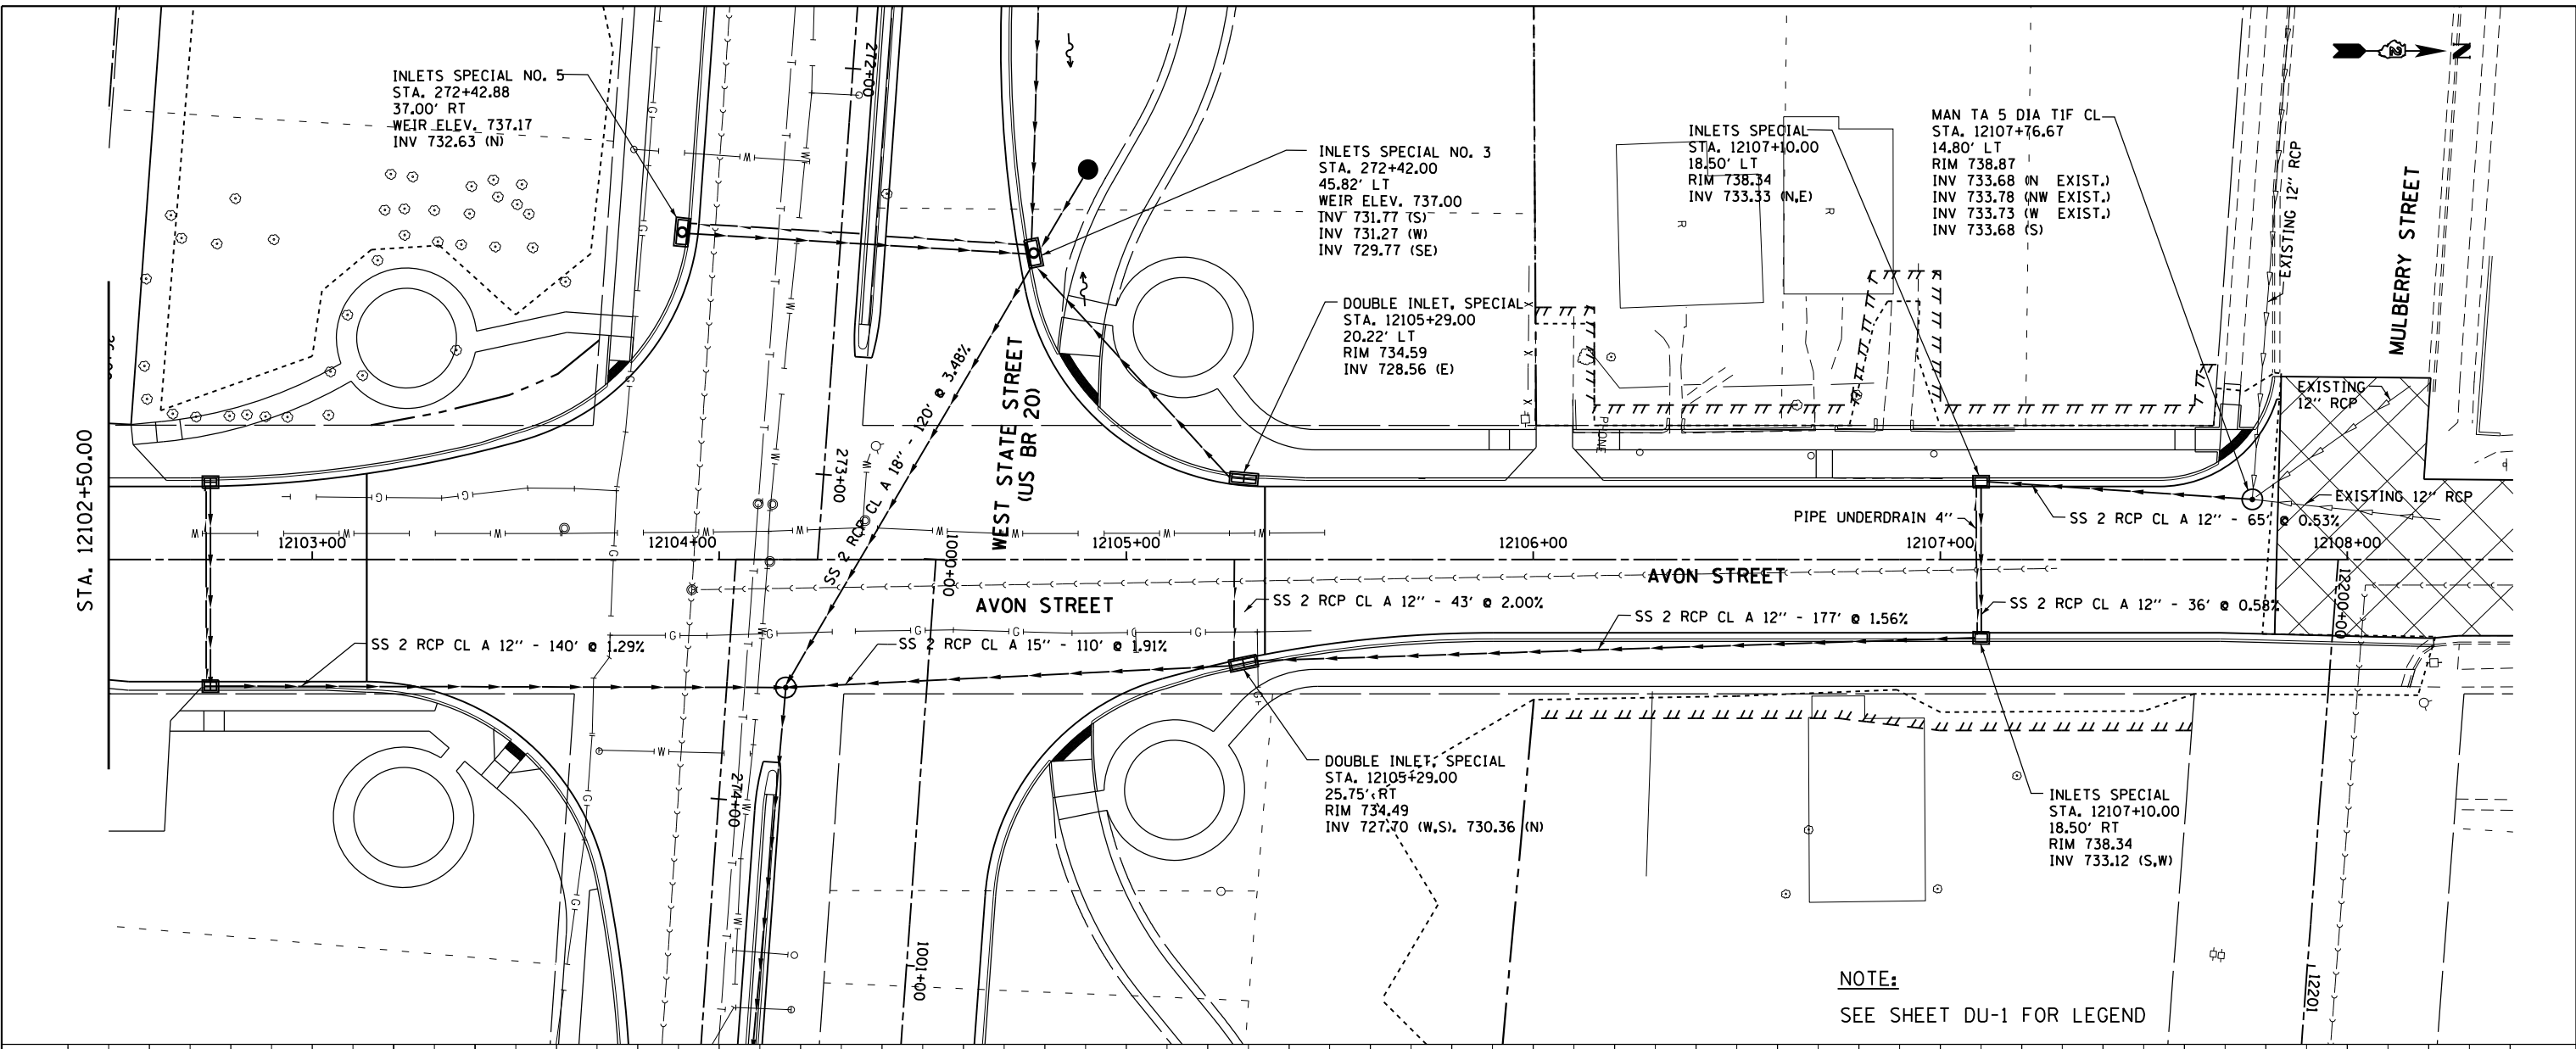

FILE NAME =	USER NAME = dossed	DESIGNED - EJD	REVISED -	STATE OF ILLINOIS DEPARTMENT OF TRANSPORTATION	PROPOSED DRAINAGE PLAN AND PROFILE AVON STREET		F.A.P. R.E.	SECTION	COUNTY	TOTAL SHEETS	SHEET NO.
c:\pwork\pwidot\dossed\161.dgn	sh-drain-161.dgn	DRAWN - EJD	REVISED -		303	41R	WINNEBAGO	327	161	CONTRACT NO. 64750	
PLOT SCALE = 40.0000' / in.		CHECKED - RCH	REVISED -		SCALE:	SHEET NO. 17 OF 21 SHEETS	STA.	TO STA.	FED. ROAD DIST. NO. 2 ILLINOIS FED. AID PROJECT		
PLOT DATE = Mon Dec 17 15:35:04 2012		DATE - \$SUBDATE\$	REVISED -								