



PLAN	SURVEYED	DATE
	PLOTTED	
	ALIGNED	
	CHECKED	
	FILED	
	NO.	

PROFILE	SURVEYED	DATE
	PLOTTED	
	GRADES CHECKED	
	STRUCTURE NOTATIONS CHECKED	
	NO.	

McDonough Associates Inc.
 Engineers / Architects
 130 East Randolph Street Chicago, Illinois 60601

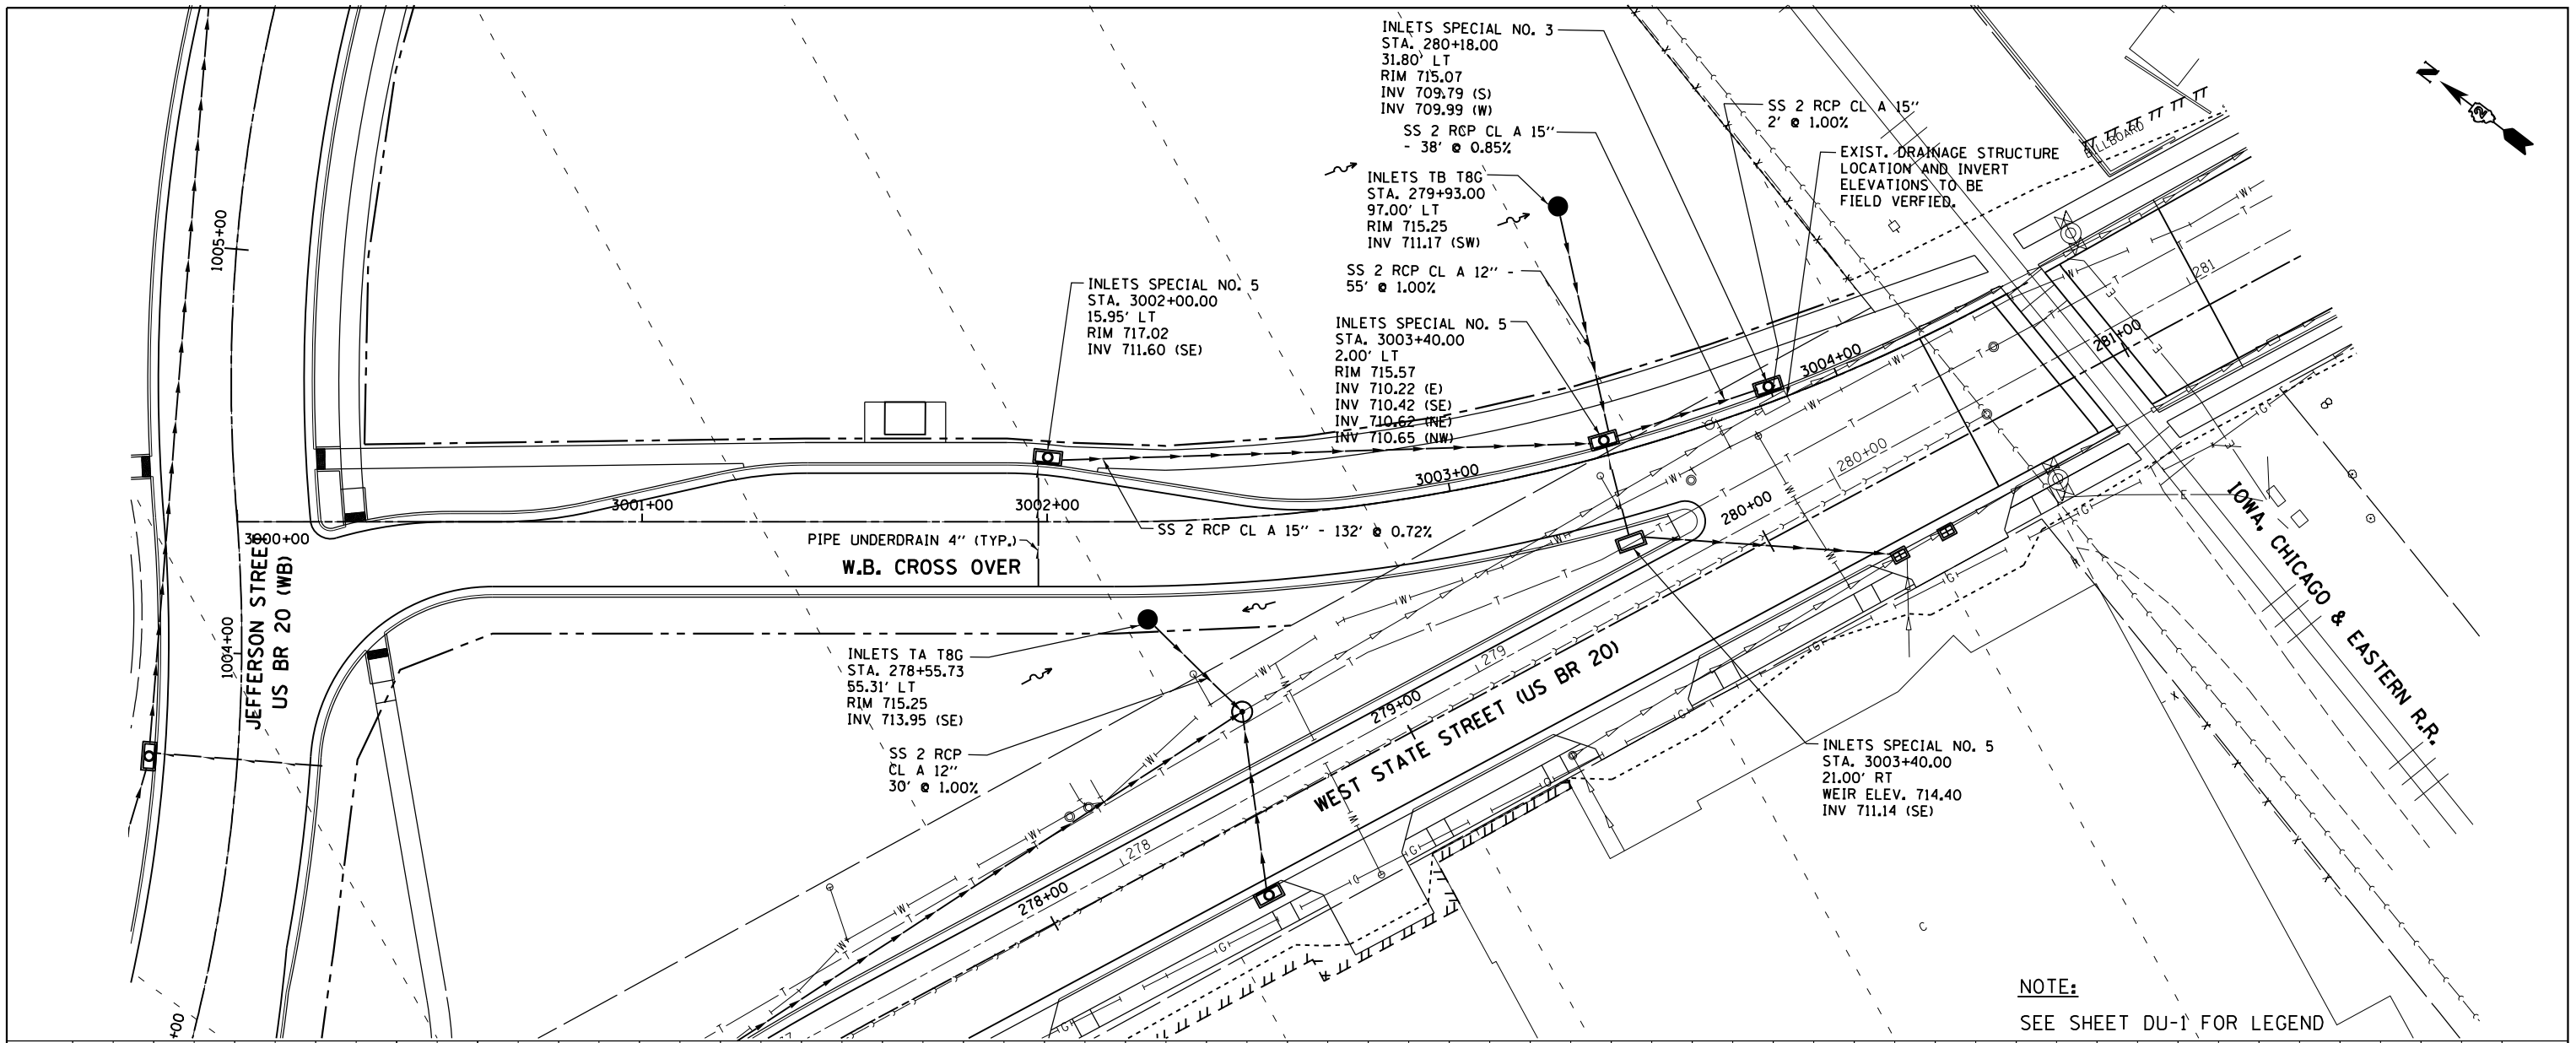

NOTE:
 SEE SHEET DU-1 FOR LEGEND

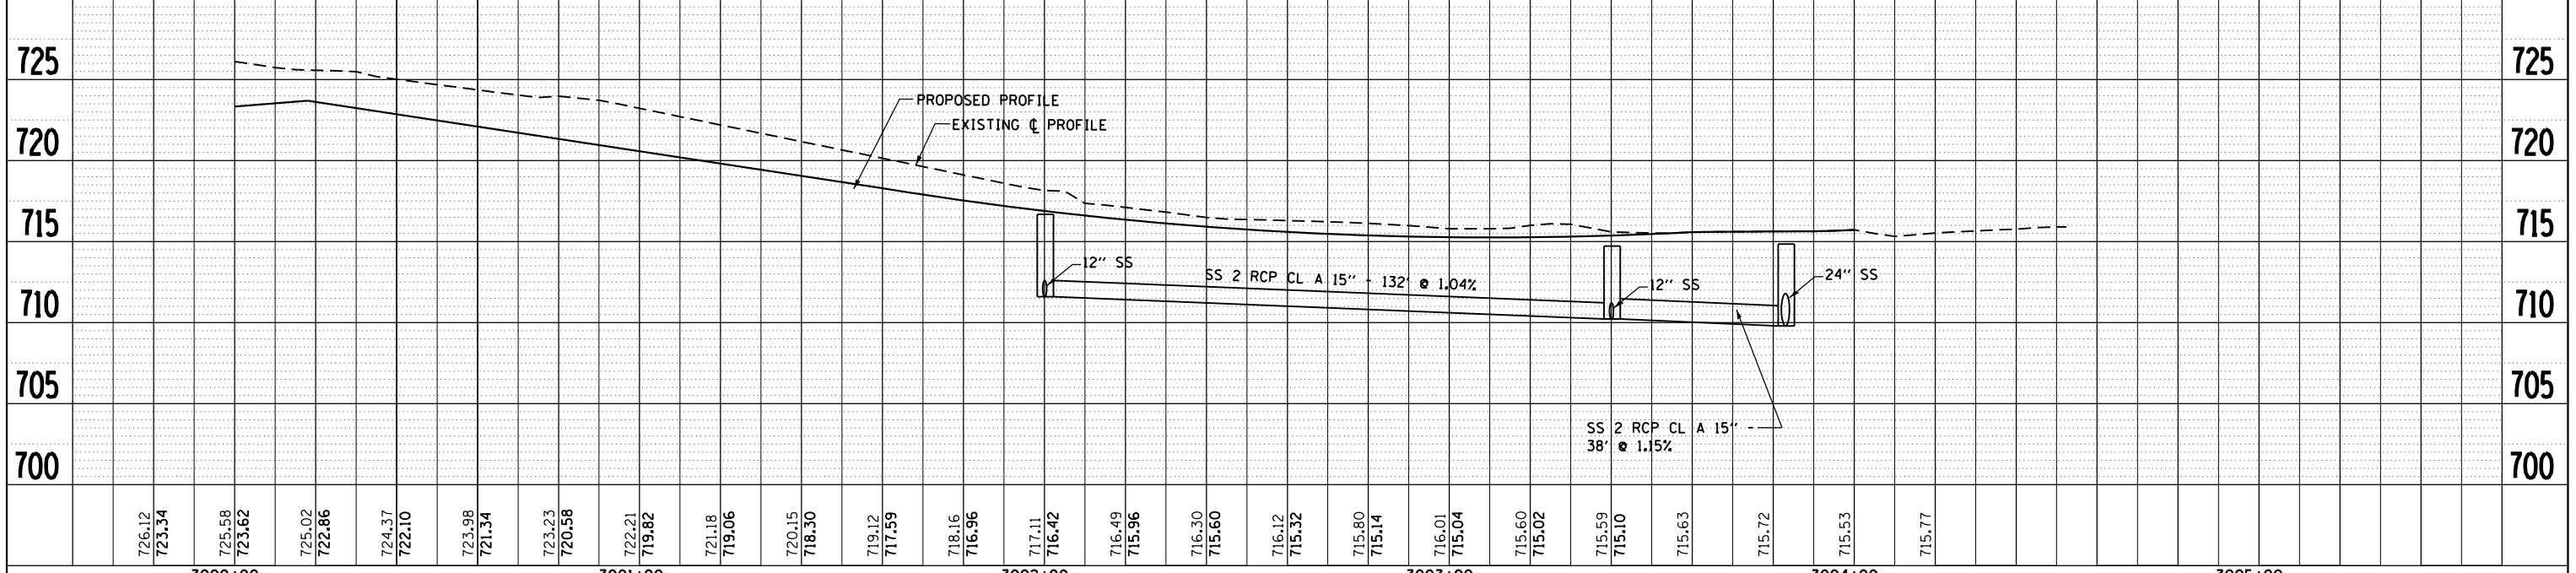

FILE NAME =	USER NAME = dssdd	DESIGNED - EJD	REVISED -
c:\pwork\pwork\dssdd\0317619\0264750	shd-drain-162.dgn	DRAWN - EJD	REVISED -
PLOT SCALE = 40.0000' / in.		CHECKED - RCH	REVISED -
PLOT DATE = Mon Dec 17 15:35:33 2012		DATE - \$SUBDATE\$	REVISED -

STATE OF ILLINOIS
 DEPARTMENT OF TRANSPORTATION

PROPOSED DRAINAGE PLAN AND PROFILE
 WB CROSS OVER

SCALE: SHEET NO. 18 OF 21 SHEETS STA. TO STA.

F.A.P. RTE.	SECTION	COUNTY	TOTAL SHEETS	SHEET NO.
303	41R	WINNEBAGO	327	162
FED. ROAD DIST. NO. 2 ILLINOIS FED. AID PROJECT			CONTRACT NO. 64750	