
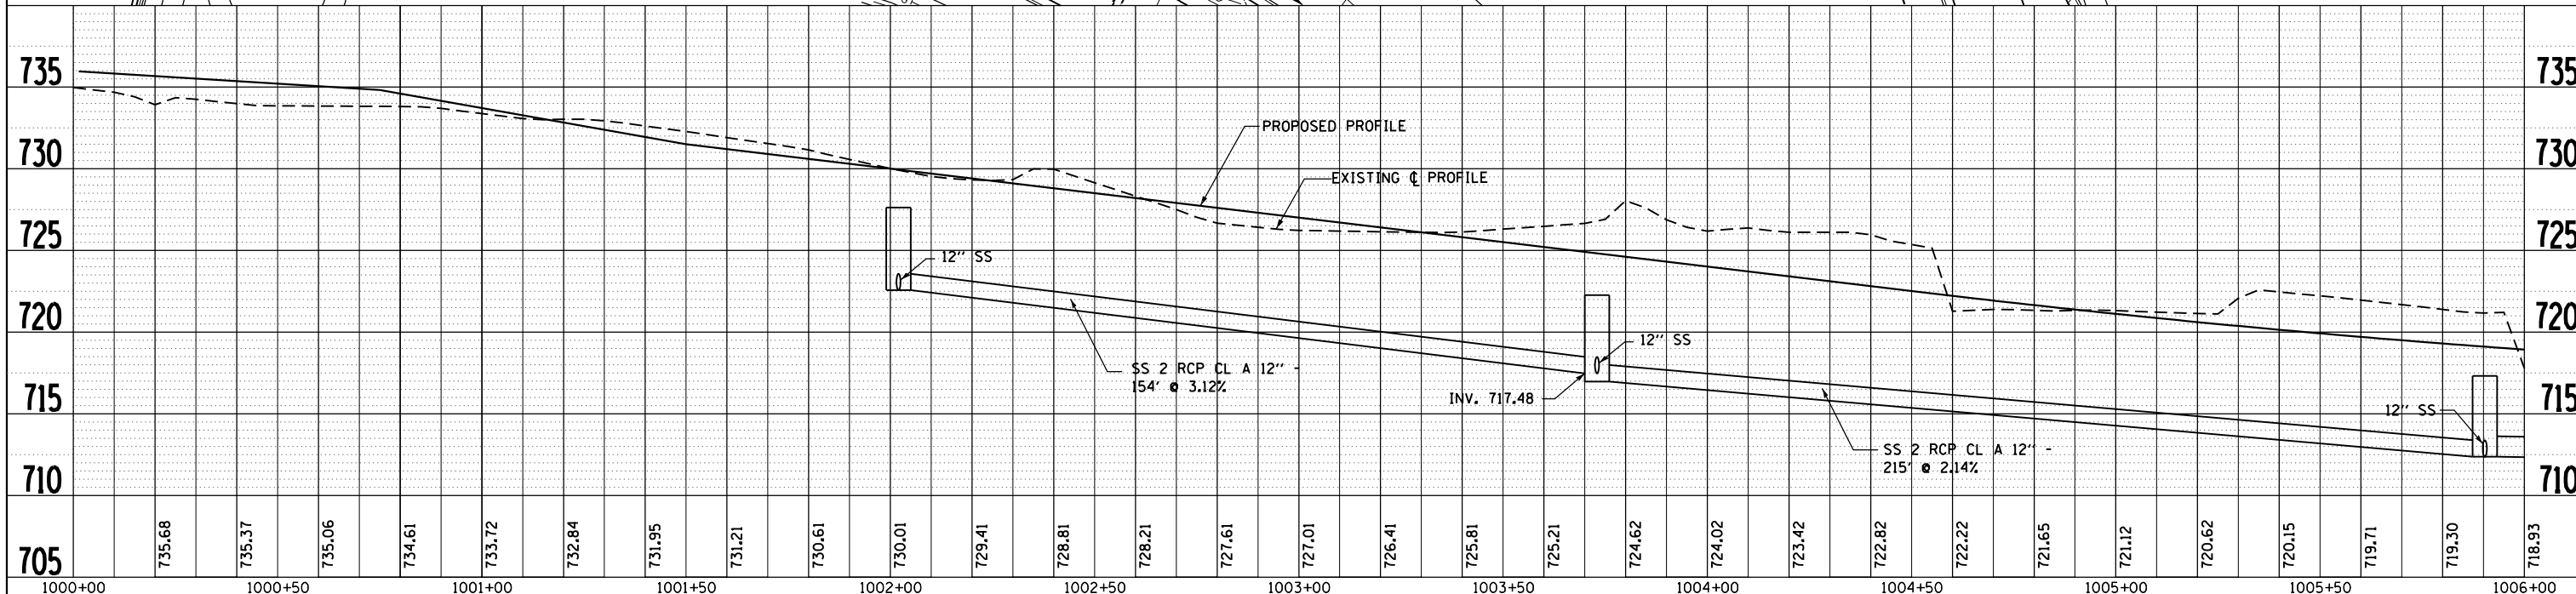


PLAN	SURVEYED	BY	DATE
	PLOTTED		
	ALIGNED		
	CHECKED		
	FILED		
	NO.		

PROFILE	SURVEYED	BY	DATE
	PLOTTED		
	GRADES		
	CHECKED		
	STRUCTURE		
	NOTATIONS		
	CPAD		
	NO.		

McDonough Associates Inc.
 Engineers / Architects
 130 East Randolph Street Chicago, Illinois 60601

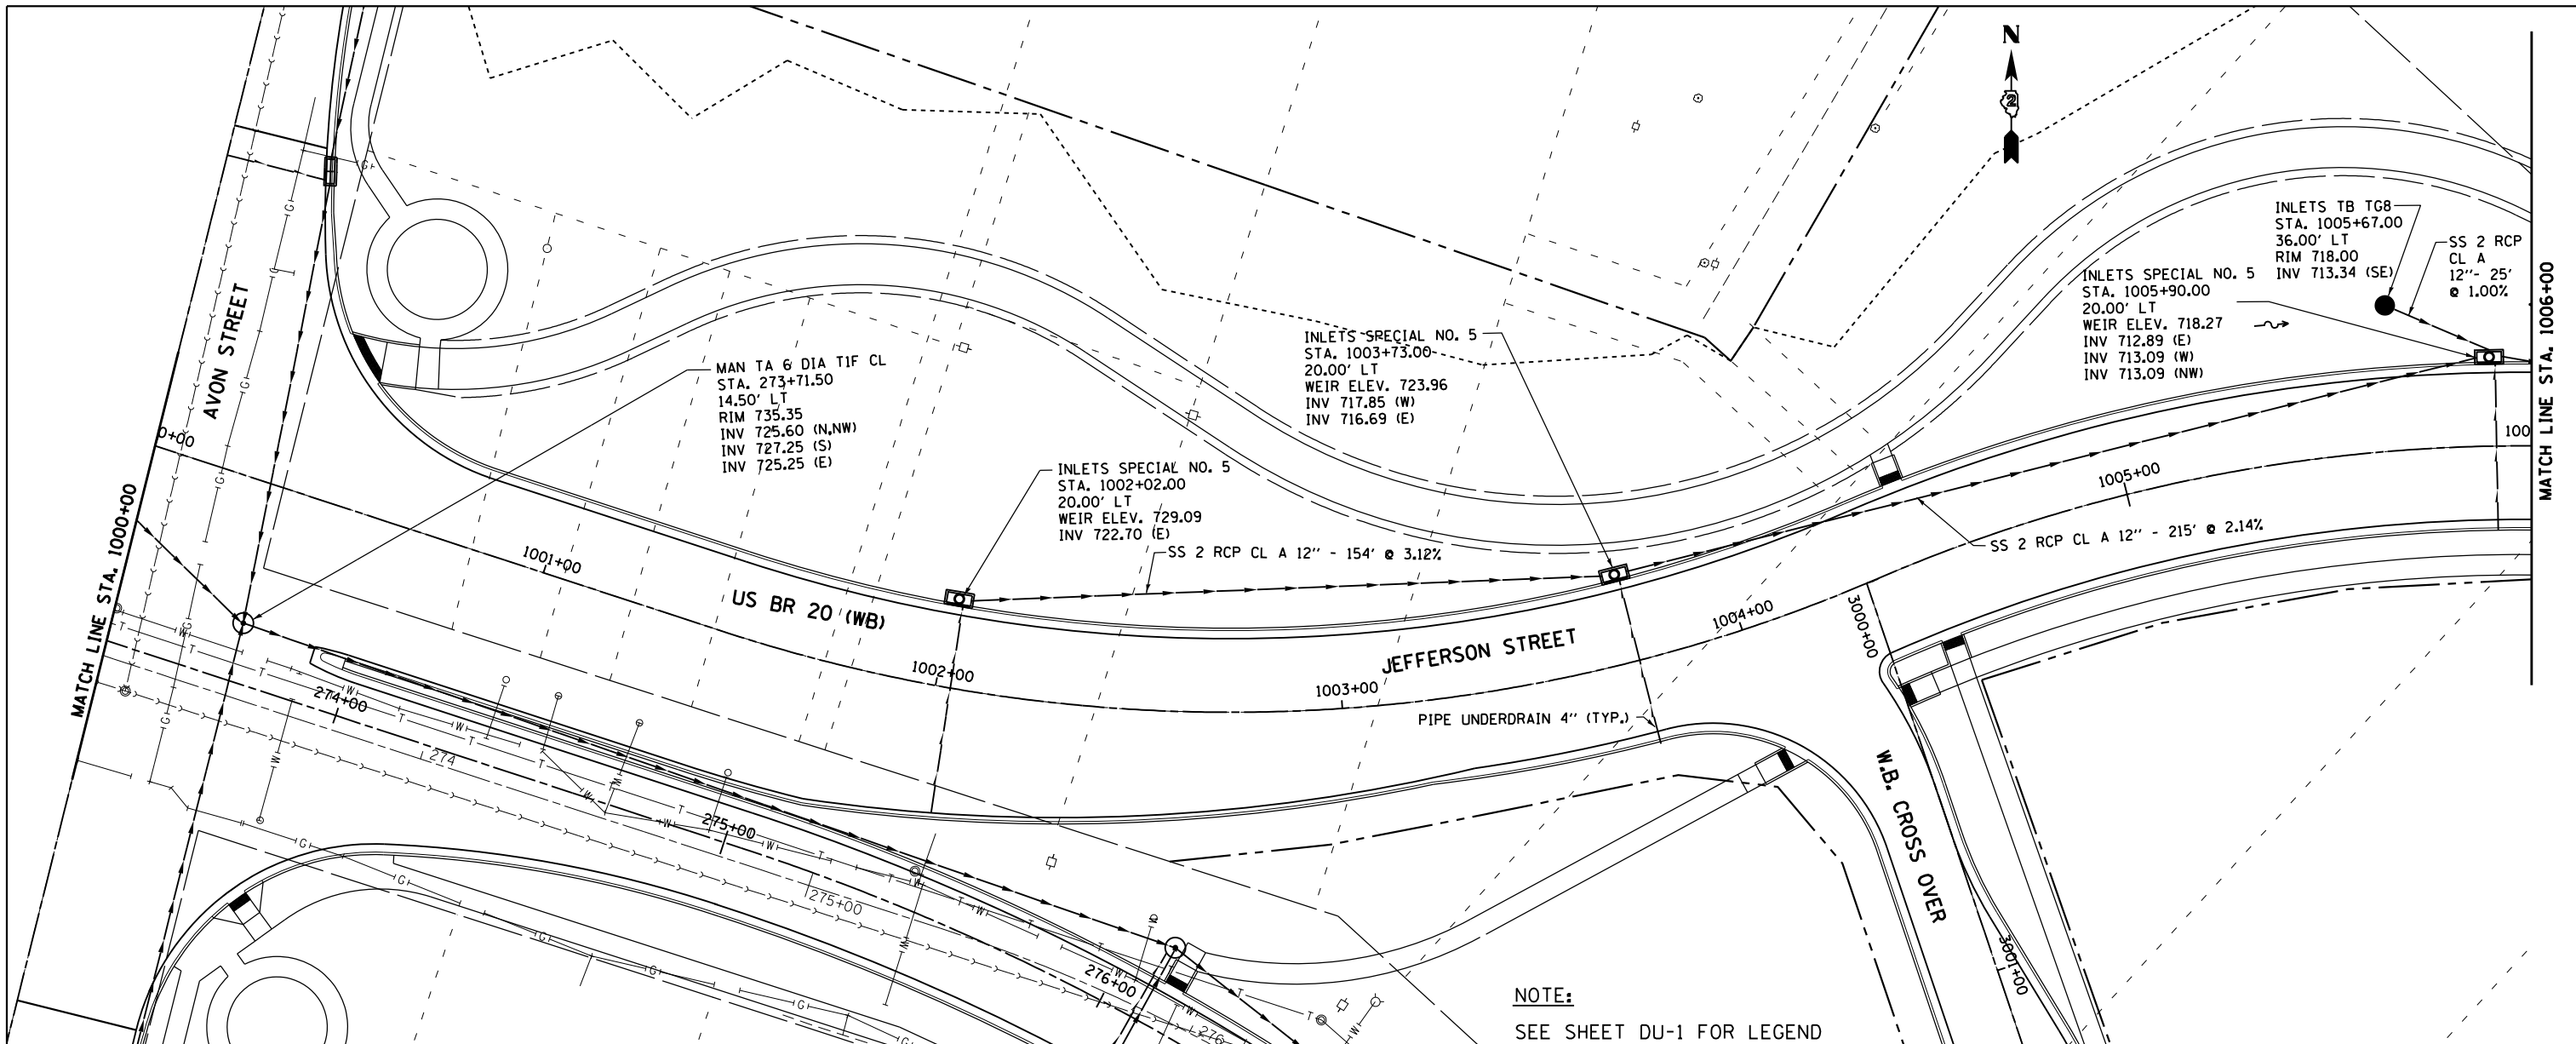

FILE NAME =	USER NAME = dssdd	DESIGNED - EJD	REVISED -
c:\pwork\pwork\dssdd\0317619\0264750	sh-t-drain-163.dgn	DRAWN - EJD	REVISED -
PLOT SCALE = 40.0000' / in.	CHECKED - RCH	REVISOR -	REVISED -
PLOT DATE = Mon Dec 17 15:36:08 2012	DATE - \$SUBDATE\$	REVISOR -	REVISED -

STATE OF ILLINOIS
 DEPARTMENT OF TRANSPORTATION

PROPOSED DRAINAGE PLAN AND PROFILE
 JEFFERSON STREET

SCALE: SHEET NO. 19 OF 21 SHEETS STA. TO STA.

F.A.P. RTE.	SECTION	COUNTY	TOTAL SHEETS	SHEET NO.
303	41R	WINNEBAGO	327	163
FED. ROAD DIST. NO. 2 ILLINOIS FED. AID PROJECT			CONTRACT NO. 64750	