



PLAN	SURVEYED	DATE
	PLOTTED	
	GRADES CHECKED	
	STRUCTURE NOTATIONS CHECKED	
NOTE BOOK NO.	CADD FILE NAME	

PROFILE	SURVEYED	DATE
	PLOTTED	
	GRADES CHECKED	
	STRUCTURE NOTATIONS CHECKED	
NOTE BOOK NO.	CADD FILE NAME	

McDonough Associates Inc.  
Engineers/Architects  
130 East Randolph Street Chicago, Illinois 60601

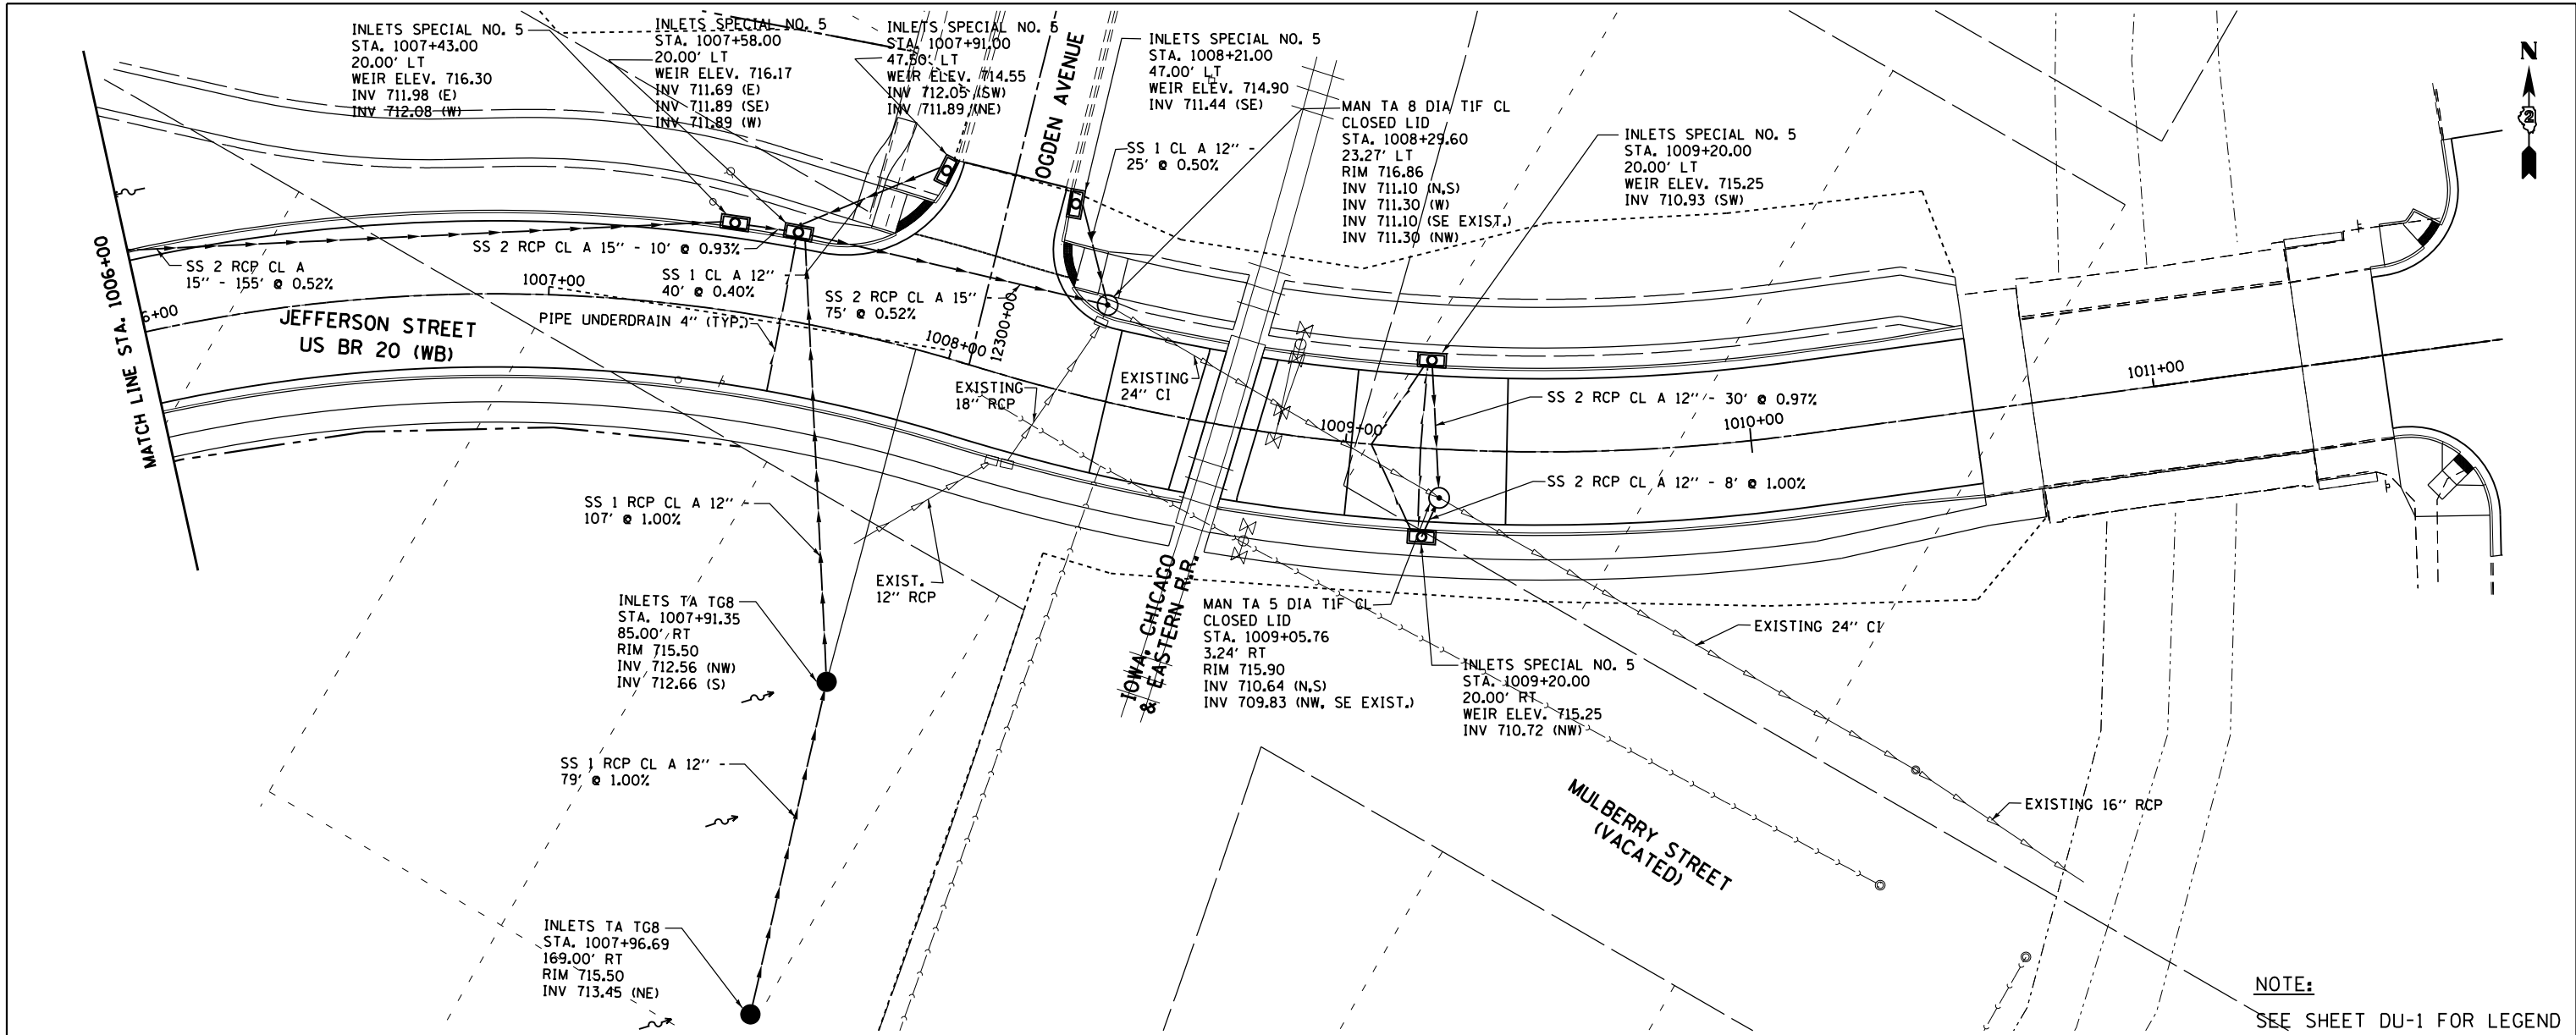

NOTE:  
SEE SHEET DU-1 FOR LEGEND

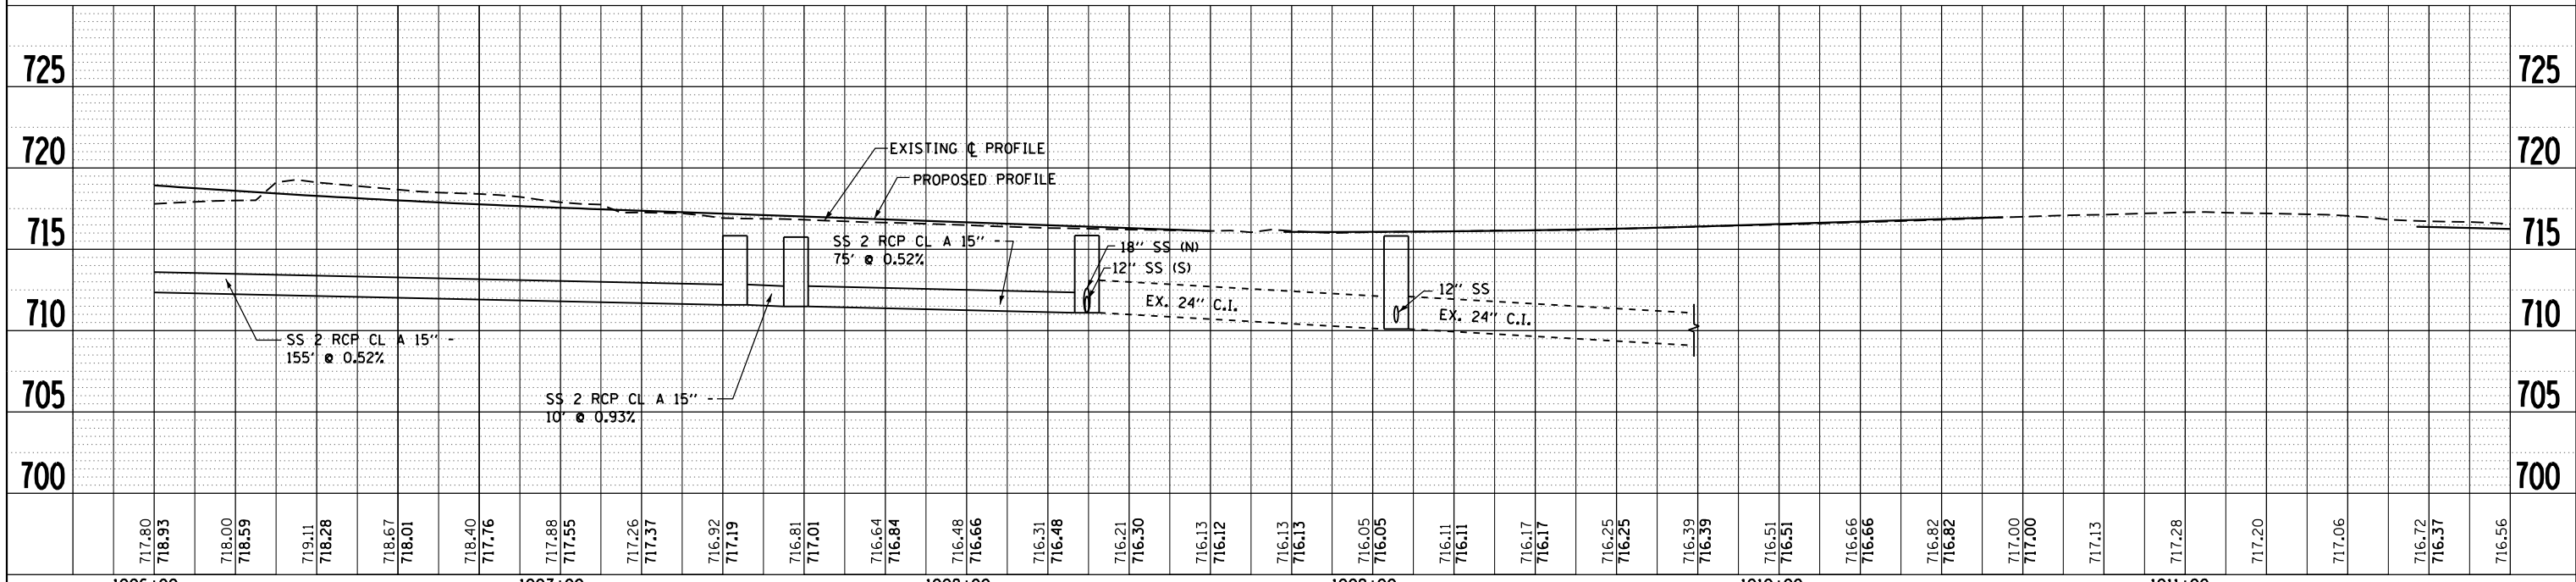

FILE NAME =	USER NAME = dssdd	DESIGNED - EJD	REVISED -	<b>STATE OF ILLINOIS DEPARTMENT OF TRANSPORTATION</b>	<b>PROPOSED DRAINAGE PLAN AND PROFILE JEFFERSON STREET</b>		F.A.P. RTE. 303	SECTION 41R	COUNTY WINNEBAGO	TOTAL SHEETS 327	SHEET NO. 164	
c:\pwwork\pwwork\dssdd\10317619\10264750	shd-drain-164.dgn	DRAWN - EJD	REVISED -		SCALE:	SHEET NO. 20 OF 21 SHEETS	STA.	TO STA.	CONTRACT NO. 64750			
		CHECKED - RCH	REVISED -		FED. ROAD DIST. NO. 2 ILLINOIS FED. AID PROJECT							
		PLOT DATE = Mon Dec 17 15:36:37 2012	DATE - \$SUBDATE\$		REVISED -							