

F.A.P. RTE.	SECTION	COUNTY	TOTAL SHEETS	SHEET NO.
577	2006-004TS	COOK/DUPAGE	19	1
STA.		TO STA.		
FED. ROAD DIST. NO.		ILLINOIS FED. AID PROJECT		

D-91-295-06

INDEX OF SHEETS



SHEET NO.	DESCRIPTION
1.	TITLE SHEET
2.	SUMMARY OF QUANTITIES IL ROUTE 171 (ARCHER AVENUE) FROM IL ROUTE 83 TO BELL ROAD
3, 4, 5 & 6.	STANDARD TRAFFIC SIGNAL DESIGN DETAILS
7.	CONDUIT EXPANSION/DEFLECTION FITTING AND CONDUIT INSTALLATION DETAILS
8.	TRAFFIC SIGNAL MODIFICATION AND REMOVAL PLAN IL ROUTE 171 (ARCHER AVENUE) AT BELL ROAD
9.	CABLE PLAN, PHASE DESIGNATION DIAGRAM, AND SCHEDULE OF QUANTITIES IL ROUTE 171 (ARCHER AVENUE) AT BELL ROAD
10.	TRAFFIC SIGNAL MODIFICATION AND REMOVAL PLAN IL ROUTE 171 (ARCHER AVENUE) AT IL ROUTE 83 (111TH STREET)
11.	CABLE PLAN, SEQUENCE OF OPERATIONS, AND SCHEDULE OF QUANTITIES IL ROUTE 171 (ARCHER AVENUE) AT IL ROUTE 83 (111TH STREET)
12.	TRAFFIC SIGNAL MODIFICATION AND REMOVAL PLAN IL ROUTE 171 (ARCHER AVENUE) AT IL ROUTE 83
13.	CABLE PLAN, PHASE DESIGNATION DIAGRAM, AND SCHEDULE OF QUANTITIES IL ROUTE 171 (ARCHER AVENUE) AT IL ROUTE 83
14.	SEQUENCE OF OPERATIONS IL ROUTE 171 (ARCHER AVENUE) AT IL ROUTE 83
15, 16, 17, & 18.	INTERCONNECT PLAN IL ROUTE 171 (ARCHER AVENUE) FROM IL ROUTE 83 TO BELL ROAD
19.	INTERCONNECT SCHEMATIC IL ROUTE 171 (ARCHER AVENUE) FROM IL ROUTE 83 TO BELL ROAD

STATE OF ILLINOIS
DEPARTMENT OF TRANSPORTATION
DIVISION OF HIGHWAYS

PLANS FOR PROPOSED
FEDERAL AID HIGHWAY

SCALES { PLAN 1" = 20' AND 1" = 50'
PROFILE HORIZ. N.A.
PROFILE VERT. N.A.
CROSS SECTION N.A.

DISTRICT 1
CONGESTION MITIGATION AIR QUALITY
FIBER OPTIC COMMUNICATIONS NETWORK
ILLINOIS ROUTE 171 (ARCHER AVENUE)
FROM ILLINOIS ROUTE 83 TO BELL ROAD
F.A.P. ROUTE 577
SECTION 2006-004TS
C-91-295-06
PROJECT: CMF-0577(217)
COOK / ~~DUPAGE~~ COUNTY

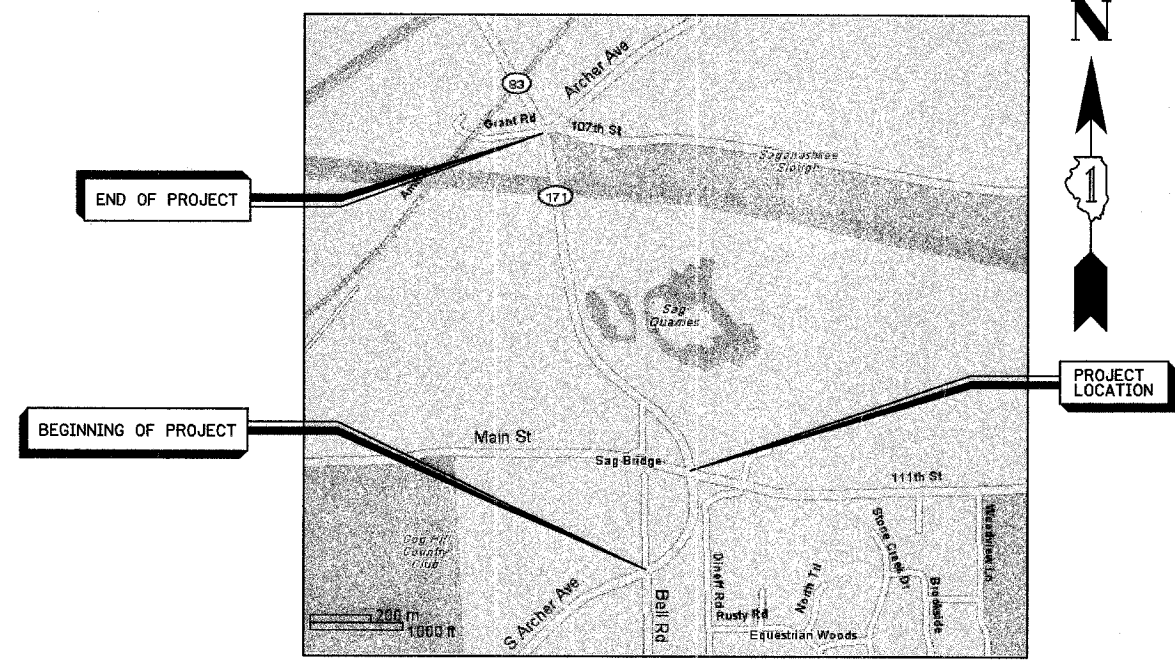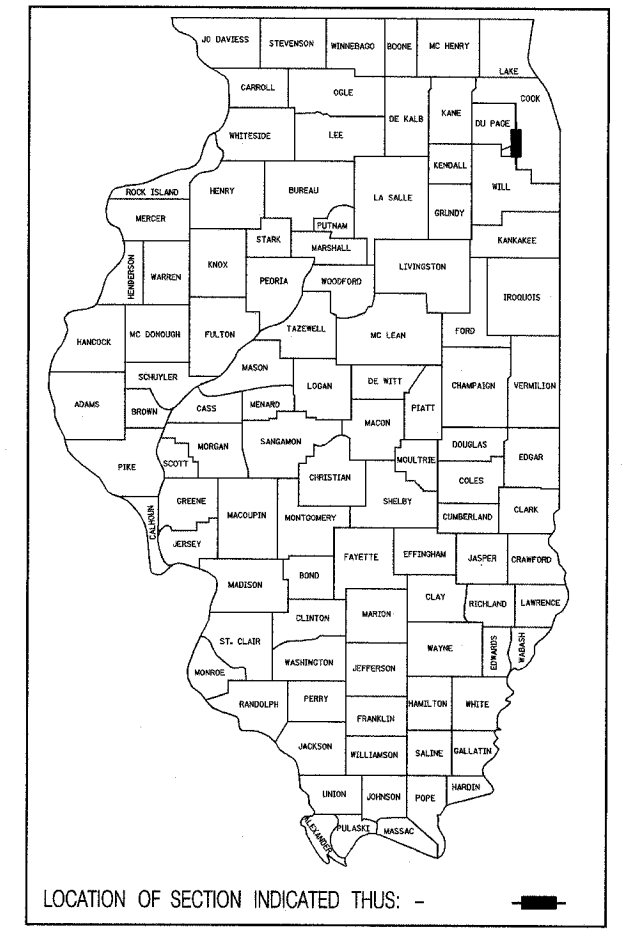

LEMONT TOWNSHIP


STANDARD DRAWINGS

701006-02	701011-01	701101-01	701301-02	702001-06
424001-04	720001	813001-01	814001-01	814006
857001	877001-02	877006-02	877011-02	878001-05
880001	880006	886001	805001	
701201-02	701316-03	701321-08	701406-04	701501-03
701502-01	701606-04	701601-04	701701-04	701801-03

NOTE: STANDARD DRAWINGS REQUIRED (CIRCLED).


CONTRACT NO. 60B19

PREPARED BY: *Stephen M. Schaefer* 12/18/2006
TRAFFIC ENGINEER DATE

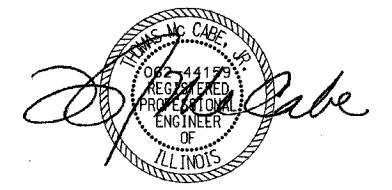

STATE OF ILLINOIS
DEPARTMENT OF TRANSPORTATION
DIVISION OF HIGHWAYS

SUBMITTED 20
Debra M. O'Keefe
DEPUTY DIRECTOR OF HIGHWAYS, REGION ENGINEER
February 2, 2007
Eric E. Hansen
INTERIM ENGINEER OF DESIGN AND ENVIRONMENT
February 2, 2007
Milton R. Sosa
DIRECTOR OF HIGHWAYS, CHIEF ENGINEER

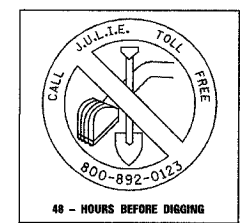

PRINTED BY AUTHORITY OF
THE STATE OF ILLINOIS

BUREAU OF TRAFFIC: STEVE TRAMA / DARYLE DREW 847-705-4420