


# STAGE 2


| F.A.S. RTE.           | SECTION                      | COUNTY    | TOTAL SHEETS     | SHEET NO. |
|-----------------------|------------------------------|-----------|------------------|-----------|
| 55                    | 1102BR-1,102BR-2, 102BR-3, D | WINNEBAGO | 52               | 11        |
| STA.                  |                              | TO STA.   |                  |           |
| FED. ROAD DIST. NO. 7 |                              | ILLINOIS  | FED. AID PROJECT |           |
| CONTRACT NO. 64C93    |                              |           |                  |           |

| PLAN          | SURVEYED | DATE    |
|---------------|----------|---------|
|               |          |         |
| NOTE BOOK NO. | PLotted  | Checked |
|               |          |         |
| ADD FILE NAME |          |         |

| PROFILE                 | SURVEYED | DATE    |
|-------------------------|----------|---------|
|                         |          |         |
| NOTE BOOK NO.           | Plotted  | Checked |
|                         |          |         |
| STRUCTURE NOTATION DRFD |          |         |

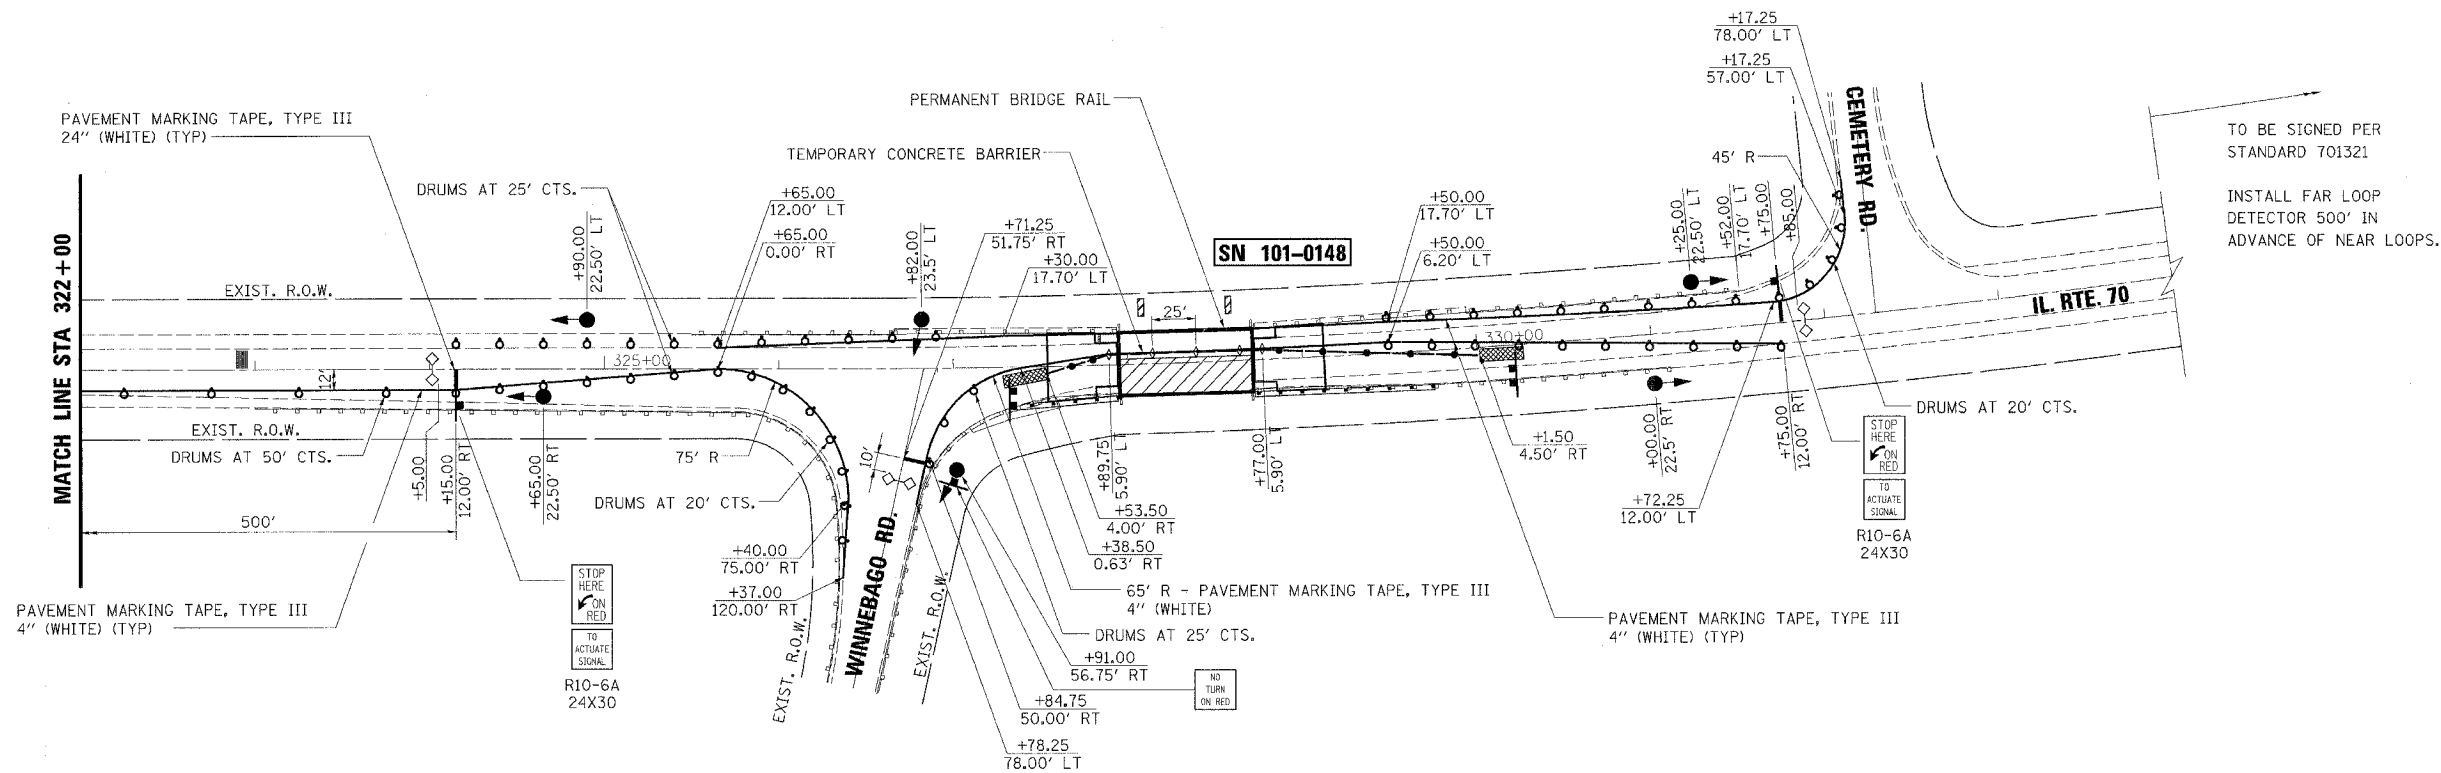

| SEQUENCE OF OPERATIONS   |   |   |   |   |   |   |   |   |   |
|--|---|---|---|---|---|---|---|---|---|
| PHASE  | A |   | B |   |   | C |   |   |   |
| INTERVAL   | 1 | 2 | 3 | 4 | 5 | 6 | 7 | 8 | 9 |
| EASTBOUND IL RTE 70 LEFT SIGNAL AND RIGHT SIGNAL AT STA. 1325+57 | G | Y | R | R | R | R | R | R | R |
| WESTBOUND IL RTE 70 LEFT SIGNAL AND RIGHT SIGNAL AT STA. 1331+10 | R | R | R | G | Y | R | R | R | R |
| NORTHBOUND WINNEBAGO RD FAR LEFT SIGNAL AND NEAR RIGHT SIGNAL    | R | R | R | R | R | R | R | G | Y |

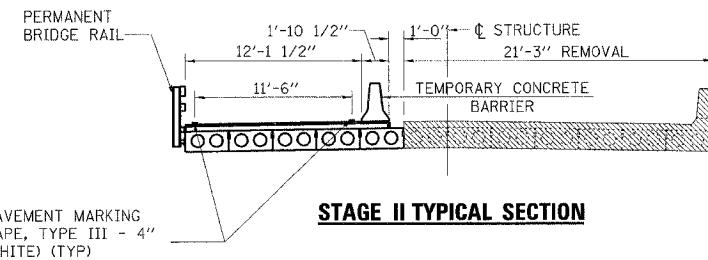

### LEGEND

- |                                |  |
|--------------------------------|--|
| WORK ZONE                      | DOUBLE VERTICAL PANEL                            |
| SIGN                           | TYPE C BIDIRECTIONAL REFLECTOR                   |
| DRUM WITH STEADY BURNING LIGHT | TEMPORARY CONCRETE BARRIER                       |
| TRAFFIC SIGNAL                 | IMPACT ATTENUATOR, TEMPORARY (NON-REDIRECTIVE)   |
| INDUCTION LOOP DETECTOR        | TEST LEVEL 3                                     |
| TYPE III BARRICADE             | STEADY BURNING LIGHTS AND DOUBLE VERTICAL PANELS |
| DOUBLE VERTICAL PANEL          | STEEL RAILING (TEMPORARY)                        |
|                                | TEMPORARY RUMBLE STRIP                           |

| REVISIONS |      | ILLINOIS DEPARTMENT OF TRANSPORTATION                                       |  |
|-----------|------|---|--|
| NAME      | DATE | F.A.S. ROUTE 55 (INTERSTATE 70)   |  |
|           |      | <b>IL ROUTE 70</b><br><b>TRAFFIC CONTROL</b><br><b>CONSTRUCTION STAGING</b> |  |
|           |      |   |  |
|           |      |   |  |
|           |      |   |  |
|           |      |   |  |
|           |      |   |  |

PLOT SCALE: 1/80  
 PLOT DATE: 12/14/2006  
 PLOT TIME: 11:53:58 PM  
 PLOT TECH: JMC  
 MODEL NAME: Det.Cout

SCALE: VERT. NONE  
 HORIZ. 1"=50'  
 DATE: DECEMBER 15, 2006  
 DRAWN BY: JMC  
 CHECKED BY: DWB