


F.A.P. RTE.	SECTION	COUNTY	TOTAL SHEETS	SHEET NO.
693	129 B-2	MCLEAN	34	9

STA. 63+00 TO STA. 69+00
 FED. ROAD DIST. NO. ILLINOIS FED. AID PROJECT

CONTRACT NO. 70519

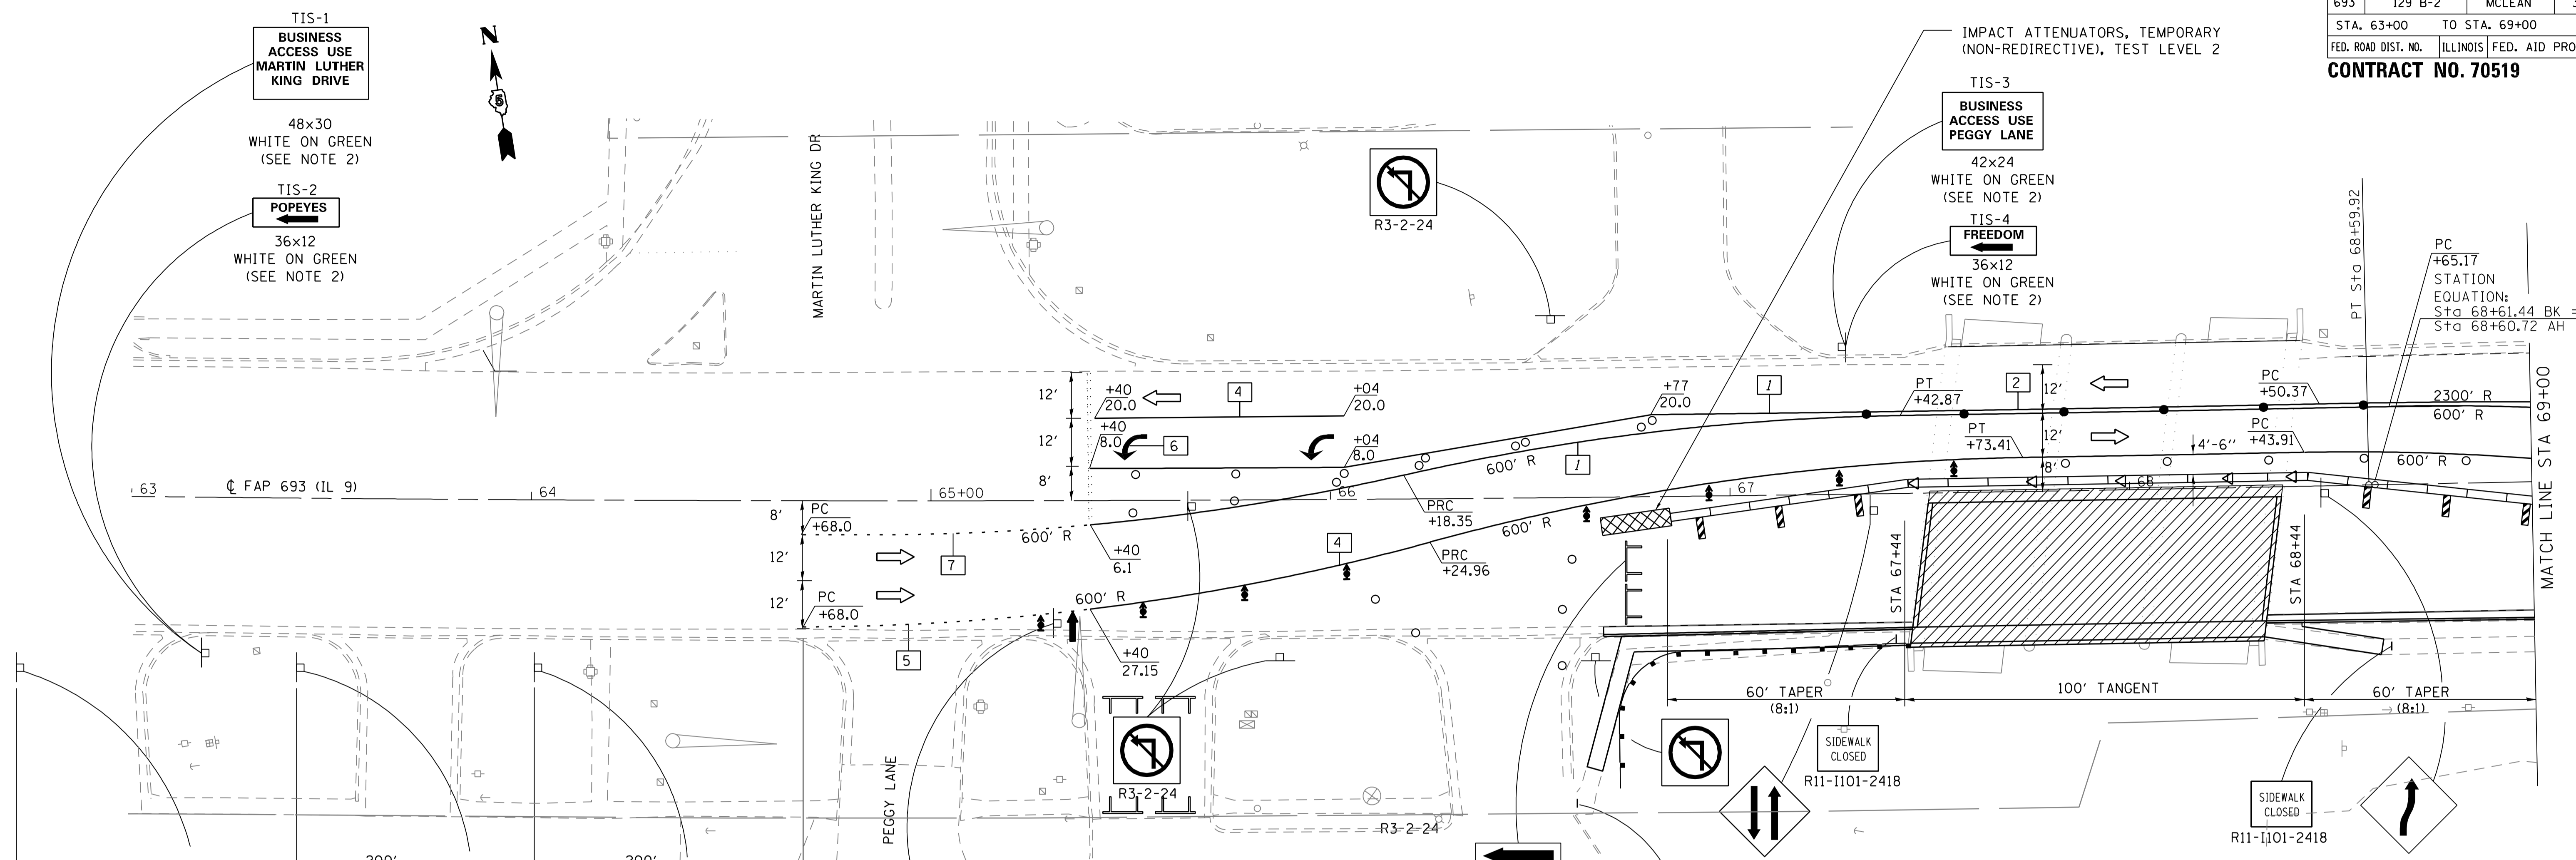

TEMPORARY PAVEMENT MARKING LAYOUT

WESTBOUND LANES			EASTBOUND LANES		
STATION	OUTSIDE EDGE OF PAVEMENT	MEDIAN EDGE OF PAVEMENT	STATION	MEDIAN EDGE OF PAVEMENT	OUTSIDE EDGE OF PAVEMENT
65+40	EXISTING	-8.00	PC +68.0	8.00	32.00
66+04	EXISTING	-8.00	65+00	7.83	31.13
66+25	EXISTING	-11.54	65+25	6.71	29.25
66+50	EXISTING	-15.61	65+50	4.59	26.34
66+75	EXISTING	-19.65	65+75	1.44	22.40
66+77	EXISTING	-20.00	66+00	-2.74	17.40
			PRC +18.35	-6.49	-
PC +50.37	EXISTING	-20.00	PRC +24.96	-	11.33
68+75	EXISTING	-19.88	66+25	-7.91	11.32
69+00	EXISTING	-19.52	66+50	-12.52	5.29
			66+75	-16.02	0.41
			67+00	-18.42	-3.33
			67+25	-19.72	-5.98
			PT +42.87	-20.00	-
			67+50	-20.00	-7.53
			PT +73.41	-	-8.00
			PC +43.91	-	-8.00
			68+50	-20.00	-7.97
			PC +65.17	-20.00	-
			68+75	-19.96	-7.17
			69+00	-19.10	-5.36

- SEQUENCE OF OPERATIONS**
- STAGE 1:
- 1 INSTALL TEMPORARY CONCRETE BARRIER AND TRAFFIC CONTROL DEVICES
 - 2 REMOVE REFLECTORS FROM RAISED REFLECTIVE PAVEMENT MARKERS
 - 3 REMOVE EXISTING PAVEMENT MARKINGS AND INSTALL TEMPORARY PAVEMENT MARKINGS
 - 4 REMOVE AND SALVAGE TEMPORARY CURB
 - 5 REMOVE FIBER OPTIC CABLE AND CONDUIT ATTACHED TO STRUCTURE
 - 6 REMOVE SIDEWALK AND COMBINATION CURB AND GUTTER
 - 7 RECONSTRUCT STAGE 1 PORTION OF SUPERSTRUCTURE WITH EMBEDDED CONDUIT
 - 8 CONSTRUCT SIDEWALK AND COMBINATION CURB AND GUTTER
 - 9 INSTALL GUARDRAILS AND TERMINALS
 - 10 PLACE HOT-MIX ASPHALT BINDER COURSE ON ABUTMENT FLUSH WITH TOP OF CONCRETE WEARING SURFACE AND EXISTING HOT-MIX ASPHALT
 - 11 REINSTALL FIBER OPTIC CABLE
 - 12 BRIDGE DECK GROOVING AND PROTECTIVE COAT
- NOTES:**
- 1 ALL SIGNING, UNLESS OTHERWISE NOTED, SHALL BE INCLUDED IN THE COST FOR TRAFFIC CONTROL AND PROTECTION (SPECIAL)
 - 2 SIGNING FOR BUSINESS ACCESS SHALL BE PAID FOR AS TEMPORARY INFORMATION SIGNING. LETTERS SHALL BE TYPE B AND 4 INCHES IN HEIGHT.
 - 3 ALL EXISTING SIGNING, EXCEPT LOAD POSTING SIGNS THAT IS NOT APPLICABLE WITH THE STAGE 1 TRAFFIC CONTROL SHALL BE COMPLETELY COVERED BY THE CONTRACTOR. COSTS FOR THIS WORK SHALL BE INCLUDED IN THE COST FOR TRAFFIC CONTROL AND PROTECTION (SPECIAL)
 - 4 VERTICAL BARRICADES SHALL BE EQUIPPED WITH MONO-DIRECTIONAL OR BIDIRECTIONAL STEADY BURN LIGHTS AND SHALL BE PLACED AT 25 FOOT INTERVALS ALONG THE WORK ZONE. BARRICADES SHALL BE OMITTED AS DIRECTED BY THE ENGINEER TO ALLOW ACCESS TO COMMERCIAL ENTRANCES.

TRAFFIC CONTROL LEGEND	TEMPORARY PAVEMENT MARKING LEGEND
TYPE III BARRICADE WITH TWO FLASHING LIGHTS	4" SOLID (YELLOW)
POST MOUNTED SIGN	4" DOUBLE YELLOW (NARROW)
VERTICAL BARRICADES WITH STEADY BURN MONODIRECTIONAL OR BIDIRECTIONAL LIGHT AT 25 FOOT CENTERS	4" SKIP DASH (WHITE)
DIRECTION INDICATOR BARRICADES	4" SOLID (WHITE)
FLASHING LIGHT	4" LANE EXTENSION (WHITE)
WORK ZONE	4" LANE EXTENSION (YELLOW)
VERTICAL PANEL WITH STEADY BURNING LIGHT AT 20 FOOT CENTERS ON TAPER	
CRYSTAL MONODIRECTIONAL REFLECTORS AT 20 FOOT CENTERS	
TEMPORARY CONCRETE BARRIER	
FLEXIBLE DELINEATORS AT 25 FOOT CENTERS	
TYPE B ARROW BOARD	

SHEET 1 OF 2

**TRAFFIC CONTROL AND PROTECTION
STAGE 1**

FAP ROUTE 693 (IL 9)
SECTION 129 B-2
MCLEAN COUNTY

JOB #: 2114.5
FILE: 2114.5STAGE1REV
DATE: 12/07/06

CUMMINS ENGINEERING CORPORATION