 




F.A.U. SECTION	COUNTY	TOTAL SHEETS
1389 99-00062-00-PV	DUPAGE	199 90
CONTRACT NO. 83873		
FED. ROAD DIST. NO.	ILLINOIS	FED. AID PROJECT

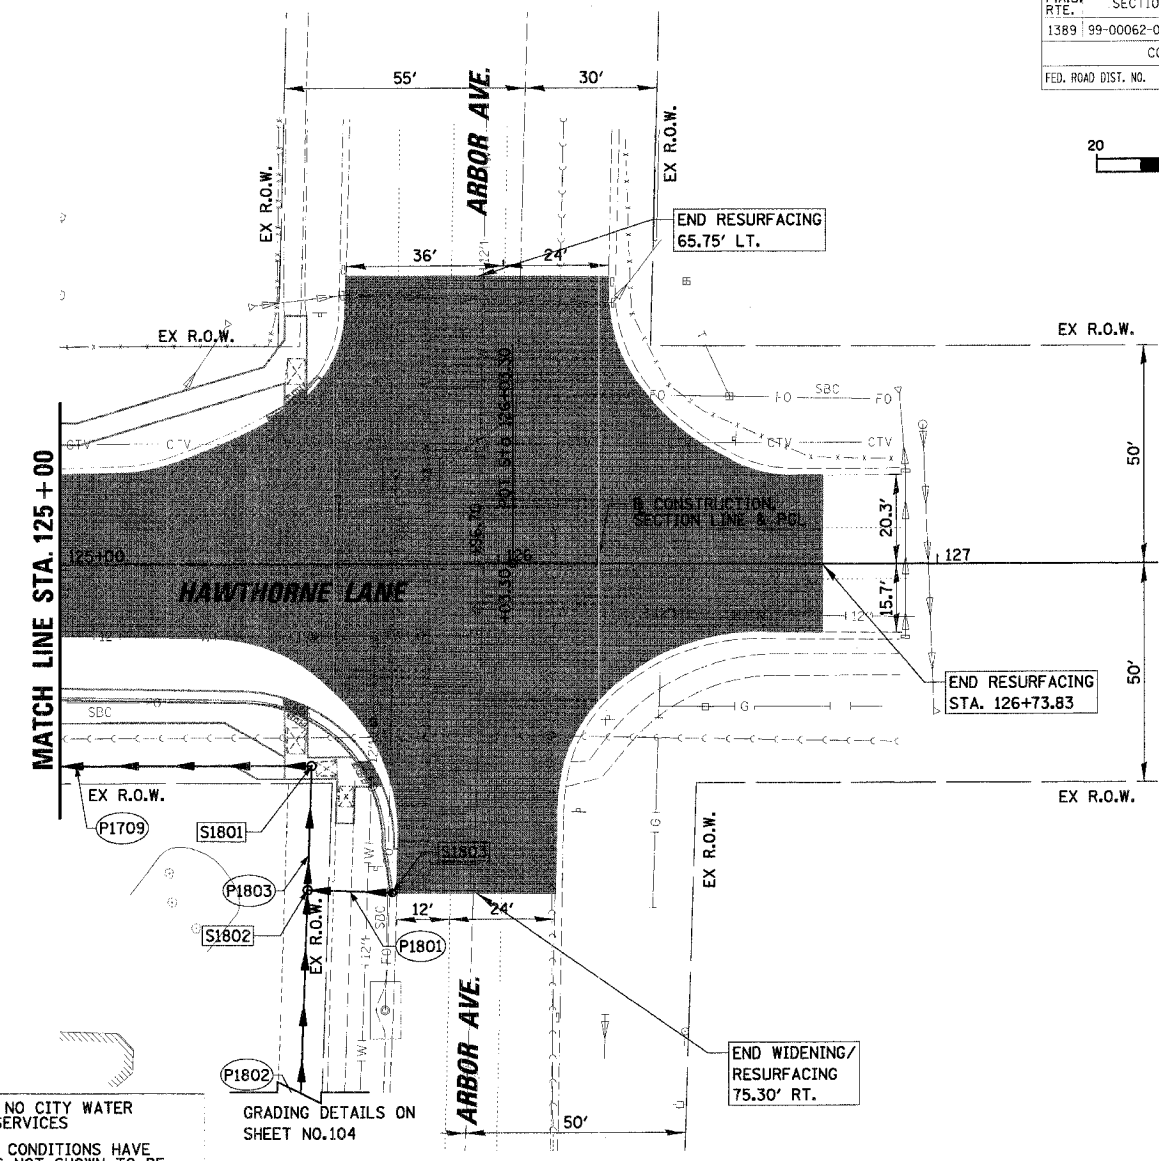

DATE	BY
DATE	BY
DATE	BY


DATE	BY
DATE	BY
DATE	BY

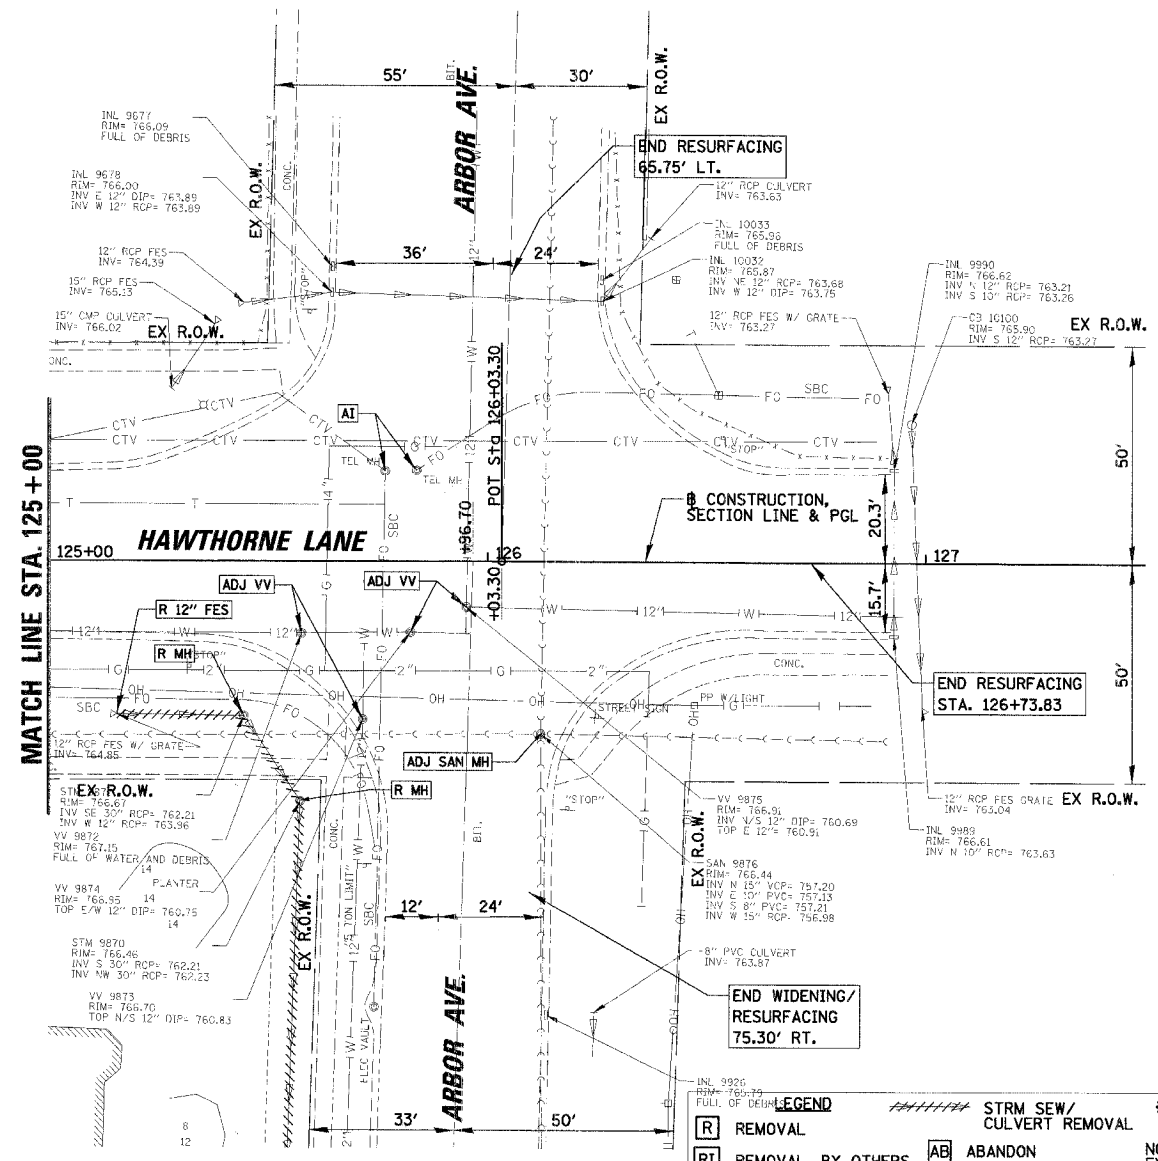

LEGEND

R REMOVAL	AB ABANDON	* PROPERTY HAS NO CITY WATER OR SANITARY SERVICES
RI REMOVAL, BY OTHERS	ADJ ADJUST	NOTE: 1. PROPOSED CONDITIONS HAVE EXISTING UTILITIES NOT SHOWN TO BE RELOCATED. CONTRACTOR TO VERIFY THESE FACILITIES AS WELL AS RELOCATED UTILITY FACILITIES (NOT SHOWN).
REC RECONSTRUCT	AI ADJUST, BY OTHERS	2. FOR DETAILS SEE SHEETS 100 TO 101.
REL RELOCATE		

NOTE: SEE SHEET 104 FOR ADDITIONAL REMOVAL ITEMS.

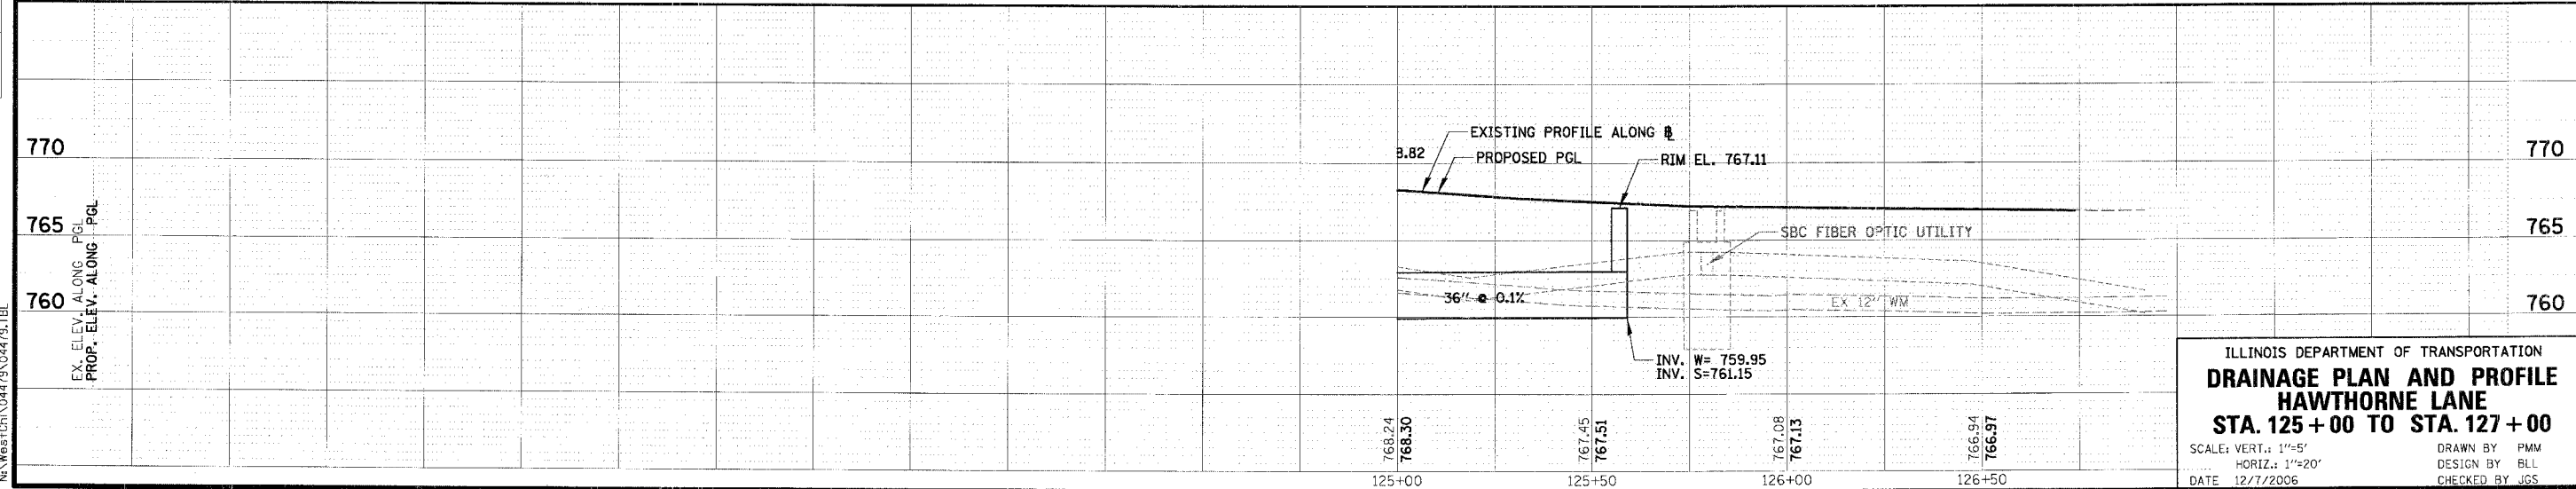

ILLINOIS DEPARTMENT OF TRANSPORTATION
DRAINAGE PLAN AND PROFILE
STA. 125+00 TO STA. 127+00
 SCALE: VERT.: 1"=5'
 HORIZ.: 1"=20'
 DATE: 12/7/2006
 DRAWN BY: PMM
 DESIGN BY: BLL
 CHECKED BY: JGS

N:\West\Ch1\04479\04479.dwg