

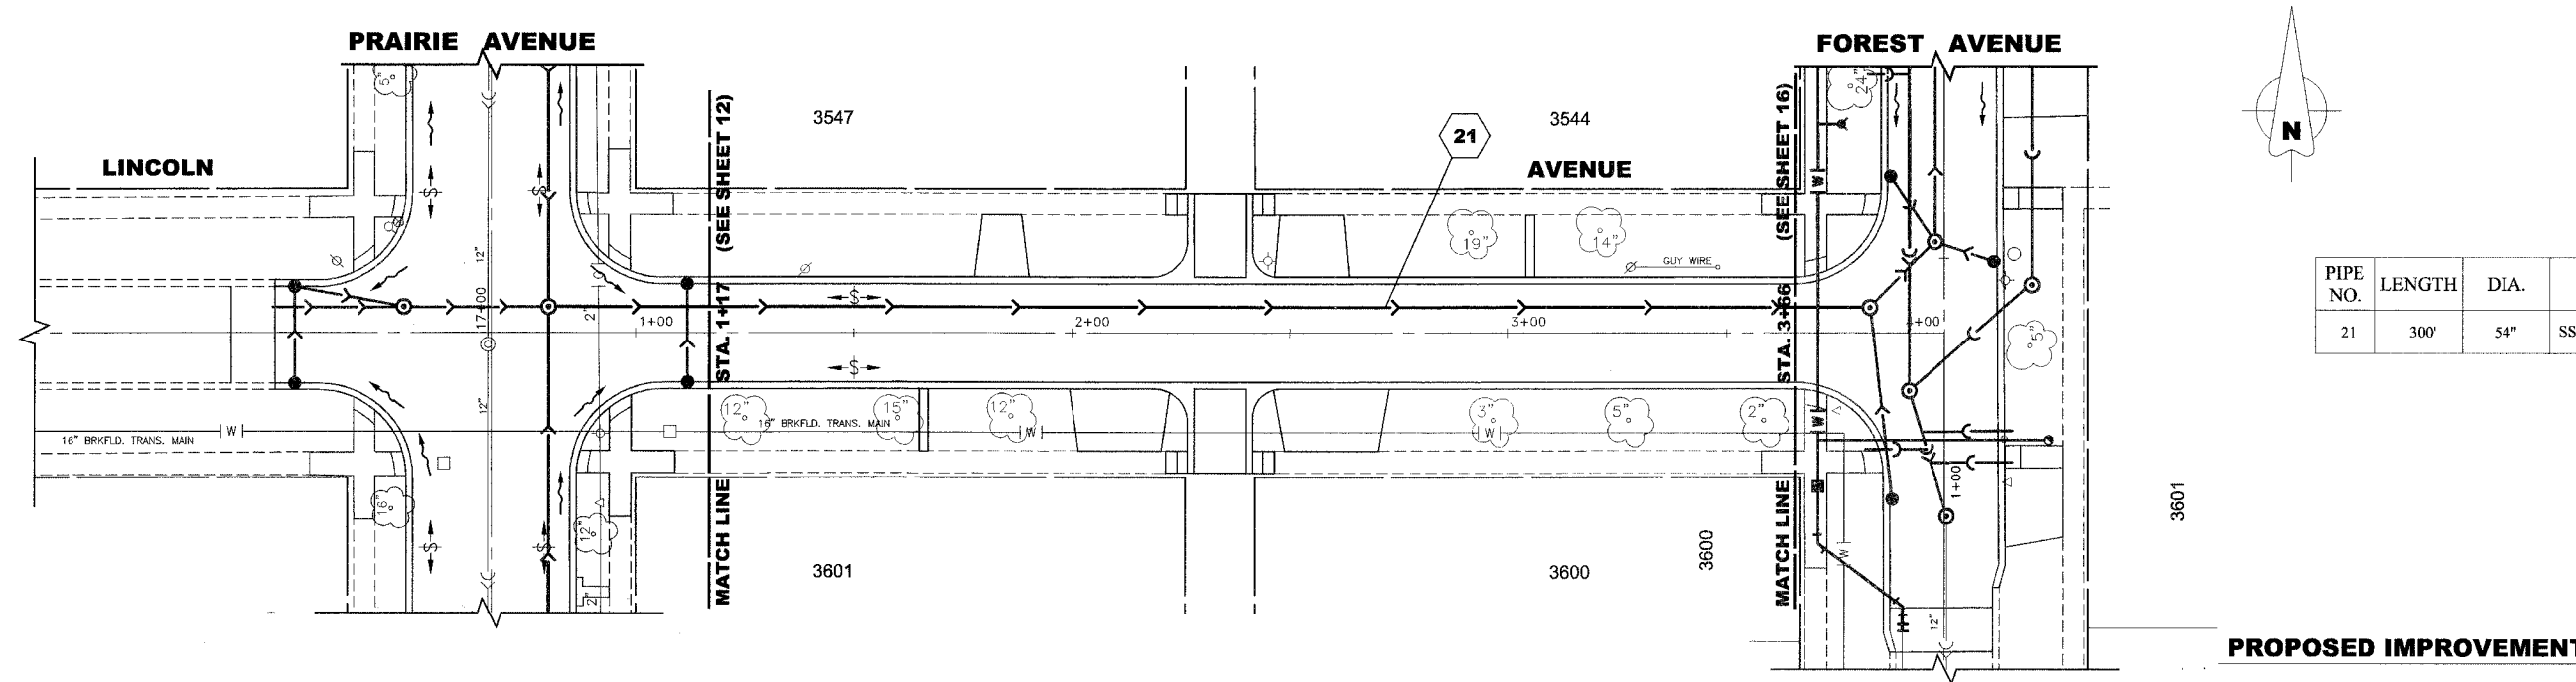


| | | | | |
|--------------------|---------|----------------|--------------|-----------|
| ROUTE NO. | SECTION | COUNTY | TOTAL SHEETS | SHEET NO. |
| FAU 2732 | ** | COOK | 47 | 24 |
| ILLINOIS PROJECT | | M-8003(712) | | |
| VILLAGE SECTION | | 00-00115-01-WR | | |
| CONTRACT NO. 83881 | | | | |

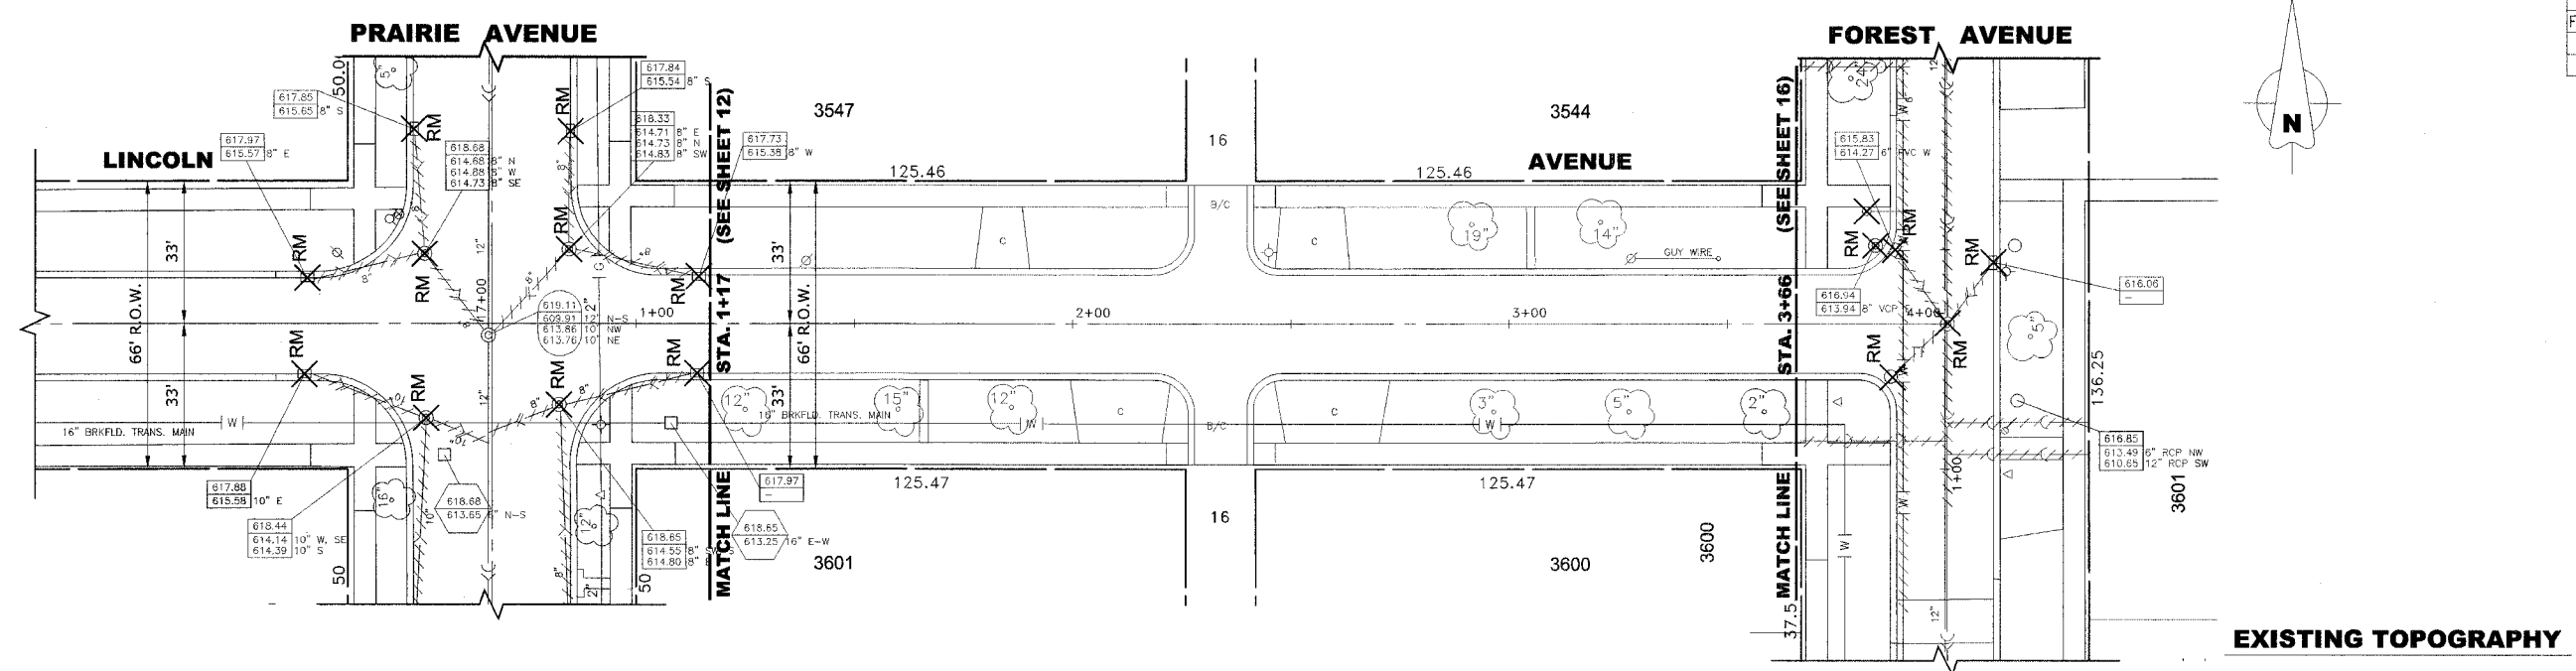

| PIPE NO. | LENGTH | DIA. | TYPE | SLOPE | C.Y.T.B. |
|----------|--------|------|------------------------|-------|----------|
| 21 | 300' | 54" | SS, TY-2, RCCP, CL-III | 0.06% | 443.8 |

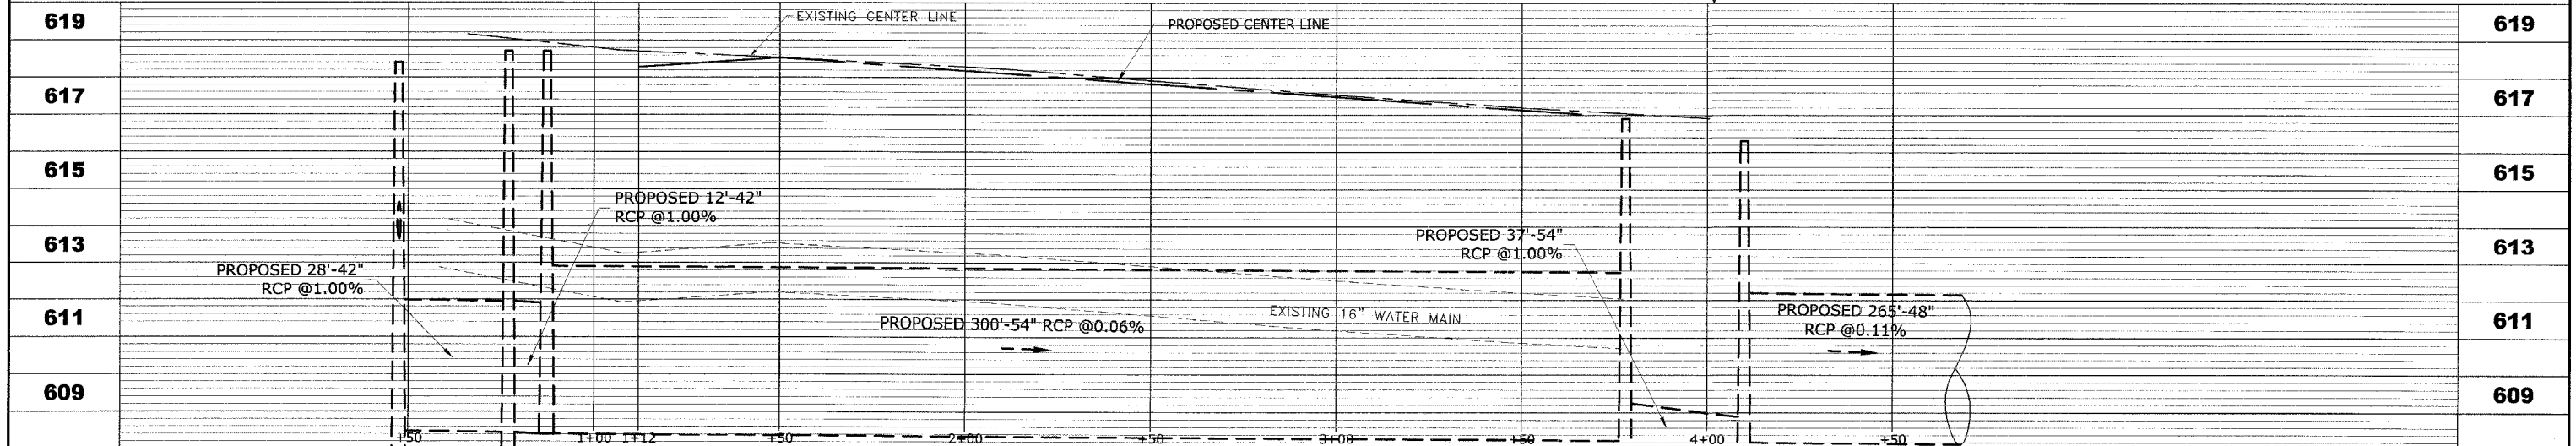

HANCOCK ENGINEERING
 Civil Engineers
 Municipal Consultants
 Established 1911

9933 Roosevelt Road
 Westchester, Illinois 60154-2780
 Phone: 708/865-0300
 Fax: 708/865-1212

**PRAIRIE AVENUE IMPROVEMENTS
 PHASE II
 VILLAGE OF BROOKFIELD, ILLINOIS**

**EXISTING AND PROPOSED
 DRAINAGE AND UTILITIES
 PLAN AND PROFILE**

SCALE: H: 1"=20', V: 1"=2'
 DRAWN BY: MK/LEV
 BOOK NO.: #1475, #1504
 DATE: 10-6-06
 E.H.E. NO.: 125-04-26301

REVISION:

SHEET **24** OF **47**

Drawing File: W:\Projects\12504263 - Prairie Ave 2nd Phase\Prarie\Prarie_Site_Roads.dwg Oct 05, 2006 3:38pm