


CONTRACT NO. 83883				
F.A.U. RTE.	SECTION	COUNTY	TOTAL SHEETS	SHEET NO.
1700	05-00045-02-PV	COOK/DUPAGE	103	57
STREET LIGHTING PLAN				
FED. ROAD DIST. NO. 7 ILLINOIS FED. AID PROJECT M-8003644				

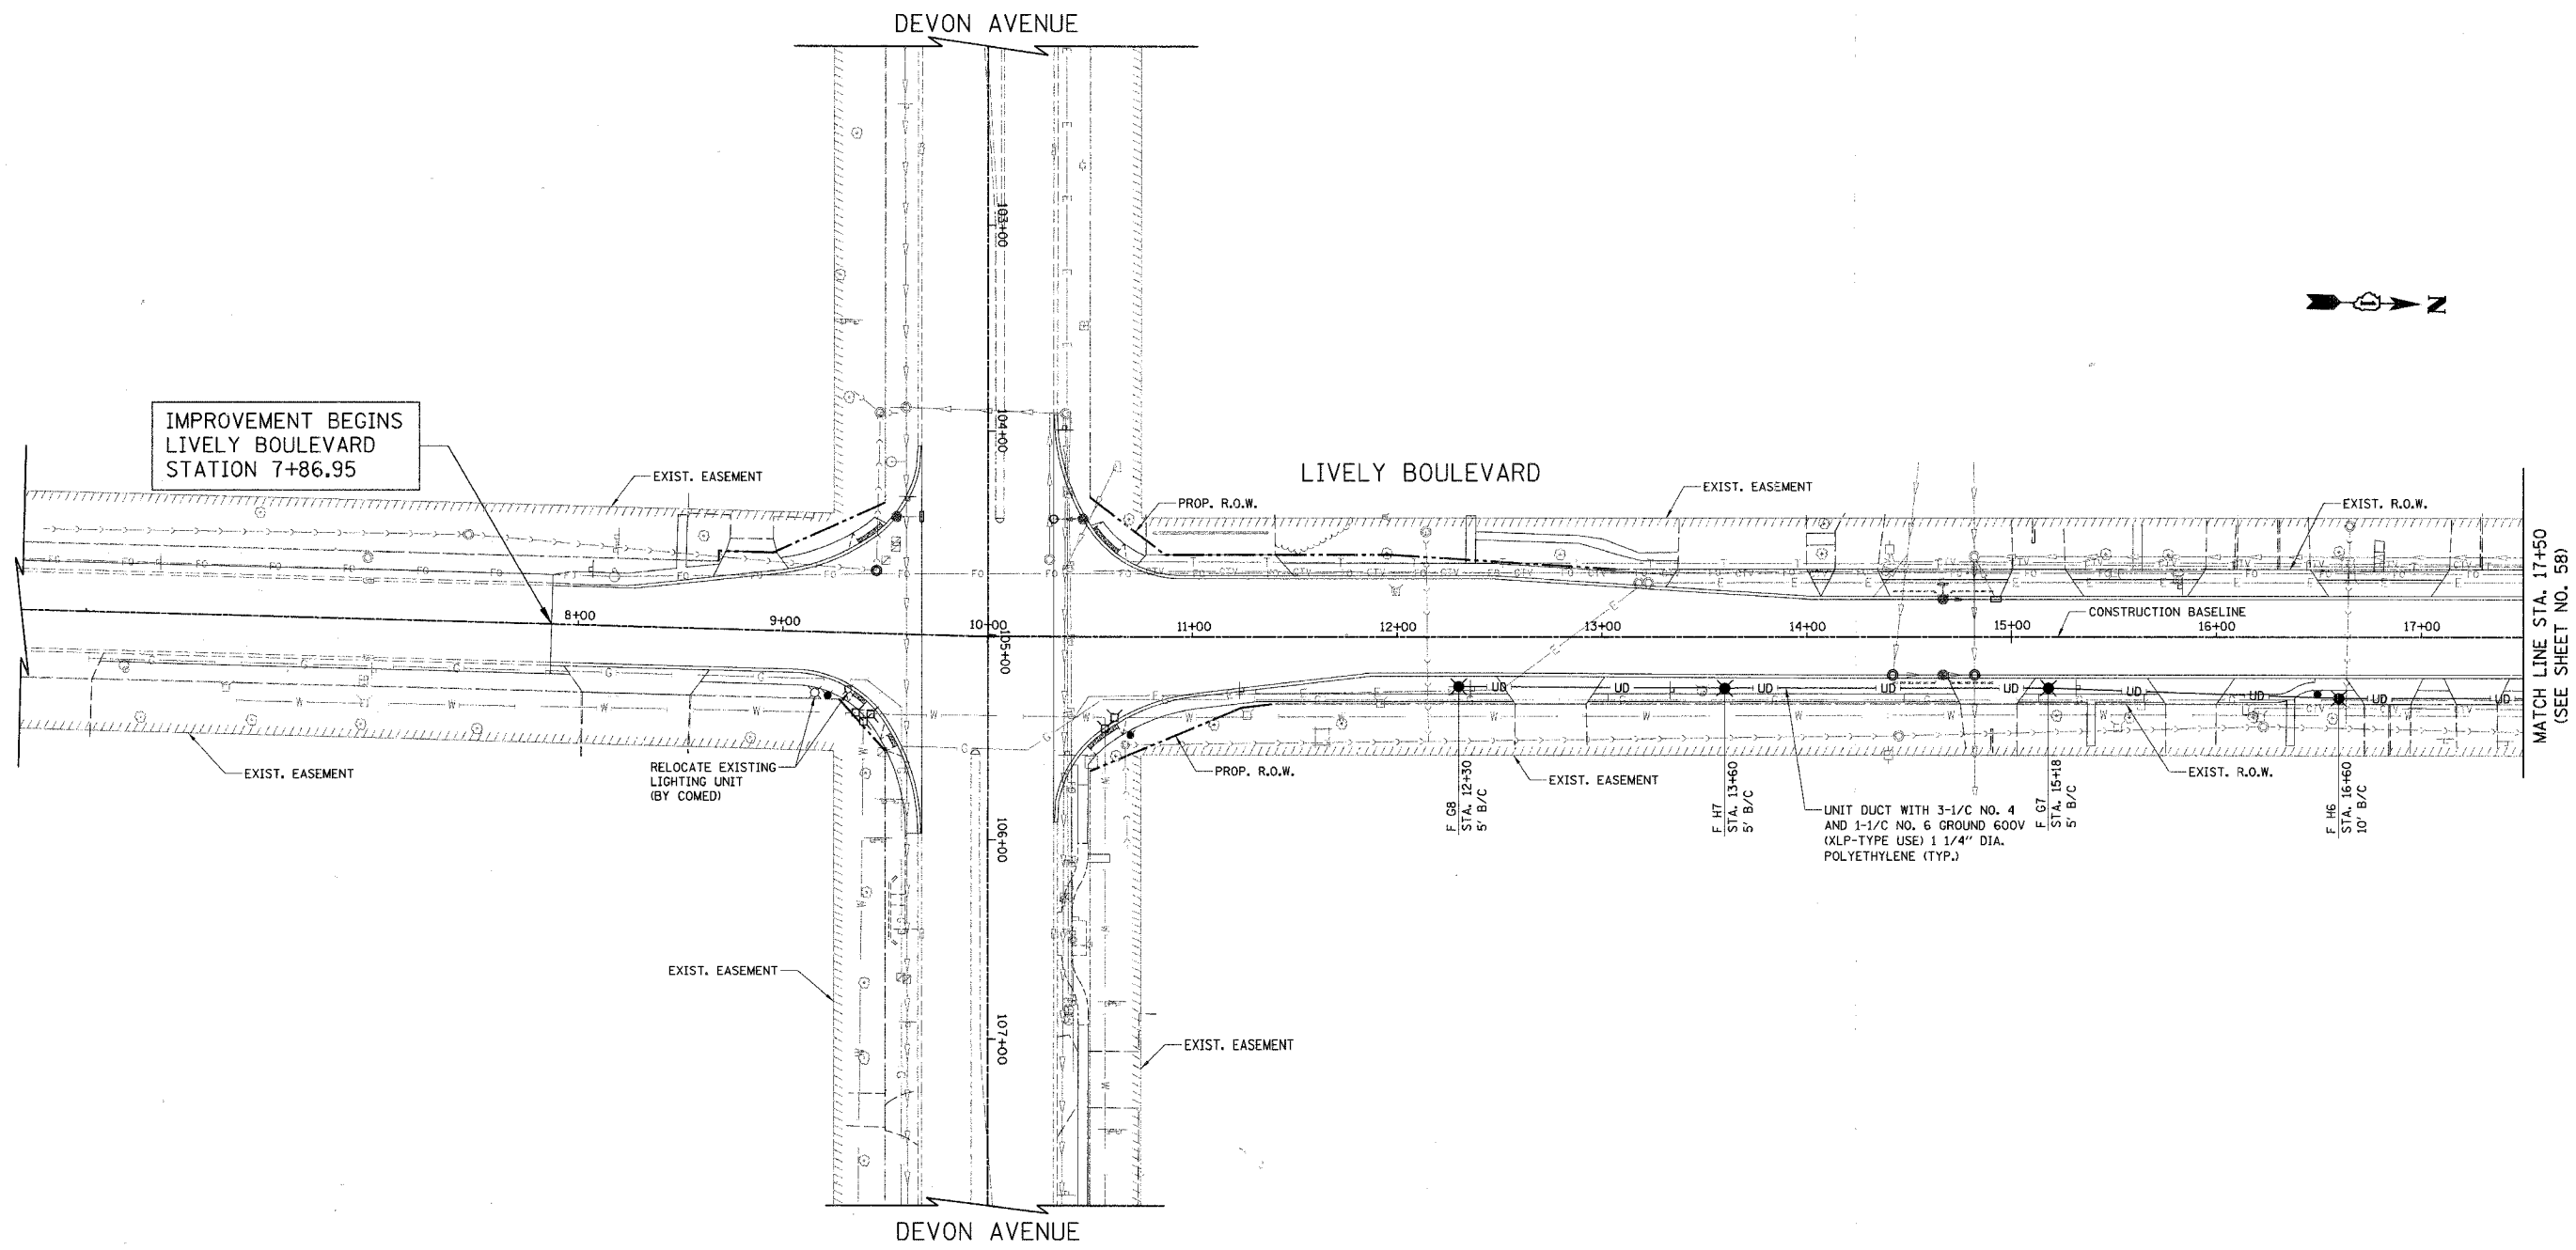

ILLINOIS DEPARTMENT OF TRANSPORTATION

STREET LIGHTING PLAN

LIVELY BOULEVARD
STA. 7+87 TO STA. 17+50

SCALE IN FEET

DATE: 10/18/06
DESIGNED BY: SJC
CHECKED BY: JRV