


F.A.U. RTE.	SECTION	COUNTY	TOTAL SHEET NO.
1700	05-00045-02-PV	COOK/DUPAGE	103
STREET LIGHTING PLAN			59
FED. ROAD DIST. NO. 7 ILLINOIS FED. AID PROJECT #-80035441			

NOTES:

1. THE LIGHTING UNIT SHALL BE INSTALLED SUCH THAT THE MAST ARM AND LUMINAIRE IS ORIENTATED PERPENDICULAR TO THE LIVELY BOULEVARD CENTERLINE.
2. ALL LABOR AND MATERIALS REQUIRED TO MAKE ELECTRICAL CONNECTIONS TO THE EXISTING SPARE CIRCUIT BREAKER IN THE CABINET SHALL BE INCLUDED IN THE COST FOR UNIT DUCT, WITH 3-1/8 NO. 4 AND 1-1/8 NO. 6 GROUND 600V (XLP-TYPE USE) 1 1/4" DIA. POLYETHYLENE.
3. RELOCATING THE EXISTING LIGHTING UNIT MUST BE COMPLETED THE SAME DAY FOR THE REINSTALLED LIGHTING UNIT AND ALL EXISTING LIGHTING CONNECTED TO IT SHALL BE OPERATIONAL THE SAME EVENING.
4. THE EXISTING METAL FOUNDATION SHALL BE REUSED FOR THE RELOCATED LIGHTING UNIT. THE COST TO REMOVE AND REINSTALL THE METAL FOUNDATION SHALL BE INCLUDED AS PART OF THE RELOCATED LIGHTING UNIT.
5. EMPTY POLYETHYLENE DUCT AND ELECTRIC CABLES IN CONDUIT WILL BE USED AT GREENLEAF AVENUE AND AT TOUHY AVENUE DURING THE FIRST STAGE OF MAINTENANCE OF TRAFFIC TO EXPEDITE THE RELOCATION OF EXISTING POLES. SEE GENERAL LIGHTING NOTE NO. 10 ON SHEET NO. 56.

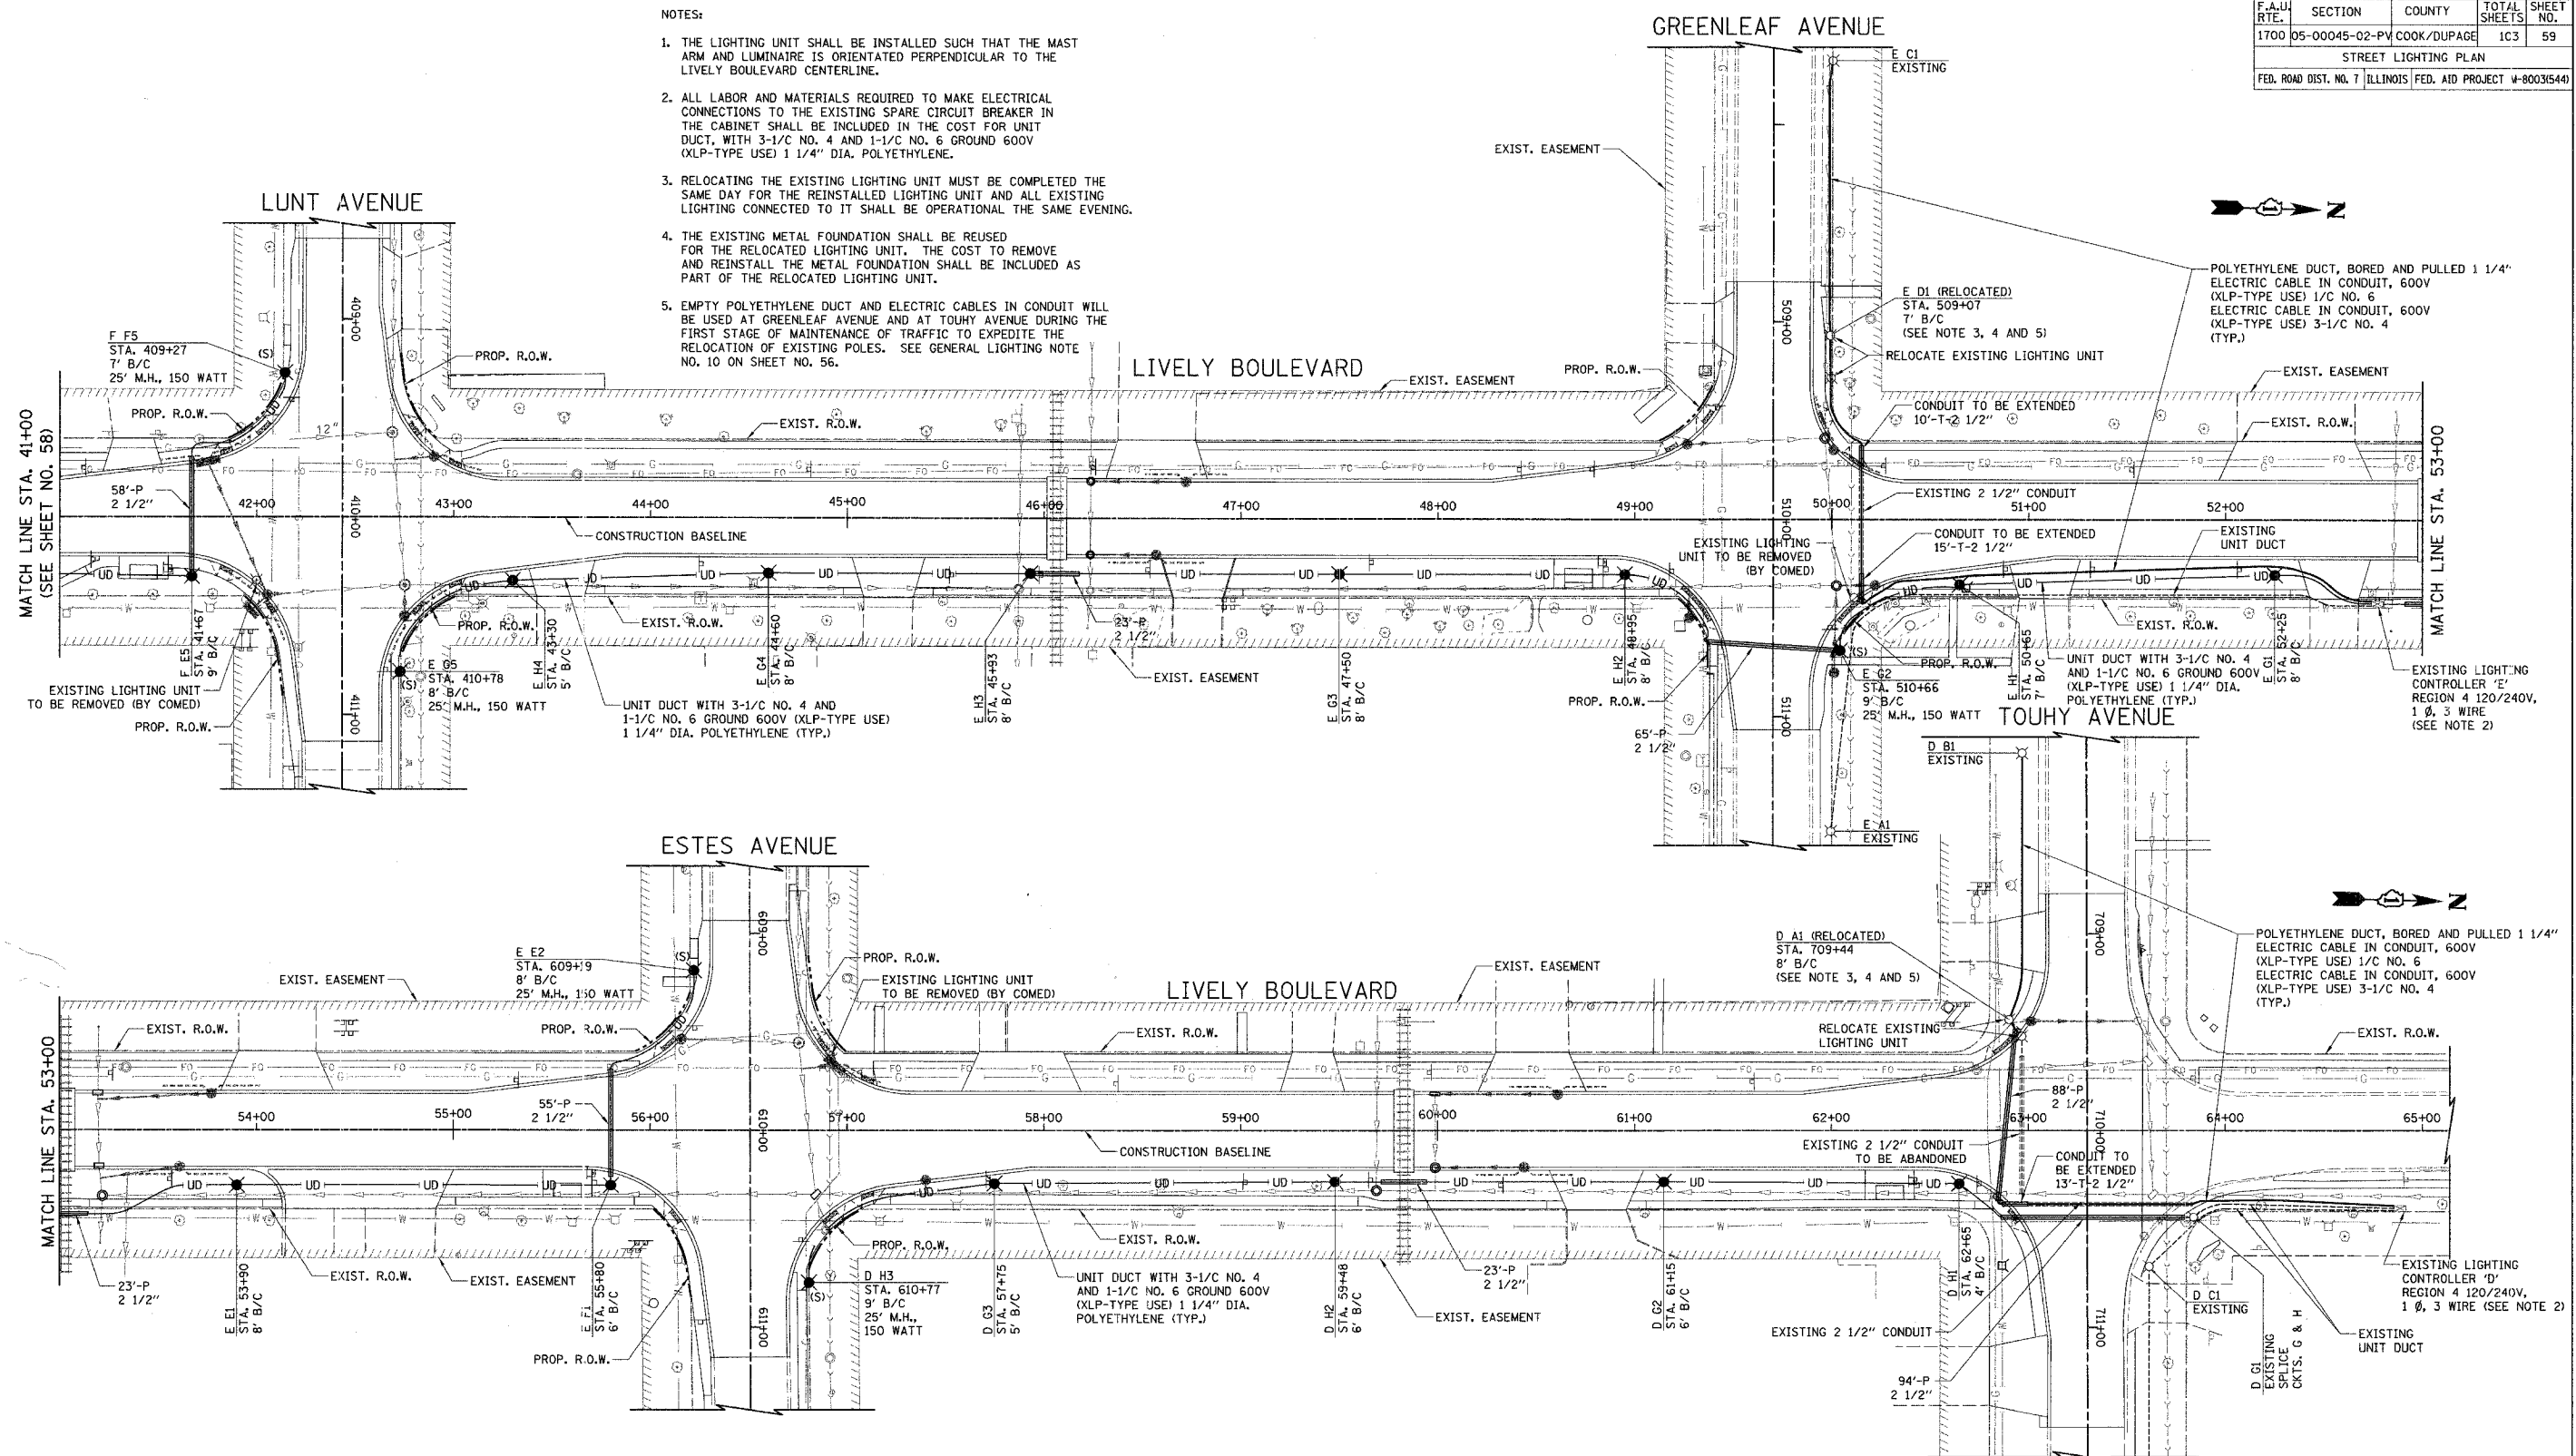

ILLINOIS DEPARTMENT OF TRANSPORTATION

**STREET LIGHTING PLAN**

LIVELY BOULEVARD  
STA. 41+00 TO STA. 63+49

SCALE IN FEET

DATE: 01/29/07  
DESIGNED BY: SJC  
CHECKED BY: JRJ