
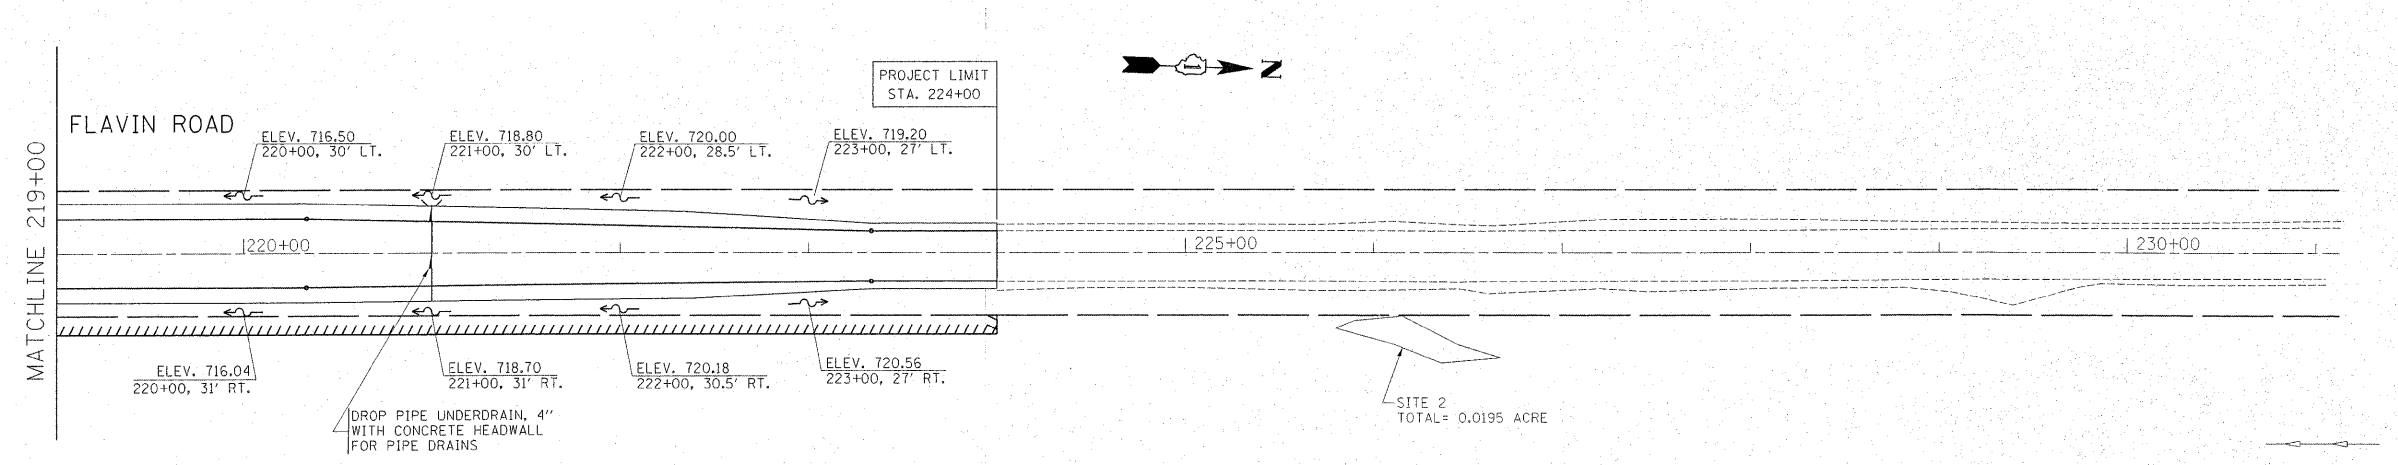


| | | | |
|------|------------|----|------|
| PLAN | SURVEYED | BY | DATE |
| | PLOTTED | | |
| | CHECKED | | |
| | RT. OF WAY | | |
| | CHECKED | | |
| | NO. _____ | | |
| | FILE NAME | | |

| | | | |
|---------|-----------|----|------|
| PROFILE | SURVEYED | BY | DATE |
| | PLOTTED | | |
| | CHECKED | | |
| | NO. _____ | | |
| | STRUCTURE | | |
| | NOTATION | | |
| | CHKD | | |

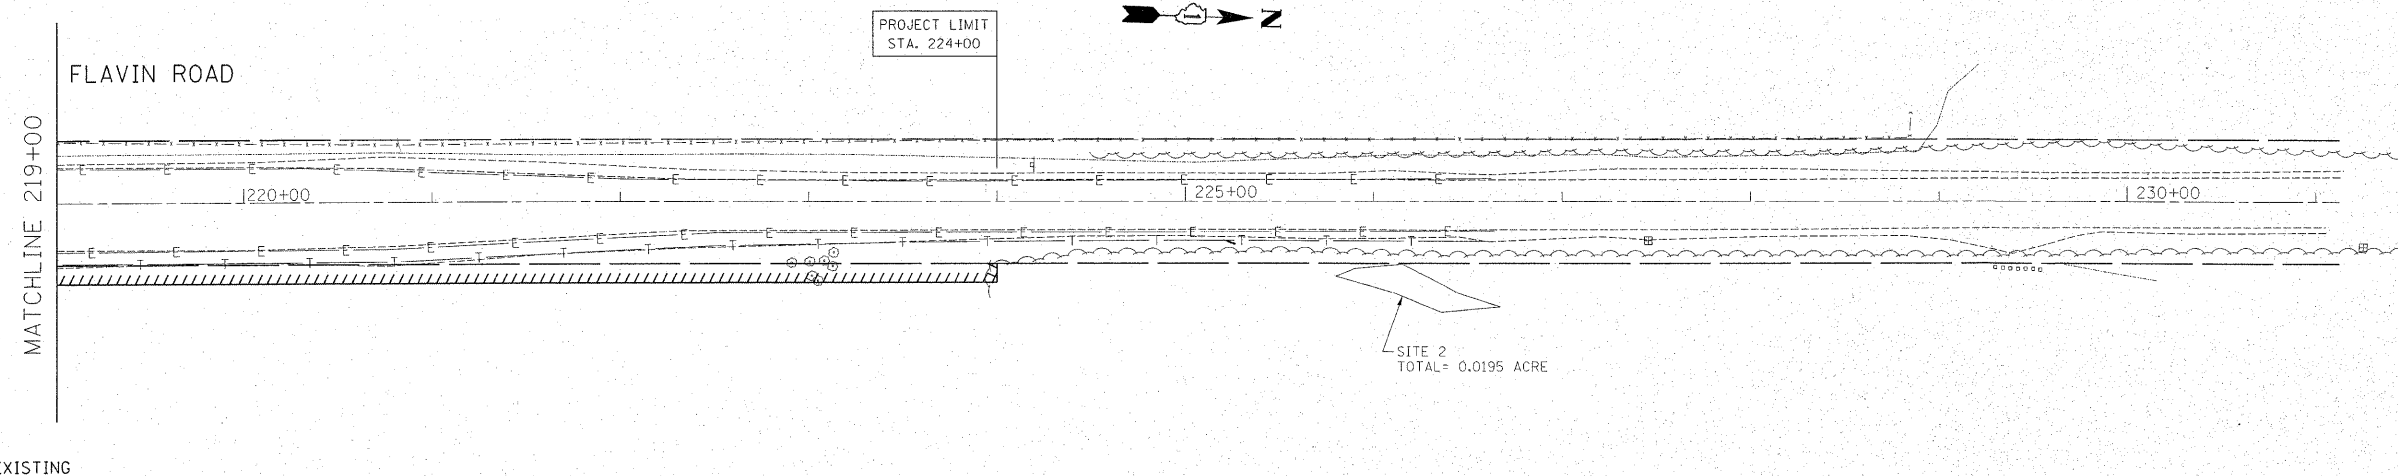


LEGEND

—○— STORM SEWER, EXISTING

—○— DITCH, PROPOSED

—+— SWALE, PROPOSED

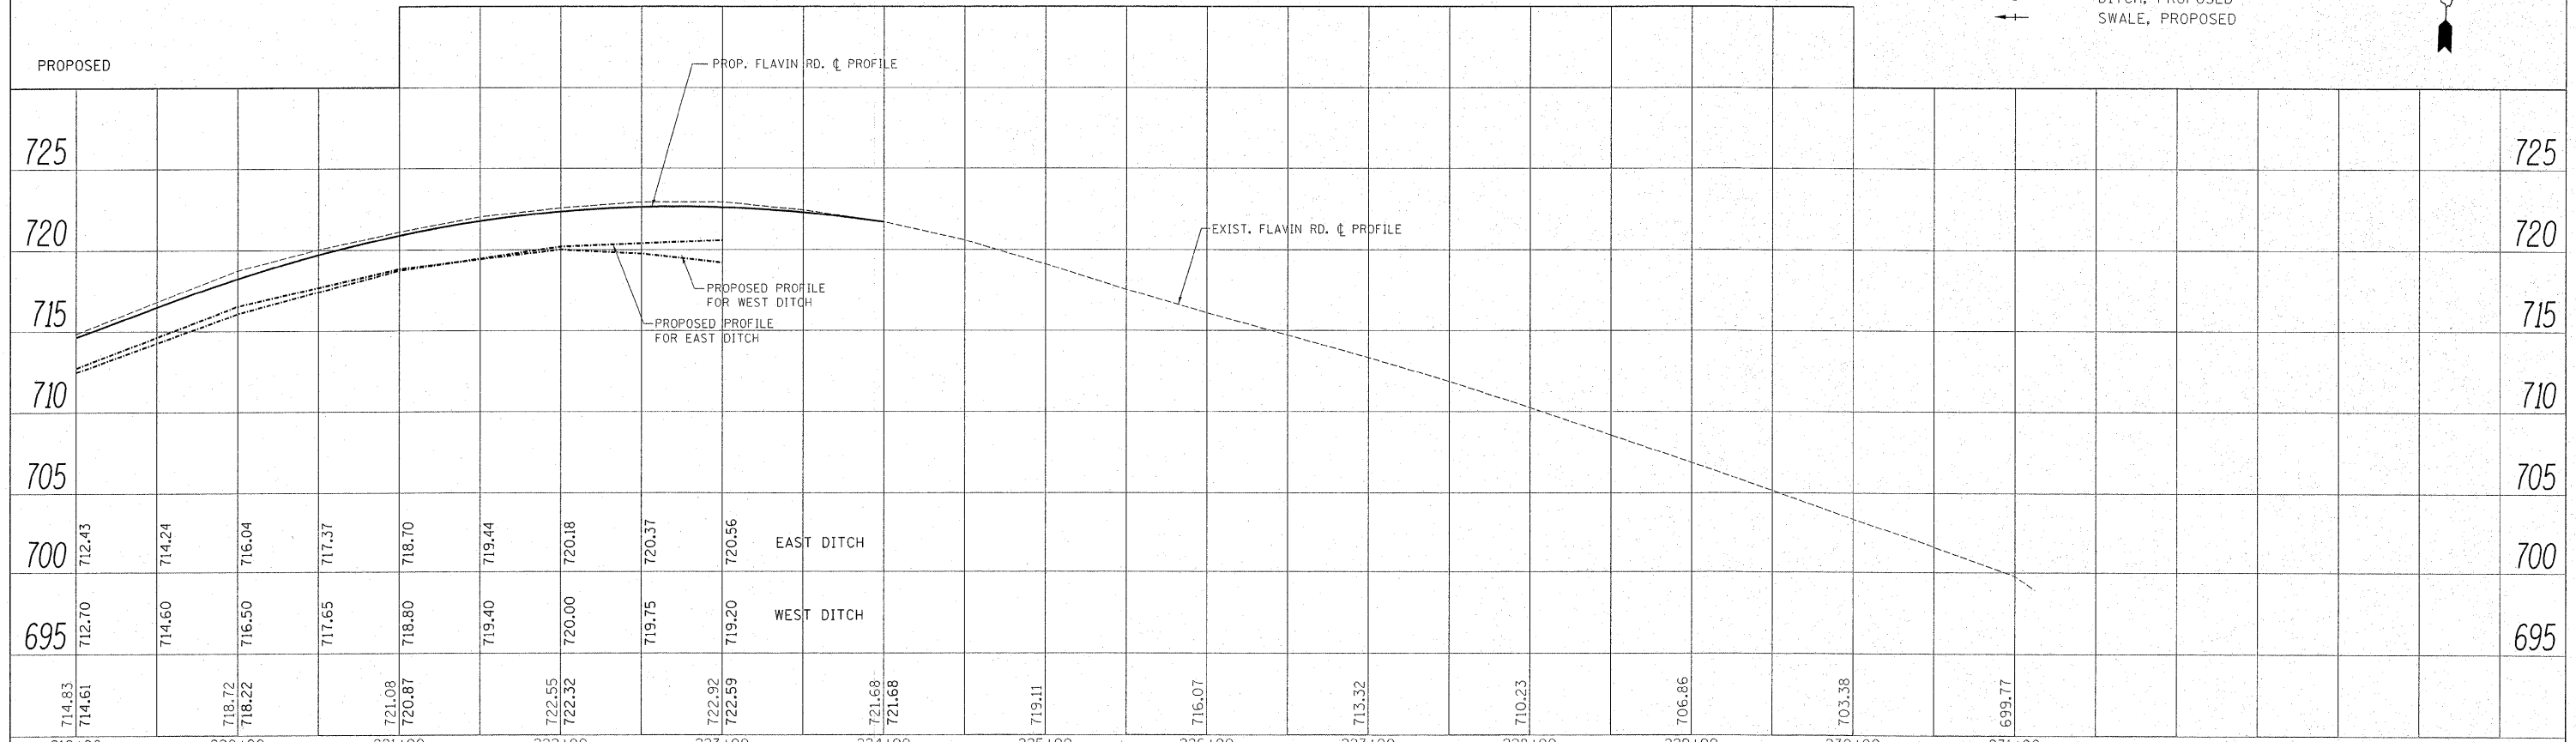

| | | | | | | | | | | |
|---|--------------------|------------|---------------------------|---|--|-------------|---------|--------|--------------|-----------|
| FILE NAME = | USER NAME = steepp | DESIGNED - | REVISED - | STATE OF ILLINOIS DEPARTMENT OF TRANSPORTATION | 104th AVE. / FLAVIN ROAD @ 95th STREET EXIST. & PROP. DRAINAGE PLAN | F.A.U. RTE. | SECTION | COUNTY | TOTAL SHEETS | SHEET NO. |
| ct:\pw_work\p\widat\steepp\d0159937\p14449\sh-t-drain.dgn | DRAWN - | REVISED - | 1566 | | | 29R-N-1 | COOK | 120 | 35 | |
| PLOT SCALE = 50.000' / 1" | CHECKED - | REVISED - | CONTRACT NO. 62377 | | | | | | | |
| PLOT DATE = 12/22/2011 | DATE - | REVISED - | ILLINOIS FED. AID PROJECT | | | | | | | |