



WEST SIDE PROFILE

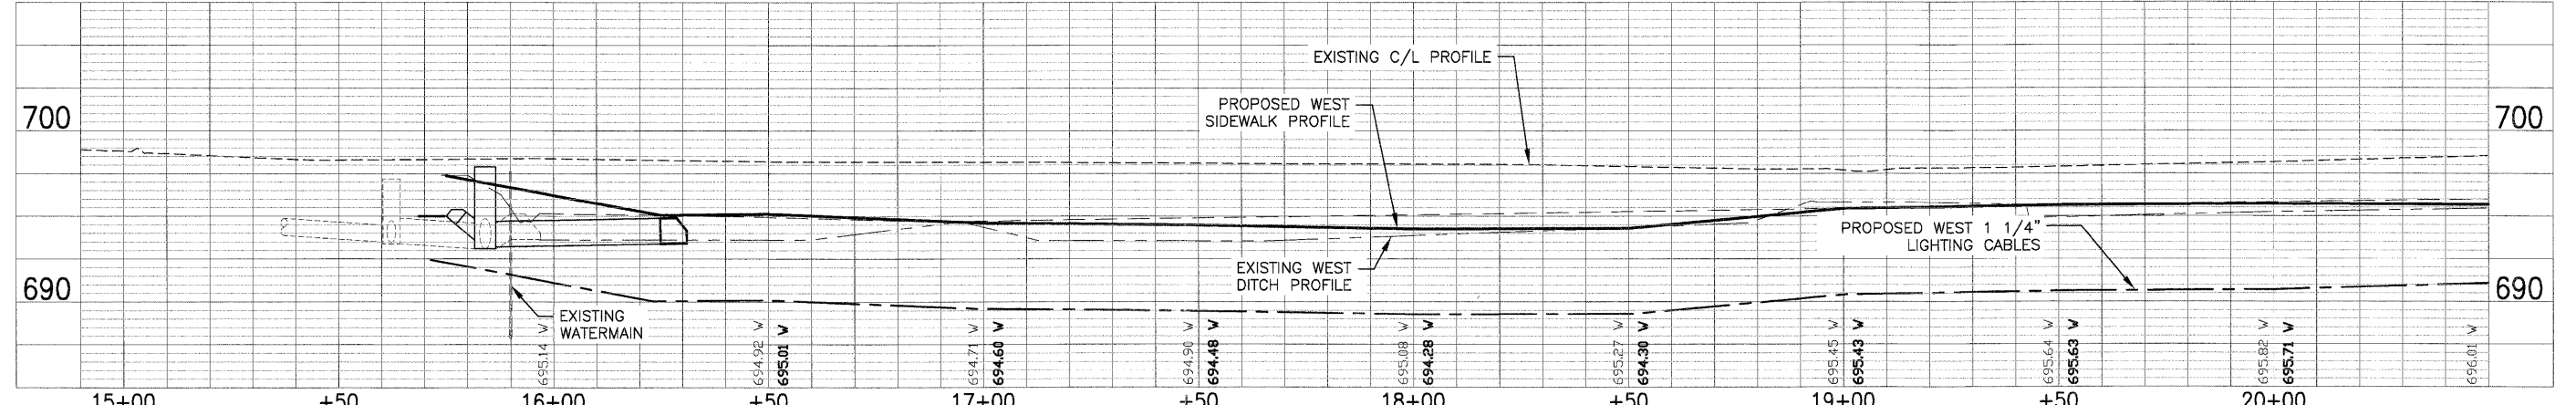

EAST SIDE PROFILE

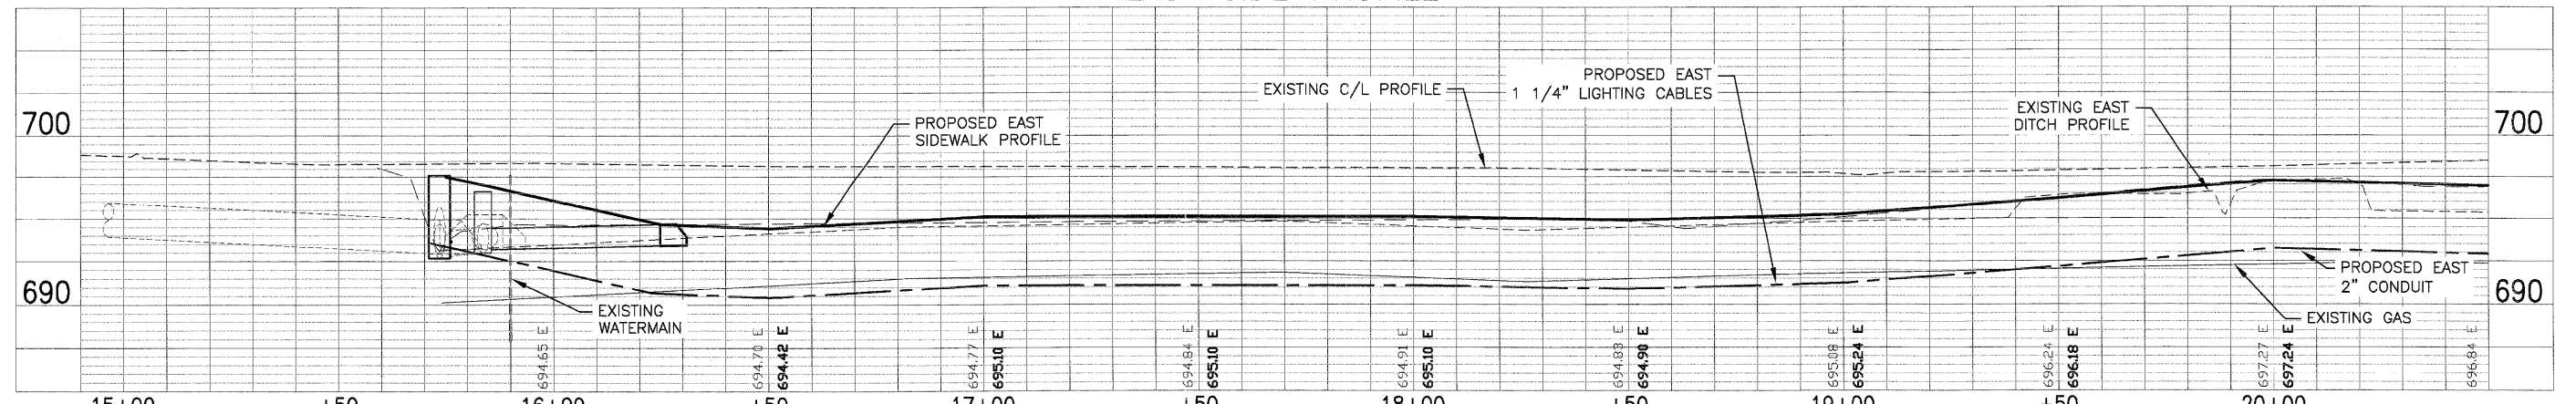

FILE NAME - P:\P0100\50\SURVEY\2010 FED\GREENLEAF.DWG	USER NAME -	DESIGNED - EKS	REVISED -	STATE OF ILLINOIS DEPARTMENT OF TRANSPORTATION	GREENLEAF AVENUE SIDEWALKS LIGHTING PLAN		F.A.U. RTE. 2701	SECTION 10-00042-00-SW	COUNTY LAKE	TOTAL SHEETS 34	SHEET NO. 19	
	PLOT SCALE - AS SHOWN	DRAWN - SRU	REVISED -		SHEET NO. 19 OF 34 SHEETS		STA. 15+75 TO STA. 20+50		CONTRACT NO. 63605			
	PLOT DATE -	CHECKED - MKK	REVISED -		ILLINOIS		FED. AID PROJECT					
		DATE - 12/29/2011	REVISED -									