

LEGEND:
 EXISTING DITCH
 WETLAND AREA
 TEMP. IMPACTED WETLAND AREA
 FLOODPLAIN
 FLOODWAY

MATCH LINE STATION 18+00

RECONSTRUCTION LIMIT
 STA. 22+52.79



RECONSTRUCTION LIMIT
 STA. 24+31.00

MATCH LINE STATION 29+00



| | | | |
|------|--------------------------|----|------|
| PLAN | SURVEYED | BY | DATE |
| | PLOTTED | | |
| | GRADES CHECKED | | |
| | STRUCTURE NOTATIONS CHKD | | |
| | NOTE BOOK NO. | | |
| | CADD FILE NAME | | |

| | | | |
|---------|--------------------------|----|------|
| PROFILE | SURVEYED | BY | DATE |
| | PLOTTED | | |
| | GRADES CHECKED | | |
| | STRUCTURE NOTATIONS CHKD | | |
| | NOTE BOOK NO. | | |
| | CADD FILE NAME | | |

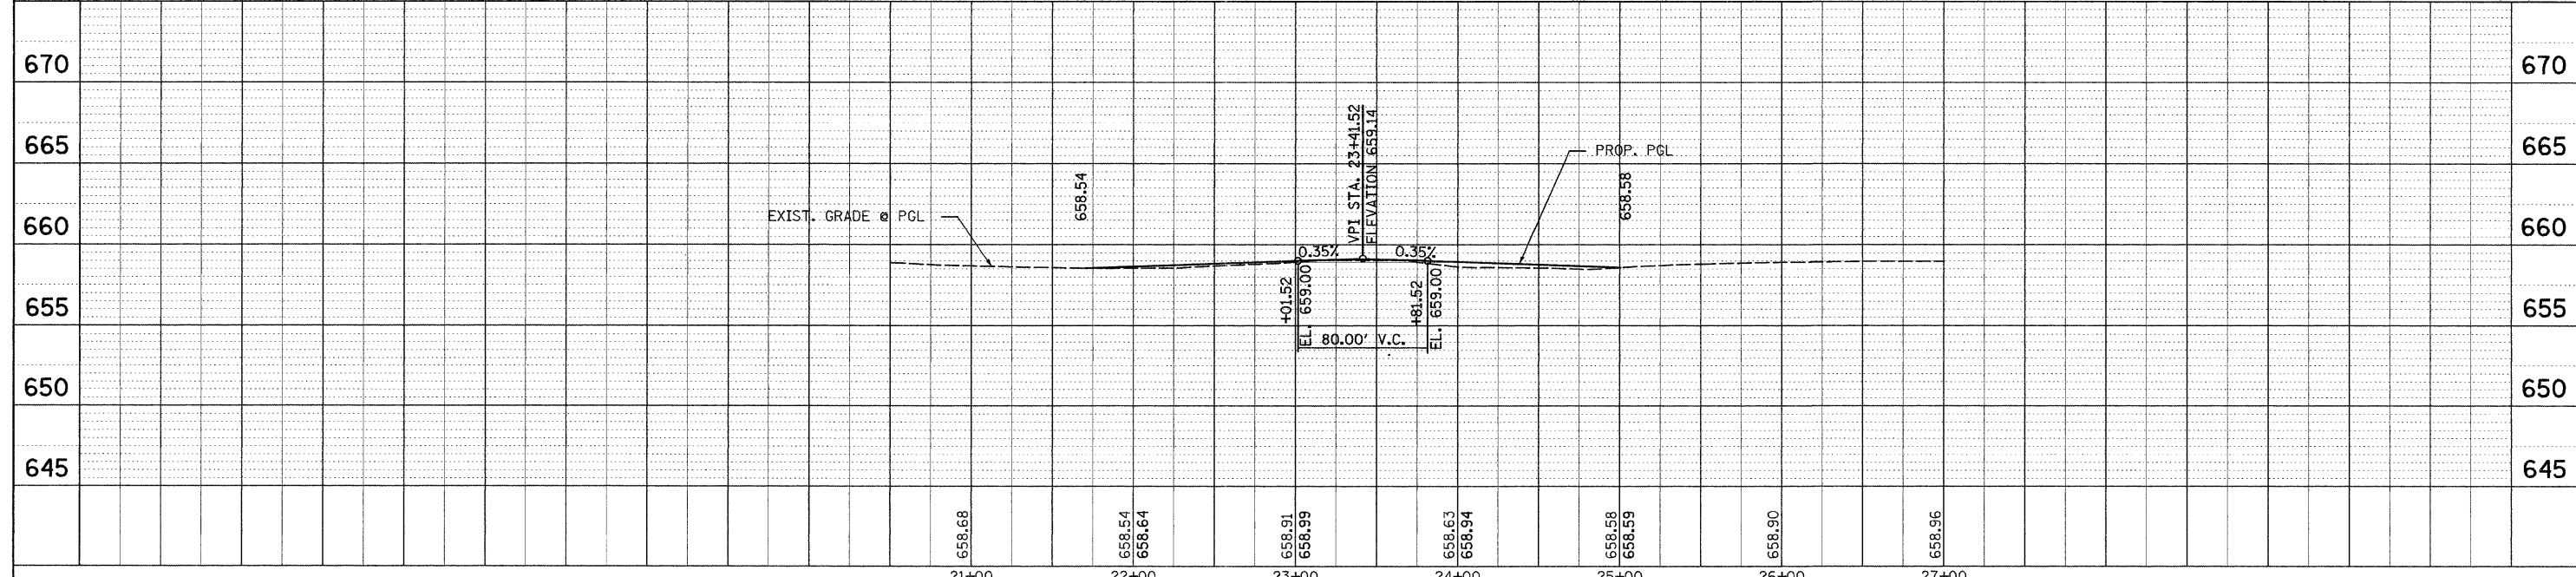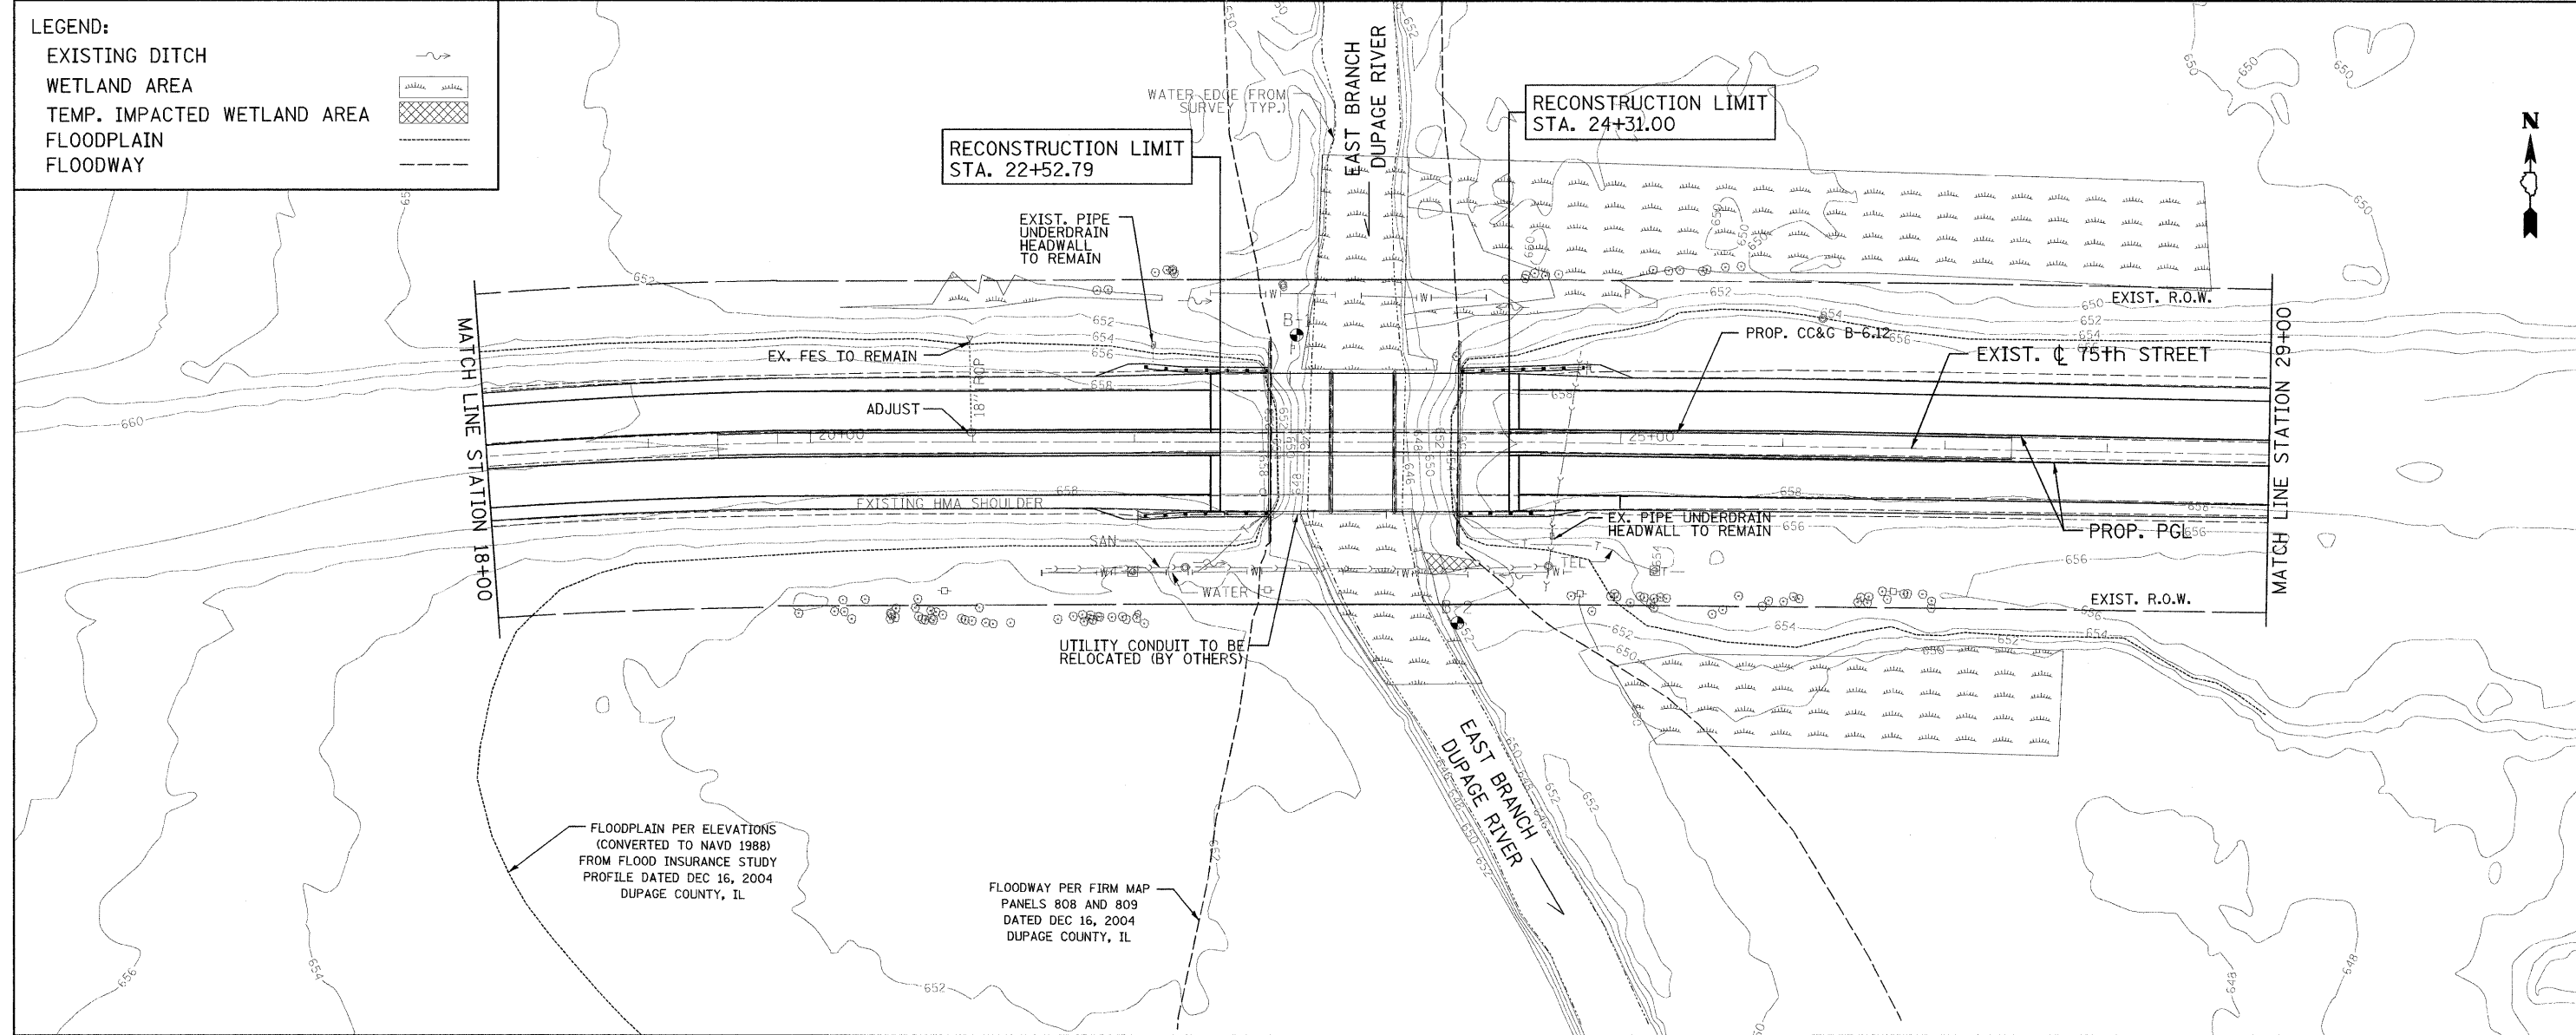

| | | | | | | | | | | |
|-----------------------------------|-------------------|-----------|---|---|--|---|----------------|--------|--------------|-----------|
| USER NAME = Pbrun (Rdy_Lis) | DESIGNED - PRB | REVISED - | PATRICK ENGINEERING INC. 4970 VARSITY DRIVE LUSLE, IL 60532 patrickengineering.com | DUPAGE COUNTY DIVISION OF TRANSPORTATION | DRAINAGE AND UTILITIES PLAN AND PROFILE 75TH STREET OVER EAST BRANCH DUPAGE RIVER | FAP RTE. | SECTION | COUNTY | TOTAL SHEETS | SHEET NO. |
| PLOT CONFIG = PDF(Grey_Large).plt | DRAWN - PRB | REVISED - | | | | 0369 | 08-00162-03-BR | DUPAGE | 58 | 20 |
| PLOT SCALE = 1:50 | CHECKED - ADJ | REVISED - | | | | CONTRACT NO. 63662 | | | | |
| PLOT DATE = 1/19/2012 | DATE - 12-19-2011 | REVISED - | | | | FED. ROAD DIST. NO. ILLINOIS FED. AID PROJECT | | | | |

G:\DPC001\21158\007\Drawings\RDW\1\shfts\01ra\5-Dra_02.dgn