


STATE OF ILLINOIS
DEPARTMENT OF TRANSPORTATION
DIVISION OF HIGHWAYS

F.A.U. RTE. 1453	SECTION 11-00043-00-LS	COUNTY DU PAGE	TOTAL SHEETS 20	SHEET NO. 1
FED. ROAD DIST. NO. 1		ILLINOIS	FED. AID PROJECT TE-00D1 (872)	
CONTRACT NO. 63663				

PLANS FOR PROPOSED FEDERAL AID PROJECT

FAU 1453 (WEST 22ND STREET)
SPRING ROAD TO SALT CREEK
STREETSCAPE ENHANCEMENTS
SECTION NO: 11-00043-00-LS
PROJECT NO: TE-00D1 (872)
VILLAGE OF OAK BROOK
DUPAGE COUNTY
JOB NO: C-91-501-11

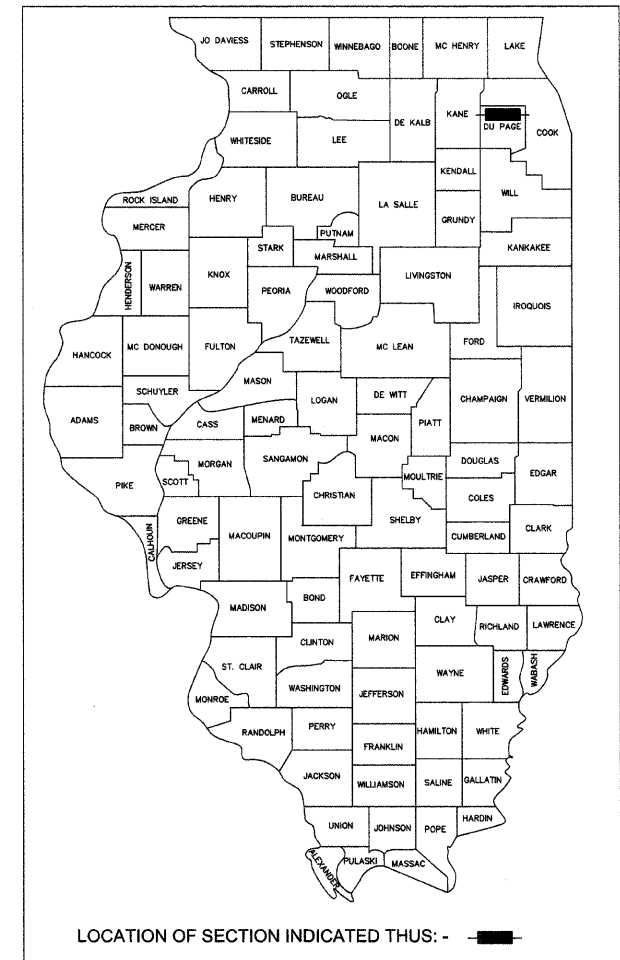


INDEX OF SHEETS


SHEET NO.	SHEET DESCRIPTION
1	COVER SHEET
2	SUMMARY OF QUANTITIES, GENERAL NOTES, AND HIGHWAY STANDARDS
3	EXISTING CONDITIONS
4	TYPICAL SECTIONS
5-6	LAYOUT AND MATERIALS PLAN
7-8	LANDSCAPE PLAN
9	LANDSCAPE DETAILS AND NOTES
10-11	ELECTRICAL PLAN
12	ELECTRICAL DETAILS AND NOTES
13-14	IRRIGATION PLAN
15	IRRIGATION LEGEND AND NOTES
16	IRRIGATION DETAILS
17-20	CONSTRUCTION DETAILS HIGHWAY STANDARDS

TRAFFIC DATA

ADT = 29,700 VPD (2011)
POSTED SPEED LIMIT = 40 MPH
FUNCTIONAL CLASSIFICATION = MINOR ARTERIAL

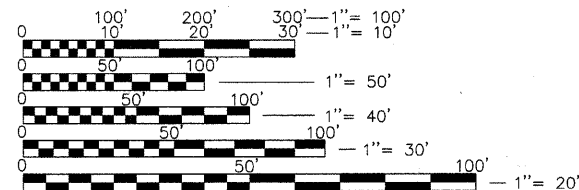


FULL SIZE PLANS HAVE BEEN PREPARED USING STANDARD ENGINEERING SCALES. REDUCED SIZED PLANS WILL NOT CONFORM TO STANDARD SCALES. IN MAKING MEASUREMENTS ON REDUCED PLANS, THE ABOVE SCALES MAY BE USED.

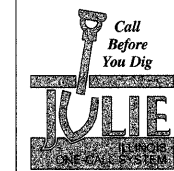


CONTACT JULIE 48 HOURS (2 WORKING DAYS) BEFORE YOU DIG AT 811 OR 800-892-0123 WITH THE FOLLOWING:

COUNTY: DU PAGE
VILLAGE: OAK BROOK
TOWNSHIP: YORK

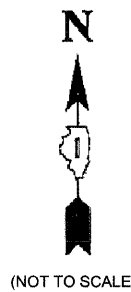

(NOT TO SCALE)

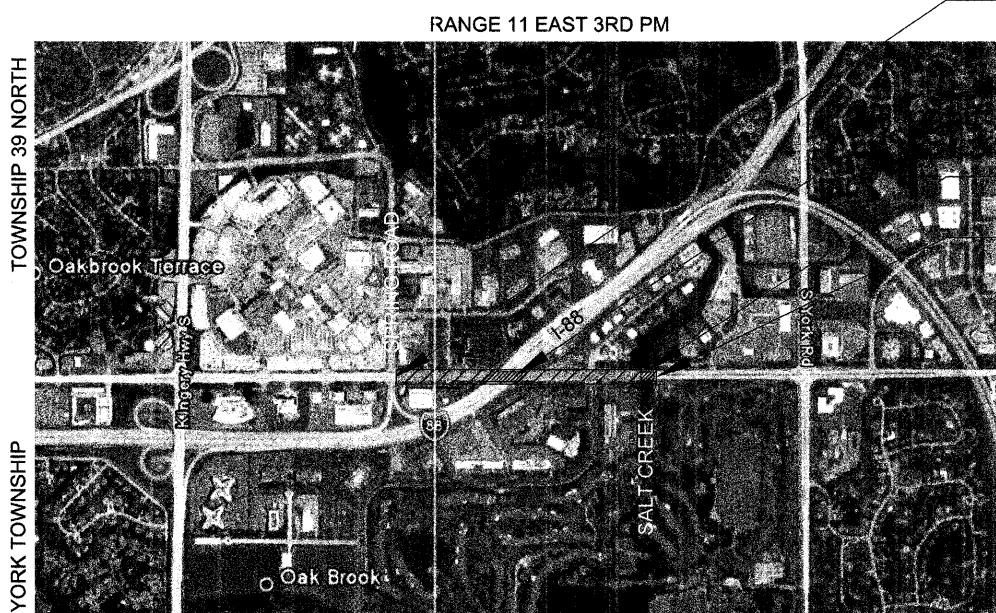

LOCATION MAP
SCALE: 1" = 500'
GROSS LENGTH OF IMPROVEMENT: 3,095 FT (0.586 MILES)
NET LENGTH OF IMPROVEMENT: 3,095 FT (0.586 MILES)

PROJECT BEGINS
STA 2106+83.00

EXISTING STRUCTURE NOS. 022-9901
022-9941
022-9942

EXISTING STRUCTURE NO. 022-0084

PROJECT ENDS
STA 2137+78.00



STATE OF ILLINOIS
DEPARTMENT OF TRANSPORTATION
DIVISION OF HIGHWAYS

APPROVED 12/16 2011
[Signature]
VILLAGE REPRESENTATIVE

PASSED January 5 2012
[Signature]
DISTRICT ENGINEER OF LOCAL ROADS & STREETS

RELEASING FOR BID
BASED ON LIMITED
REVIEW JANUARY 6, 2012
[Signature]
DEPUTY DIRECTOR OF HIGHWAYS, REGION ONE ENGINEER

PRINTED BY THE AUTHORITY
OF THE STATE OF ILLINOIS

CONTRACT NO. 63663

HDG PROJECT NO: 03-0745-008-01-06 DATE: 12-19-11

PROGRAM AND OFFICE ENGINEER: CHARLES F. RIDDLER, P.E. 847-705-4406 SCHAUMBURG, IL