



US 20 SN 043-0006 (WB)

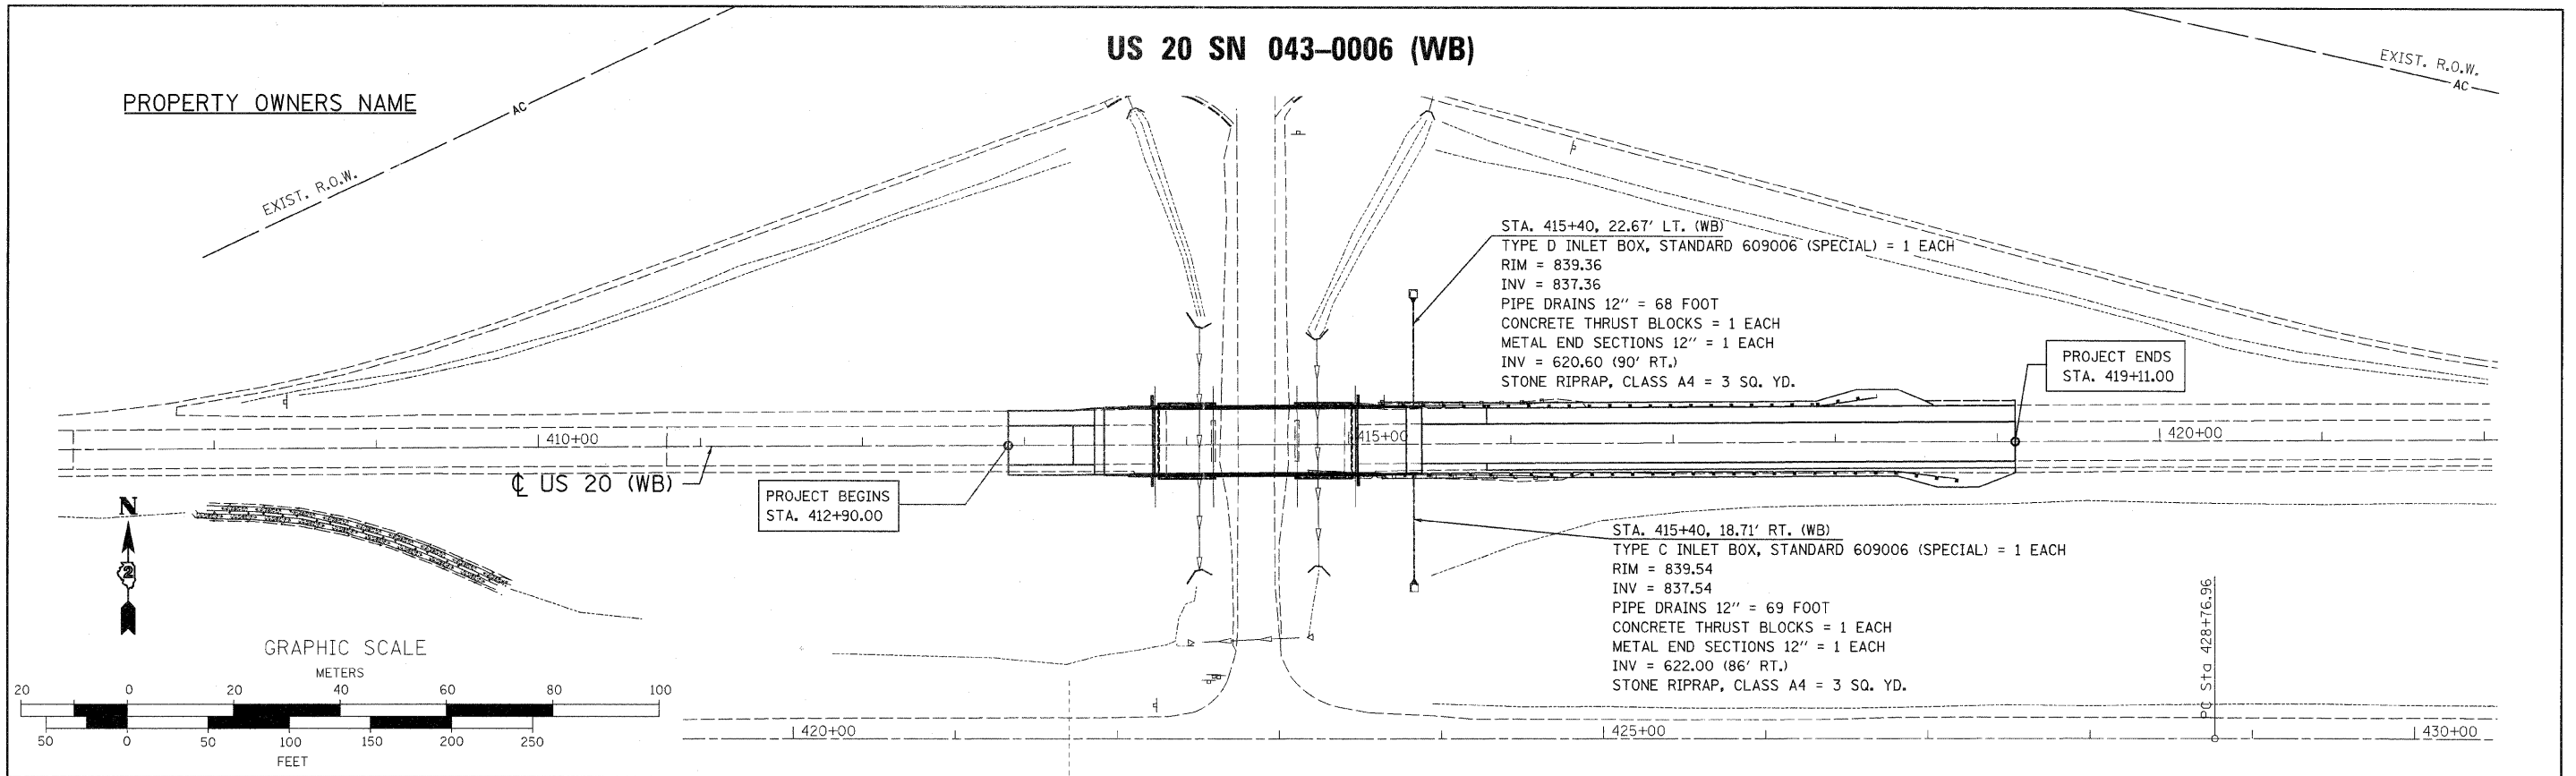

US 20 SN 043-0007 (EB)

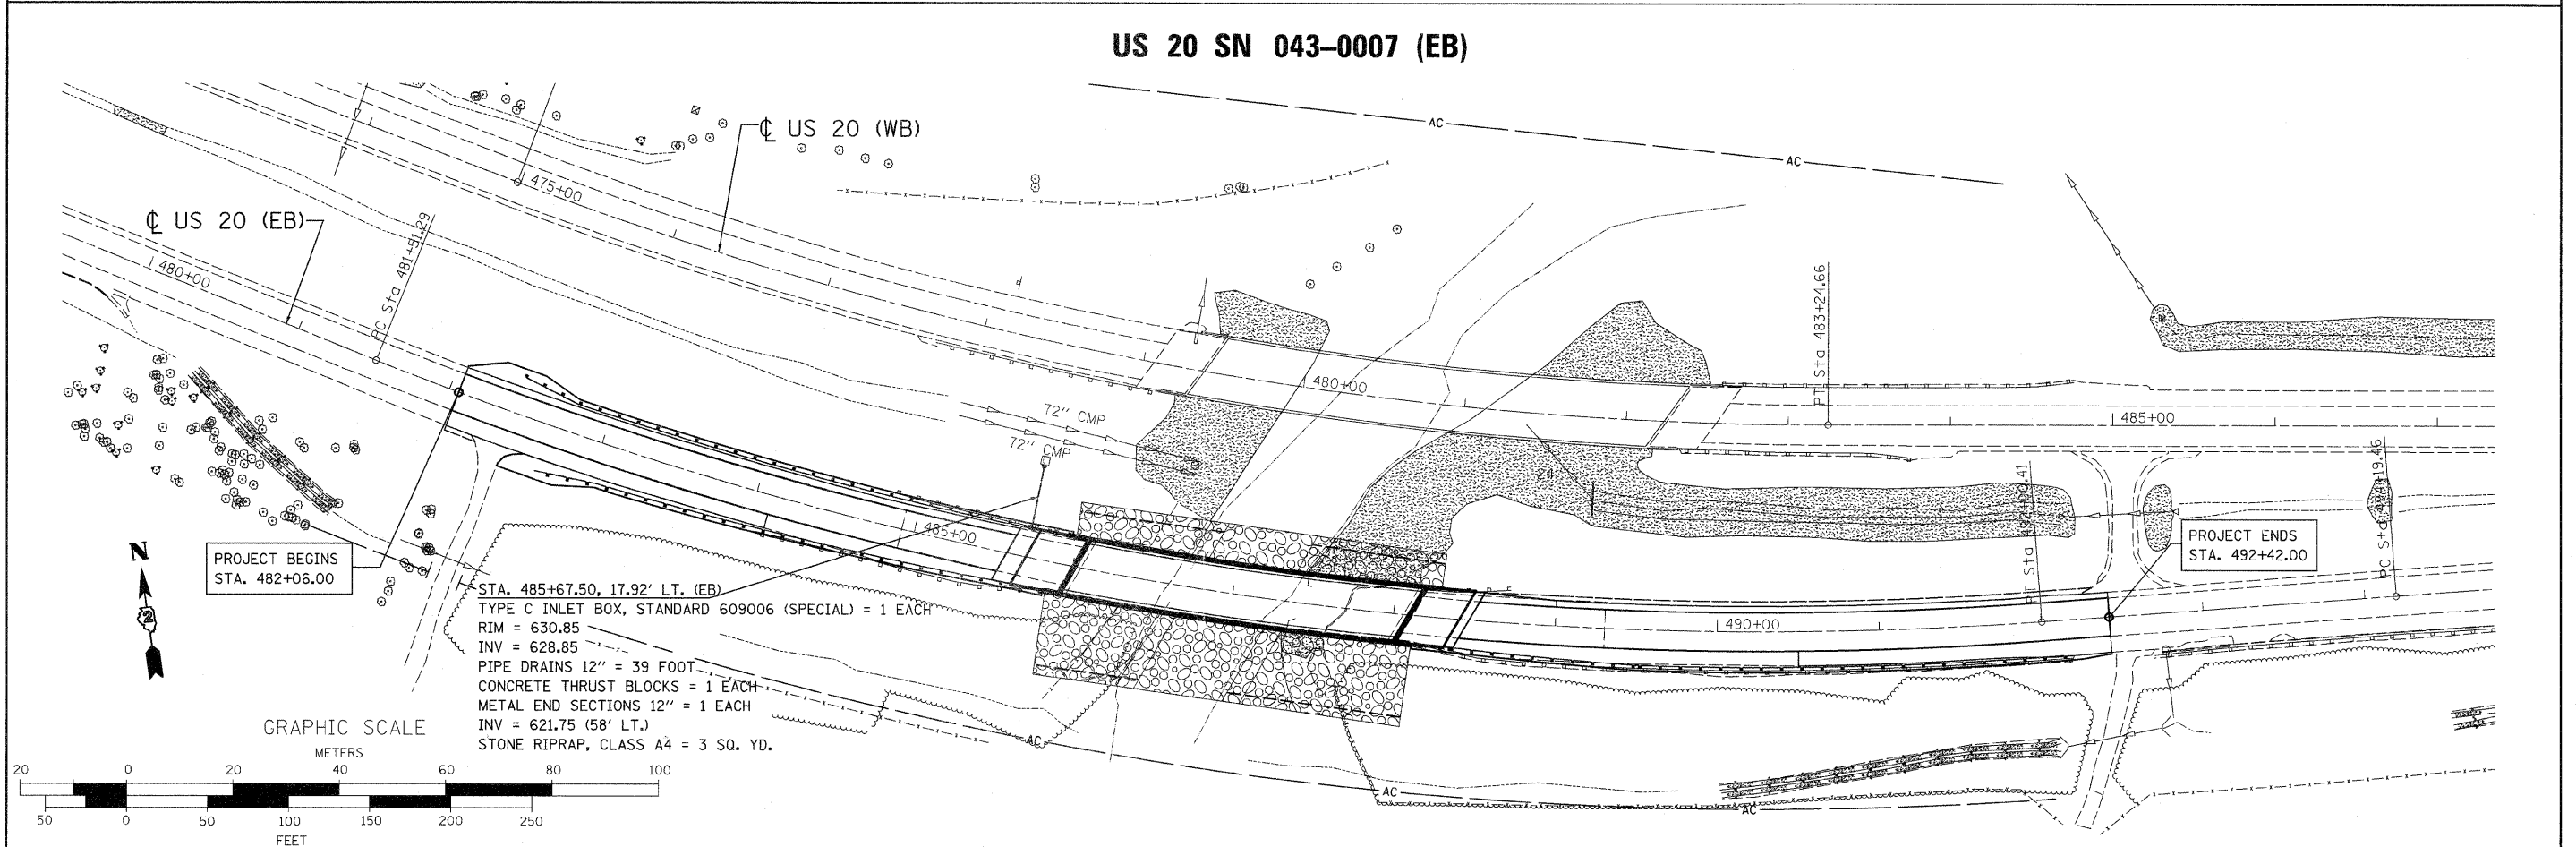

USER NAME = *OPERATOR*	DESIGNED -	REVISED -
FILE NAME = *FILES*	CHECKED -	REVISED -
PLOT DATE = Thu Dec 08 10:23:22	DRAWN -	REVISED -
PLOT TIME = *TIME*	CHECKED -	REVISED -



1701 ROUTE 35 NORTH  
EAST DUBUQUE, IL 61025  
(815) 747-8833  
DESIGN FIRM #184001038

STATE OF ILLINOIS  
DEPARTMENT OF TRANSPORTATION

US 20 DRAINAGE PLAN	
SCALE: 1" = 50'	SHEET NO. 2 OF 2 SHEETS
STA.	TO STA.

F.A.P. RTE. 301	SECTION (43B,44B,44HB,45BID)	COUNTY JO DAVIESS	TOTAL SHEETS 309	SHEET NO. 79
CONTRACT NO. 64C94				
ILLINOIS FED. AID PROJECT				