
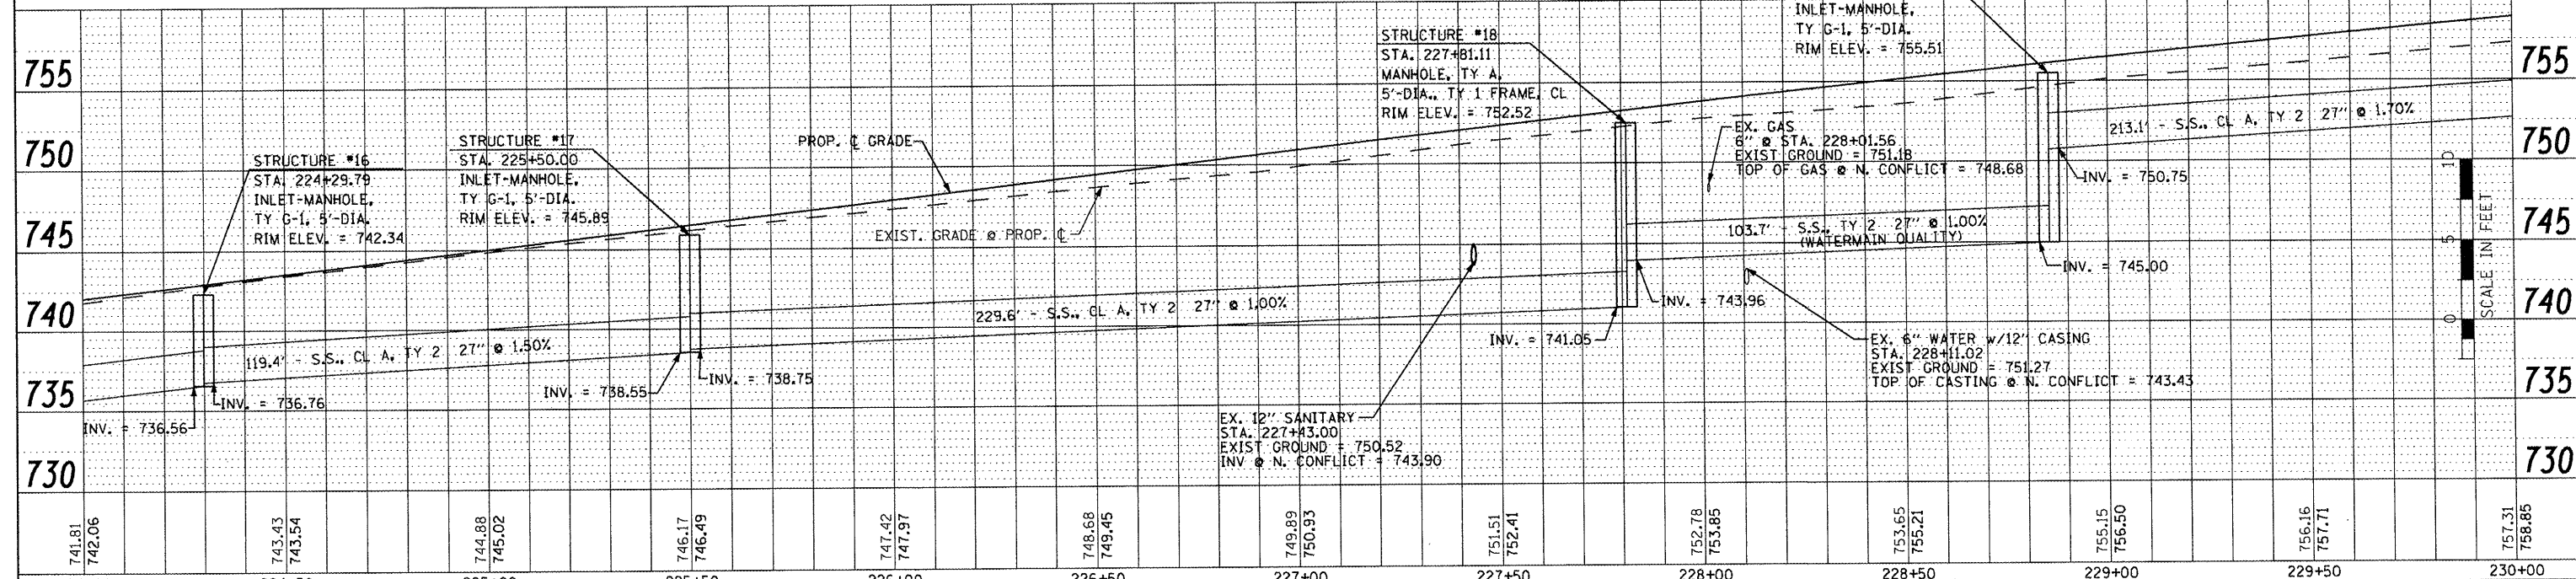


DATE	
BY	
REVISION	
NO.	
DATE	
BY	
REVISION	
NO.	
DATE	
BY	
REVISION	
NO.	

DATE	
BY	
REVISION	
NO.	
DATE	
BY	
REVISION	
NO.	
DATE	
BY	
REVISION	
NO.	

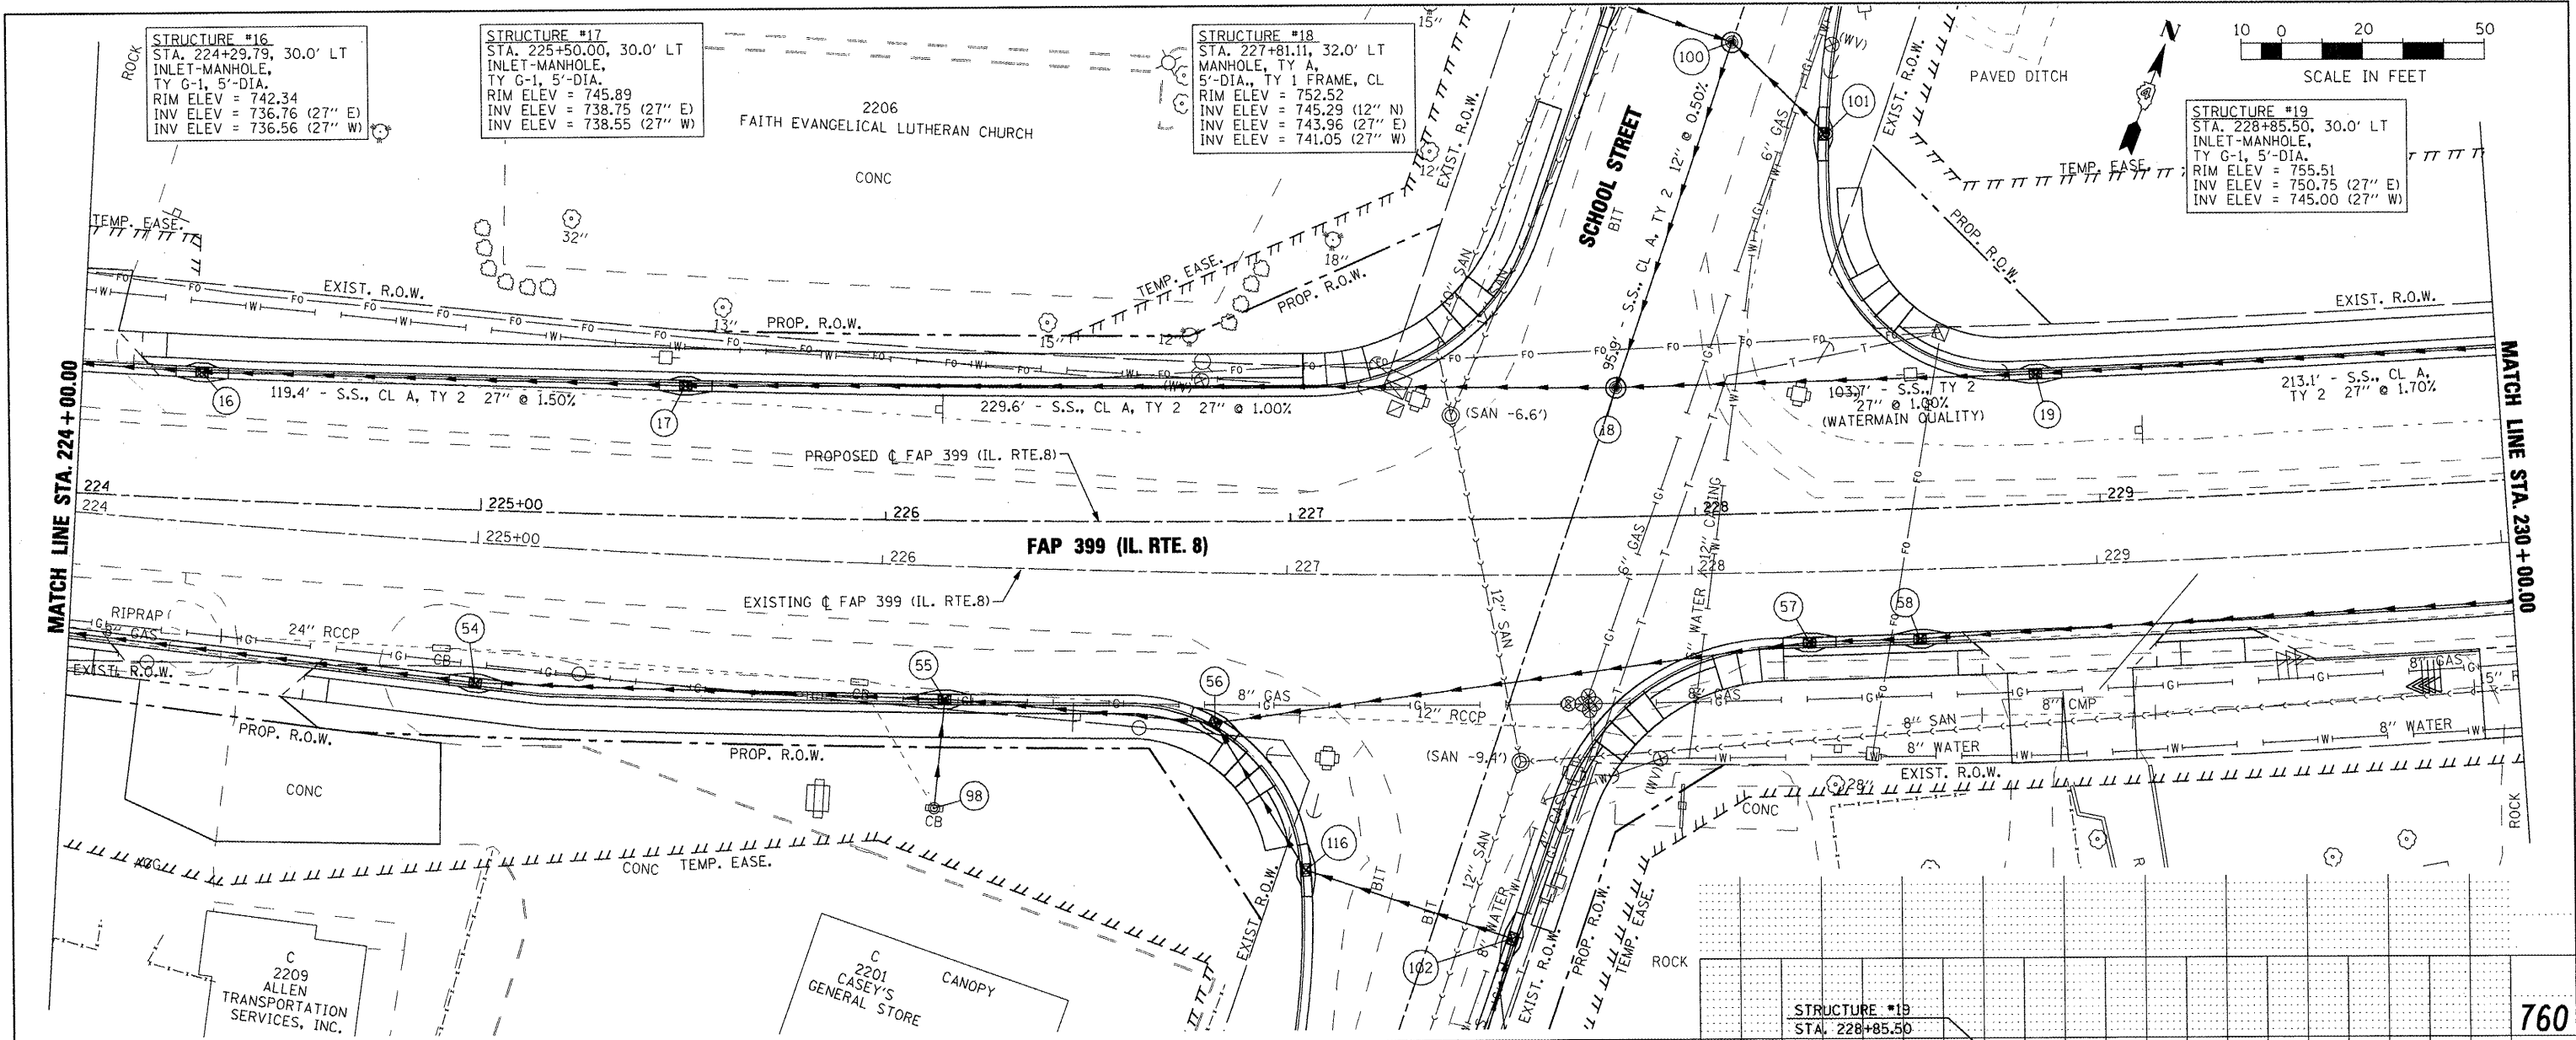

FILE NAME =	USER NAME = IDDT	DESIGNED -	REVISED -	STATE OF ILLINOIS DEPARTMENT OF TRANSPORTATION FAP 399 (IL. RTE. 8) DRAINAGE PLAN AND PROFILE - NORTH				F.A. RTE.	SECTION	COUNTY	TOTAL SHEETS	SHEET NO.
xi:\proj\jct\200803566\dgn\14-Rte8-shd-DRAIN-5-NORTH.dgn		DRAWN -	REVISED -					399	36 R-7	TAZEWELL	390	181
PLOT SCALE = 40.0000' / IN.		CHECKED -	REVISED -					CONTRACT NO. 68370				
PLOT DATE = 10/21/2011		DATE -	REVISED -					ILLINOIS FED. AID PROJECT				
				SCALE: AS SHOWN	SHEET NO.	OF SHEETS	STA. 224+00.00 TO STA. 230+00.00					