
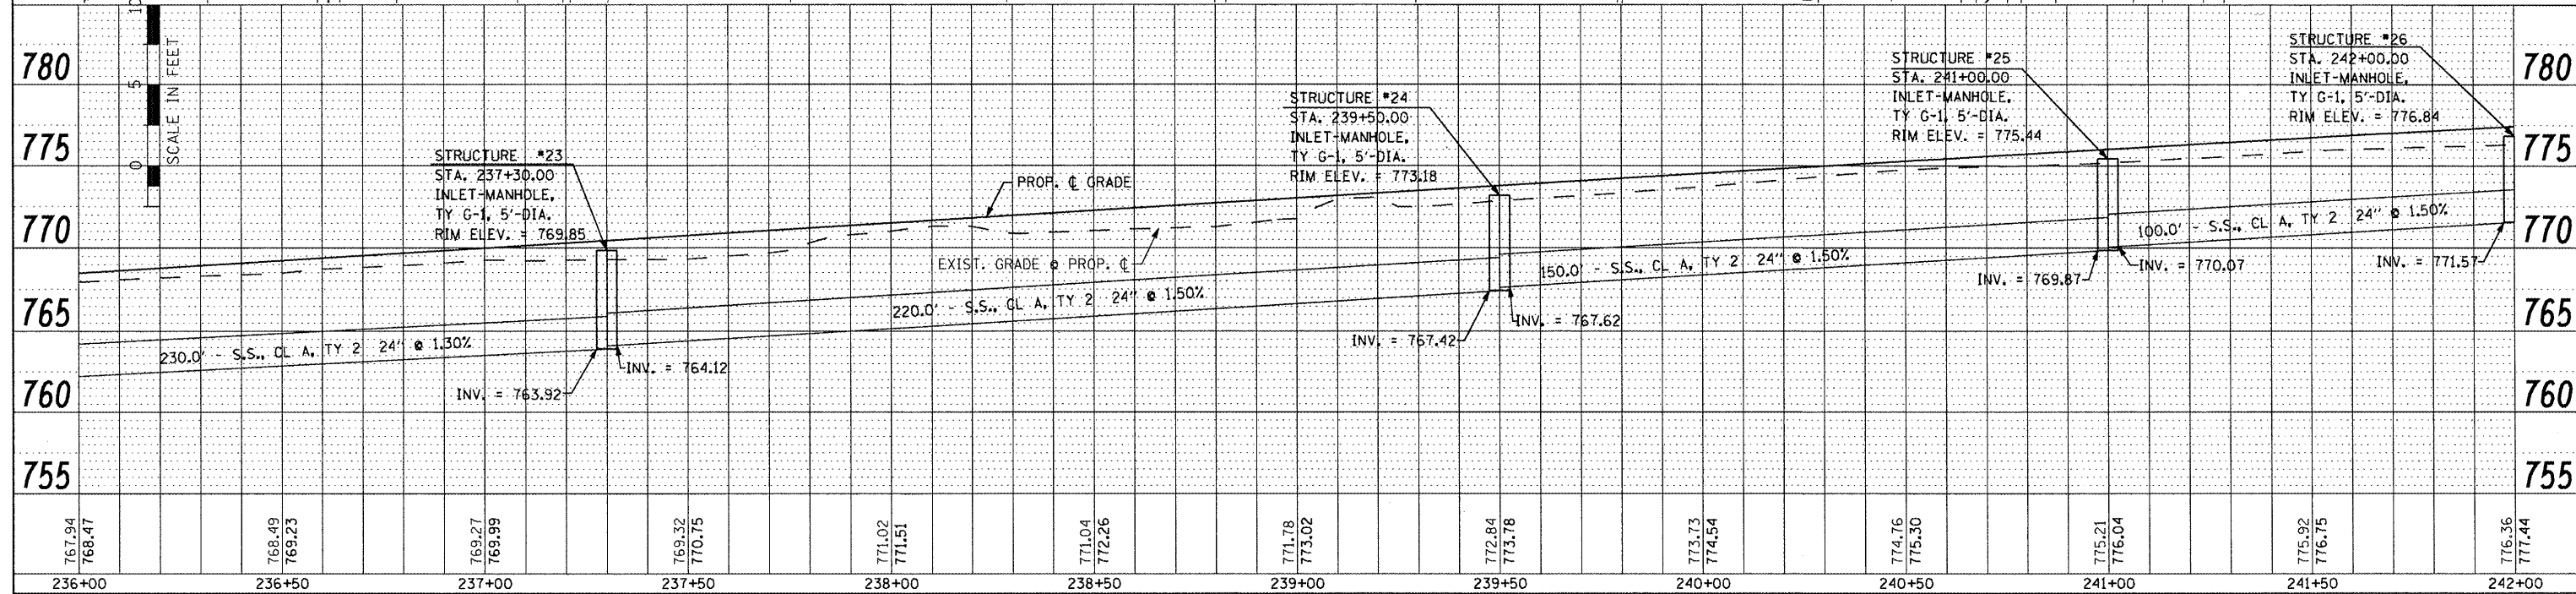


DATE	
BY	
REVISIONS	
NO.	
PLAN	
NO.	
NOTE BOOK	
NO.	
CAD FILE NAME	

DATE	
BY	
REVISIONS	
NO.	
PROFILE	
NO.	
NOTE BOOK	
NO.	
STRUCTURE	
NOTATION	

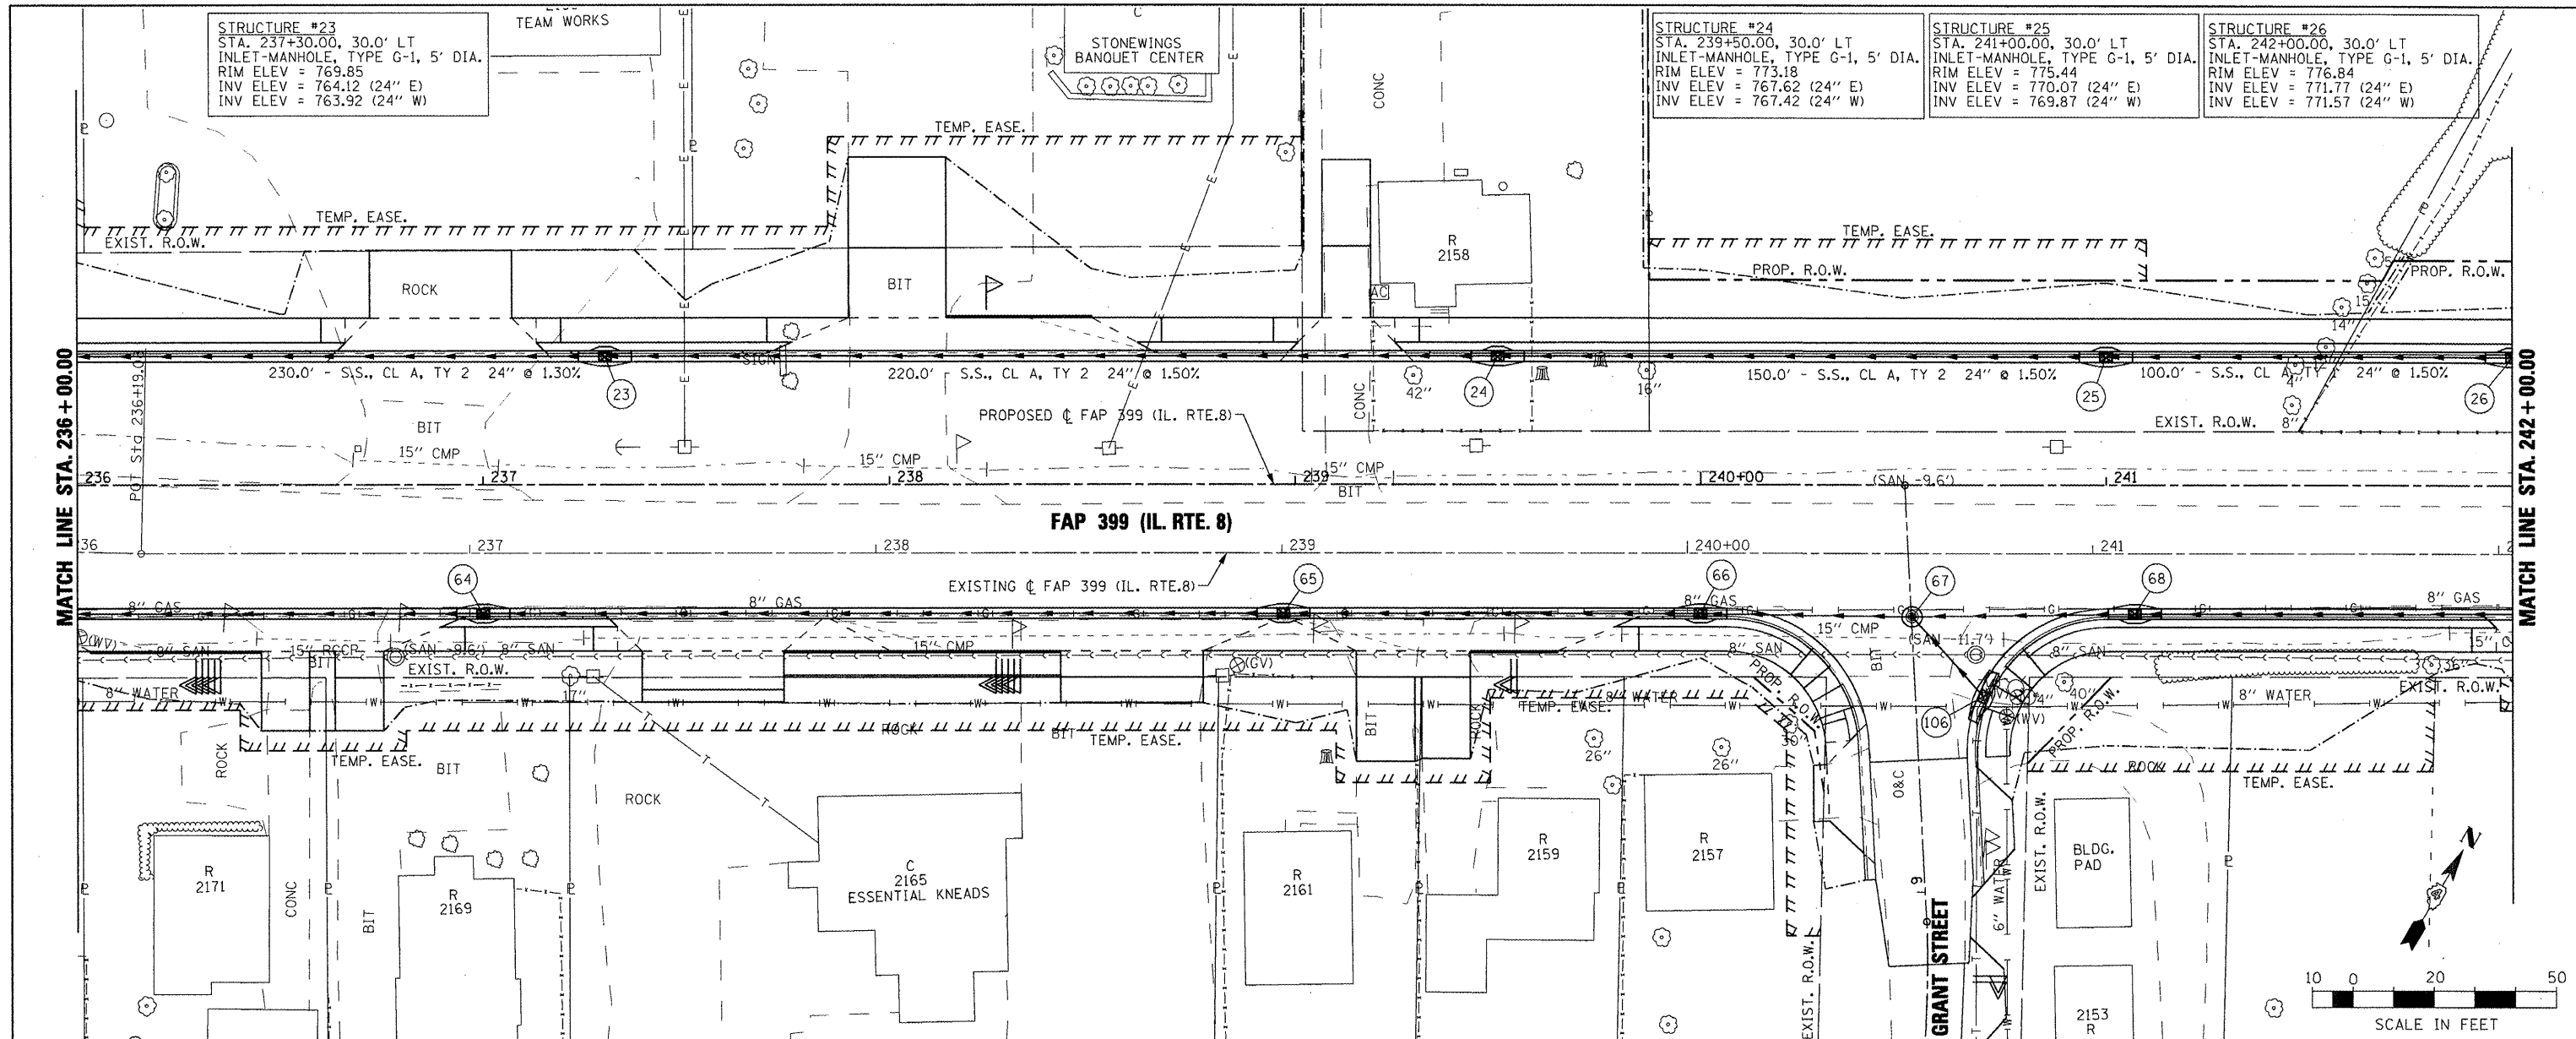

FILE NAME =	USER NAME = IDDT	DESIGNED -	REVISED -	STATE OF ILLINOIS DEPARTMENT OF TRANSPORTATION	FAP 399 (IL. RTE. 8) DRAINAGE PLAN AND PROFILE - NORTH			F.A. RTE.	SECTION	COUNTY	TOTAL SHEETS	SHEET NO.
x:\proj\jeets\200803566\dgn\04-Rte8-shd-DRAIN-7_NORTH.dgn		DRAWN -	REVISED -		399	36 R-7	TAZEWELL	390	183			
PLOT SCALE = 40.0000' / IN.		CHECKED -	REVISED -		SCALE: AS SHOWN SHEET NO. OF SHEETS STA. 236+00.00 TO STA. 242+00.00				CONTRACT NO. 68370			
PLOT DATE = 10/21/2011		DATE -	REVISED -		ILLINOIS FED. AID PROJECT							