
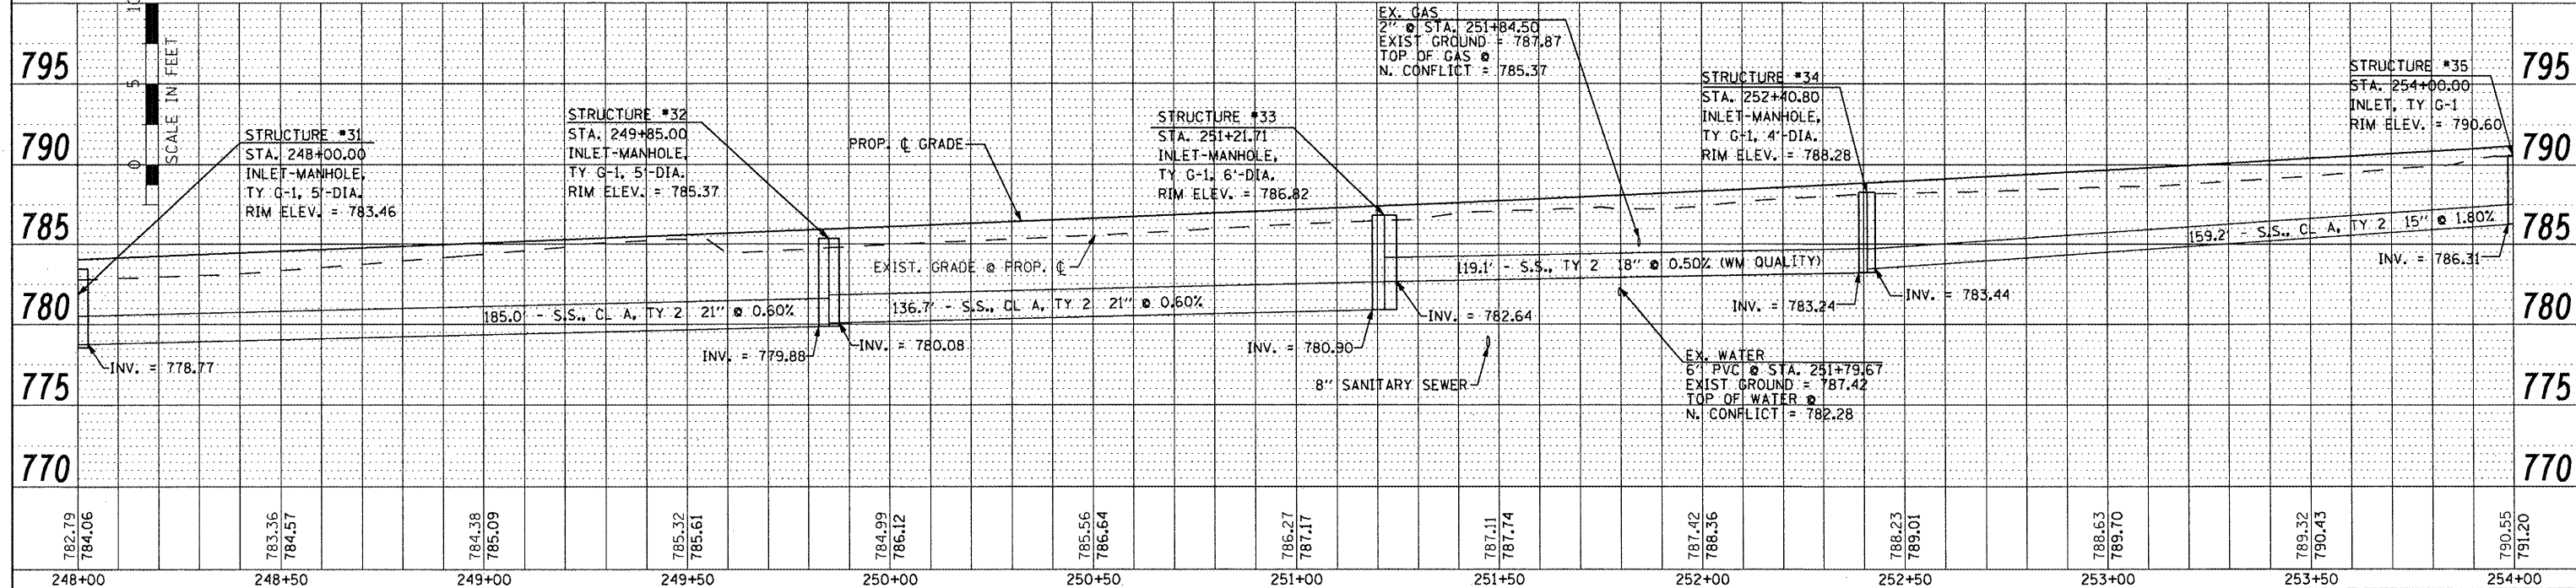


DATE	
BY	
REVIEWED	
PLANNED	
NOTED	
NOTED	
NO.	
NO.	
NO.	

DATE	
BY	
REVIEWED	
PLANNED	
NOTED	
NOTED	
NO.	
NO.	
NO.	

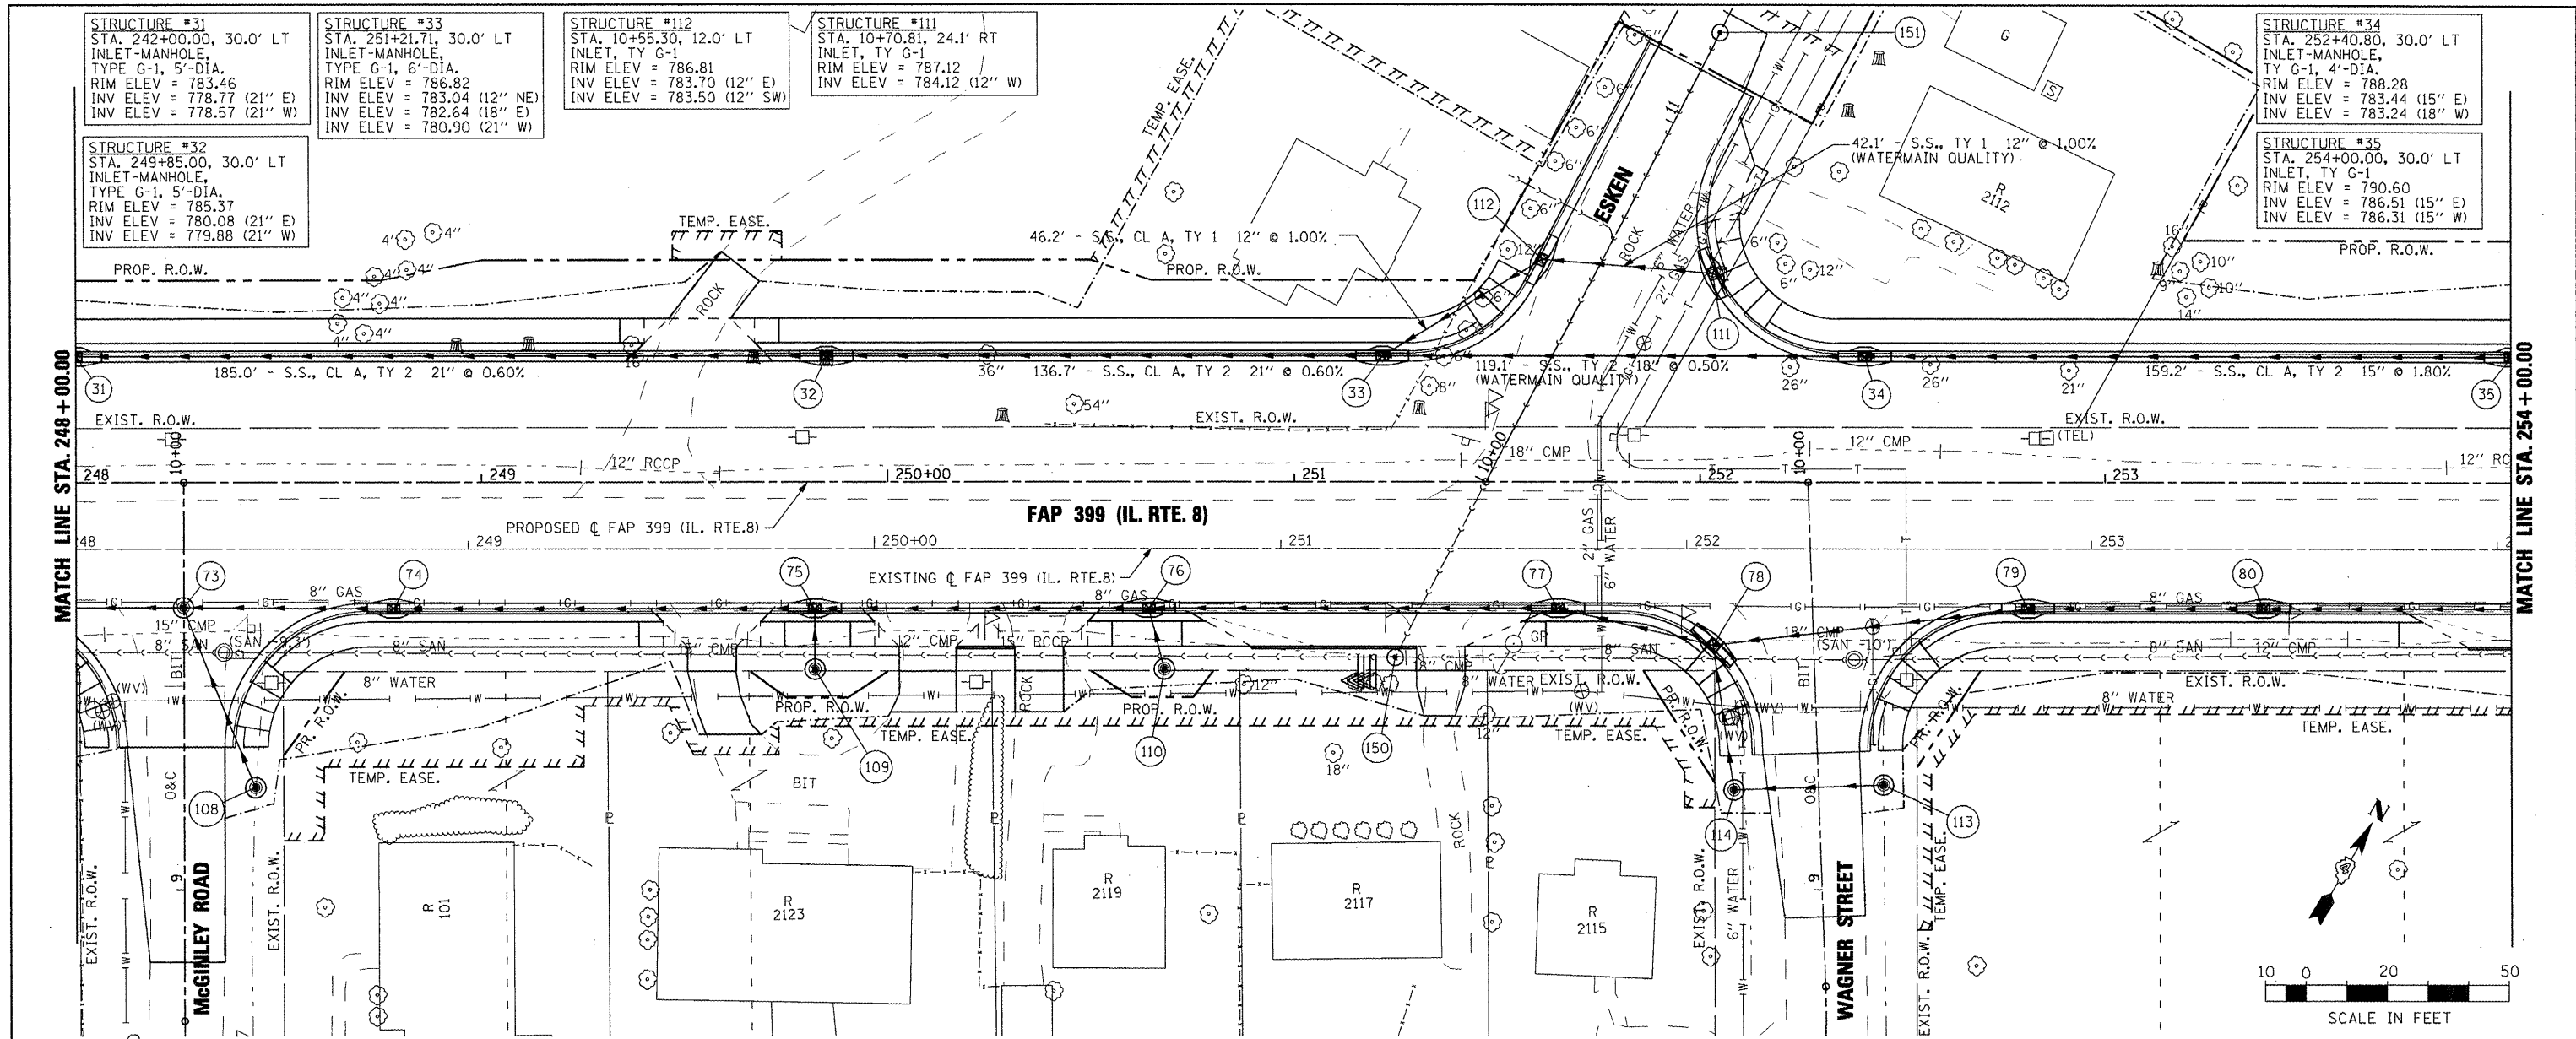

FILE NAME =	USER NAME = JDOT	DESIGNED -	REVISED -	STATE OF ILLINOIS DEPARTMENT OF TRANSPORTATION				FAP 399 (IL. RTE. 8) DRAINAGE PLAN AND PROFILE - NORTH				F.A. RTE. =	SECTION	COUNTY	TOTAL SHEETS	SHEET NO.
\\spprojects\200803566\dgn\14-Rte8-sh1-DRAIN-9-NORTH.dgn		DRAWN -	REVISED -	SCALE: AS SHOWN				SHEET NO. OF SHEETS				399	36 R-7	TAZEWELL	390	185
PLOT SCALE = 48.0000' / IN.		CHECKED -	REVISED -	STA. 248+00.00 TO STA. 254+00.00				CONTRACT NO. 68370				ILLINOIS FED. AID PROJECT				
PLOT DATE = 10/21/2011		DATE -	REVISED -													