
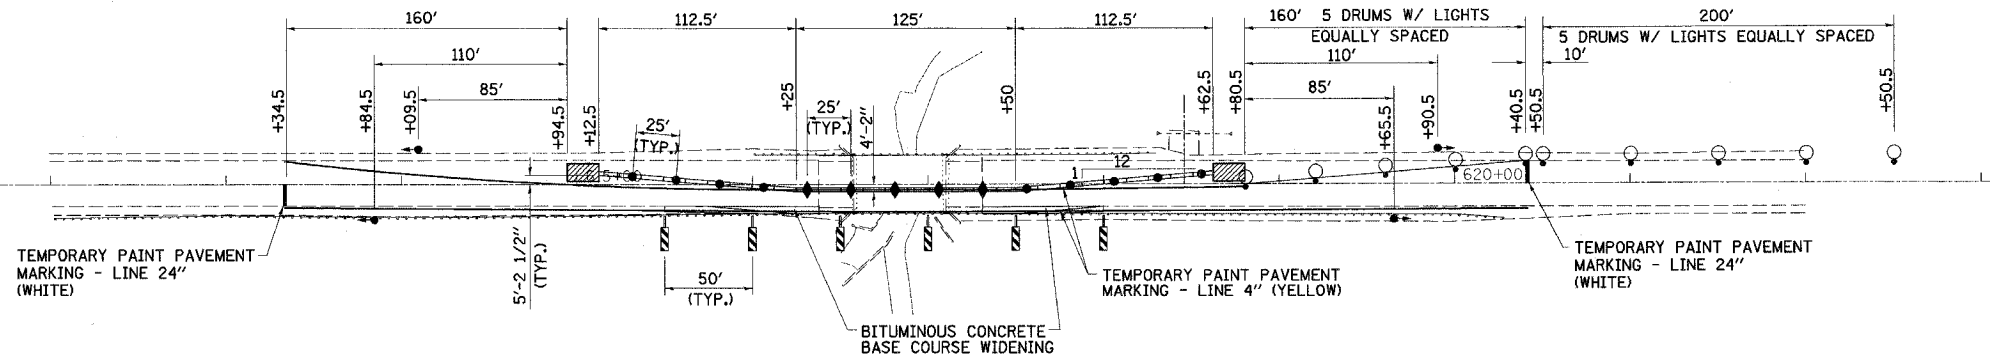



F.A.P. RTE.	SECTION	COUNTY	TOTAL SHEETS	SHEET NO.
840	136 BR-1	IROQUOIS	45	9
STA. 611+00		TO STA. 623+00		
FED. ROAD DIST. NO.		ILLINOIS FED. AID PROJECT		

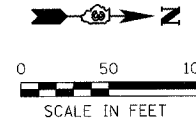

TRAFFIC CONTROL

**STAGE I
SEQUENCE OF OPERATIONS**


1. INSTALL TEMPORARY TRAFFIC SIGNALS, ATTENUATOR BASES, ATTENUATORS, TEMPORARY CONCRETE BARRIERS AND DRUMS WITH THE AID OF TRAFFIC CONTROL AND PROTECTION STANDARDS 701201 AND 701006. ALL OTHER ITEMS AS PER THESE DETAILS AND AS PER LANE CLOSURE 2L, 2W, BRIDGE REPAIR WITH BARRIER STANDARD 701321. BEGIN OPERATING UNDER STAGE 1 TRAFFIC CONDITIONS WITH THE AID OF TRAFFIC CONTROL AND PROTECTION STANDARDS 701201 AND 701006
2. CONSTRUCT AGGREGATE SHOULDERS, GUARDRAIL AND TRAFFIC BARRIER TERMINALS. REMOVE PORTION OF EXISTING STRUCTURE.
3. CONSTRUCT PORTION OF PROPOSED STRUCTURE, BITUMINOUS SHOULDERS, STEEL PLATE BEAM GUARD RAIL, TRAFFIC BARRIER TERMINALS, AND TEMPORARY RAMPS.

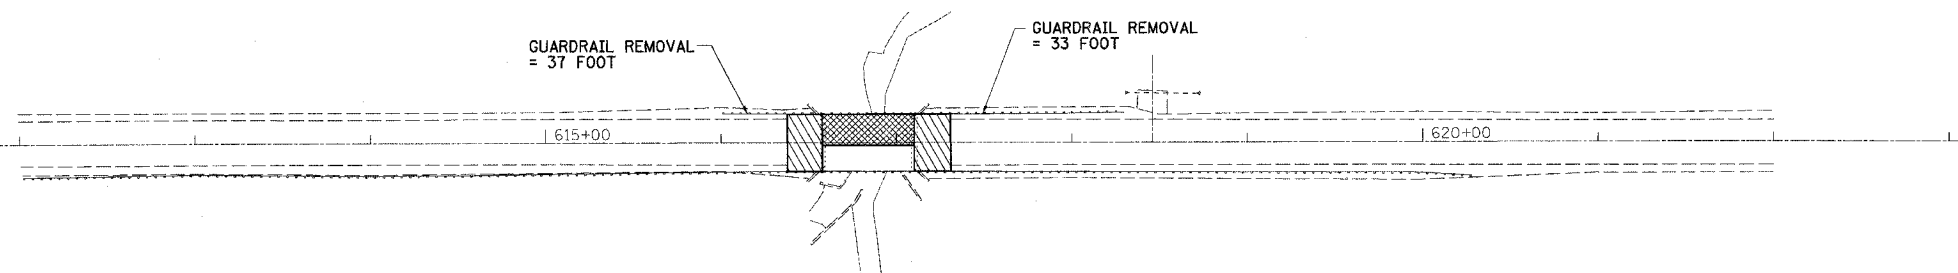

REMOVAL SCHEMATIC

LEGEND

- STRUCTURE REMOVAL
- BITUMINOUS SURFACE REMOVAL (VARIABLE DEPTH)
- IMPACT ATTENUATOR
- TYPE III BARRICADE WITH FLASHING LIGHTS
- EDGE DRUMS WITH STEADY BURNING LIGHTS
- TYPE C BIDIRECTIONAL REFLECTOR
- STEADY BURNING LIGHTS AND DOUBLE VERTICAL PANEL
- TRAFFIC SIGNALS
- STOP LINE 24"
- TEMPORARY CONCRETE BARRIER

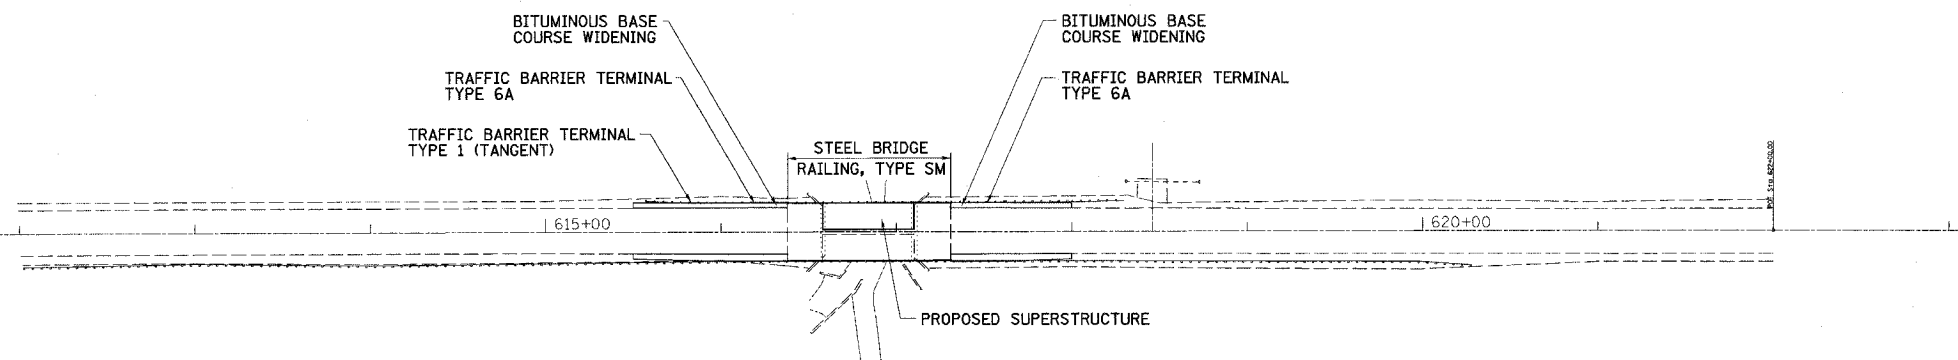

CONSTRUCTION SCHEMATIC

PLOT DATE = 12/21/2005
 FILE NAME = J:\63236\012\dr-orig\gr\A\SigM012.dgn
 PLOT SCALE = 50.0000 / IN.
 REFERENCE OPERATOR = michael

REVISIONS	
NAME	DATE

ILLINOIS DEPARTMENT OF TRANSPORTATION
STAGE 1 CONSTRUCTION

FAP RTE 840 (IL RTE 49)
 SECTION 136 BR-1
 IROQUOIS COUNTY

SCALE: VERT. _____
 HORIZ. _____
 DATE 10/31/05

DRAWN BY SUTHEARD
 CHECKED BY BOIT

GREENE & BRADFORD, INC.
 OF SPENGLERFIELD

COMPUTER FILE NO.
STGW012

PROJECT 03236 W012
 10/31/05 - MDS

STAGE 1 CONSTRUCTION