






FAU RTE	SECTION	COUNTY	TOTAL SHEETS	SHEET NO.
1447	03-00159-00-RS	COOK	24	16
F. HW. A. REG.	ILLINOIS	PROJECT STPM-8003(581)	CONTRACT NO. 83835	

IMPORTANT!
 FULL SIZE PLANS HAVE BEEN PREPARED USING STANDARD ENGINEERING SCALES. REDUCED SIZED PLANS WILL NOT CONFORM TO STANDARD SCALES INDICATED IN TITLE BLOCK.

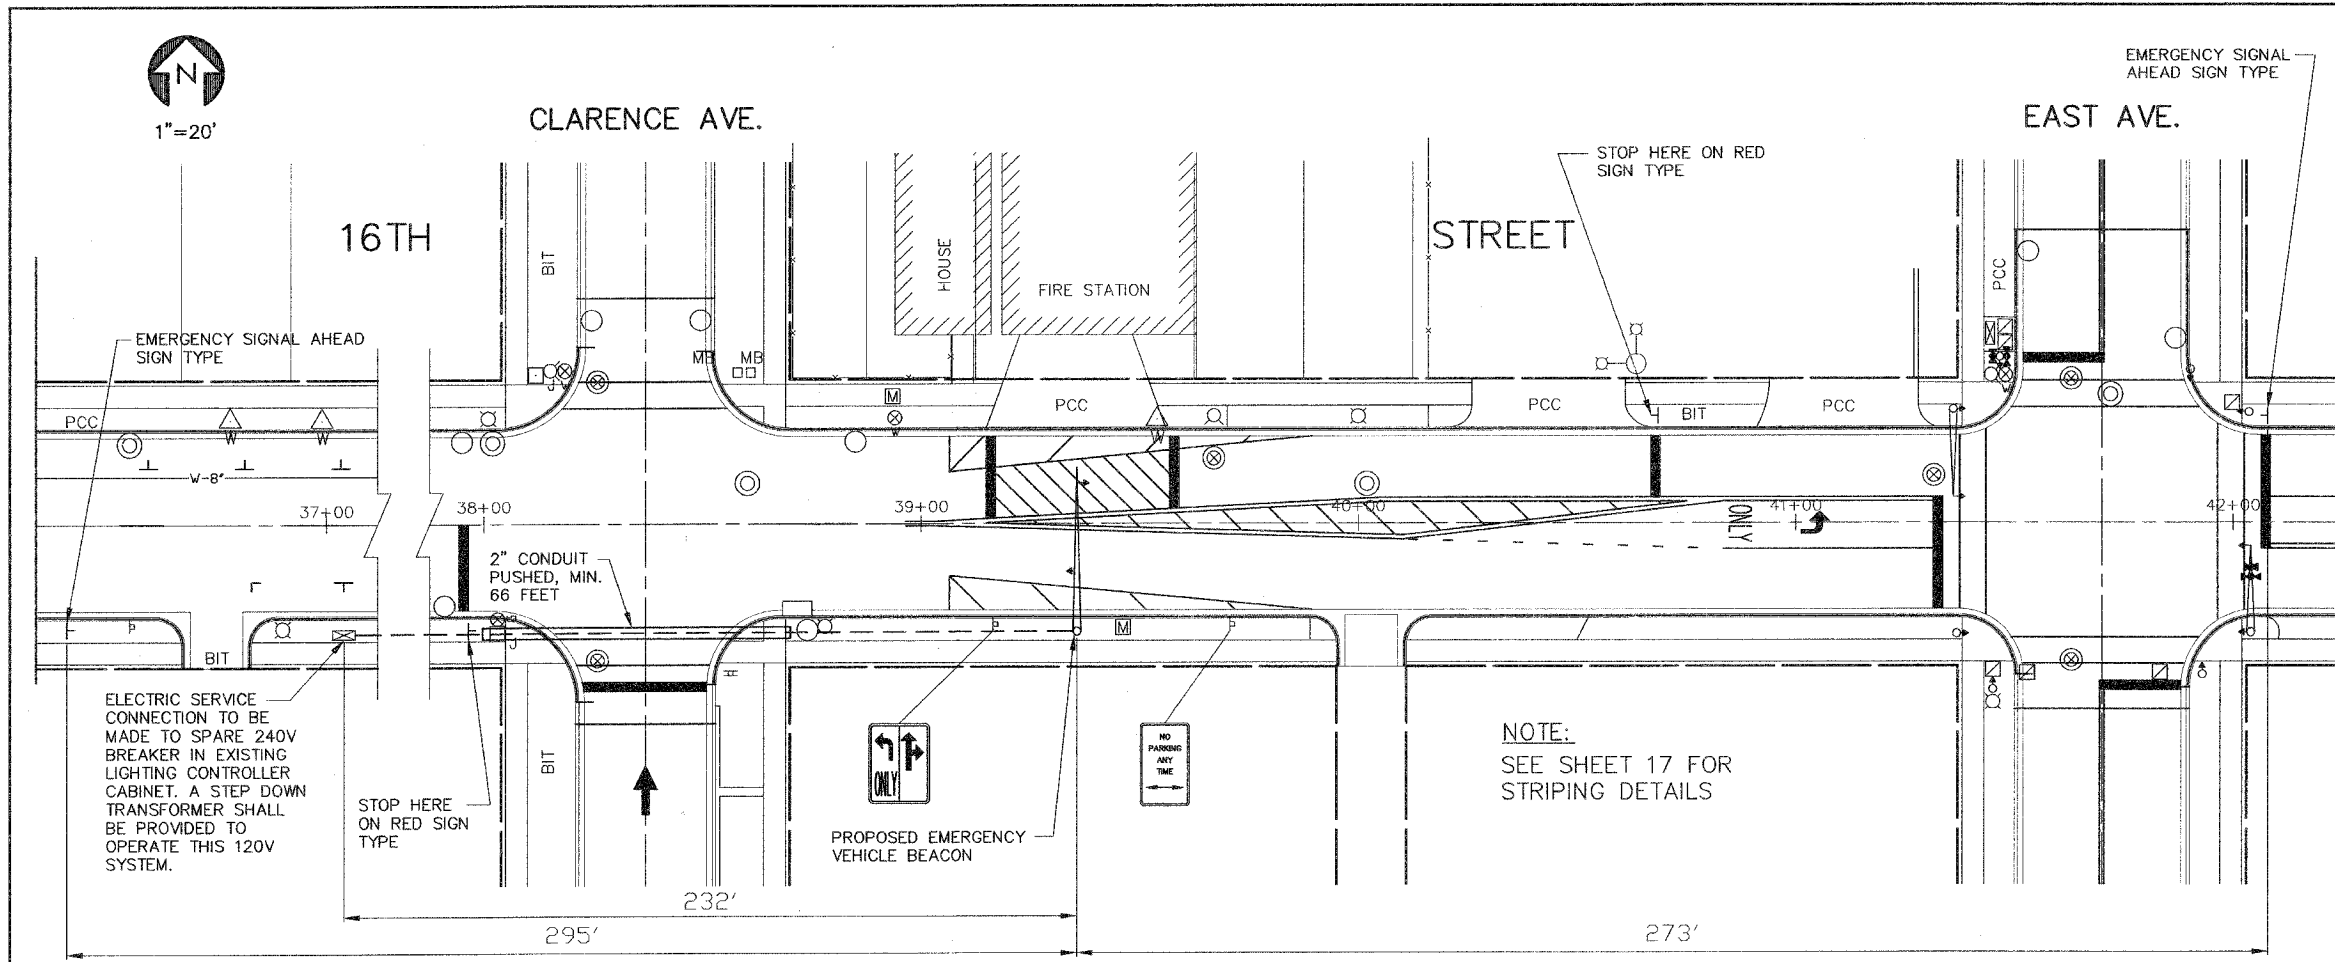

PHASE	A			
INTERVAL	1	2	3	4
16TH STREET EAST & WEST BOUND	FLASHING YELLOW (3sec) (RADIO SIGNAL ACTIVATED)	STEADY BURN YELLOW (5sec)	FLASHING RED (30sec)	OFF (RESET)

EMERGENCY SIGNAL SEQUENCE OF OPERATIONS

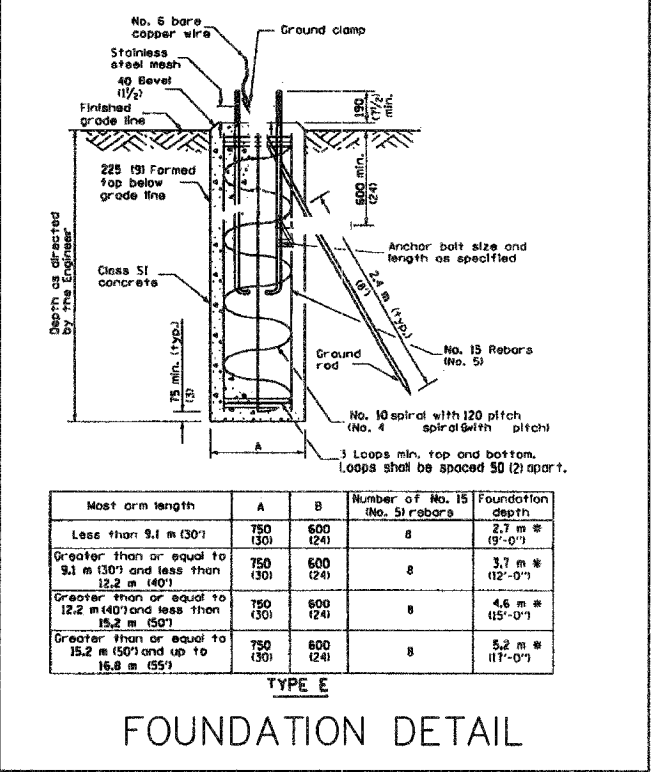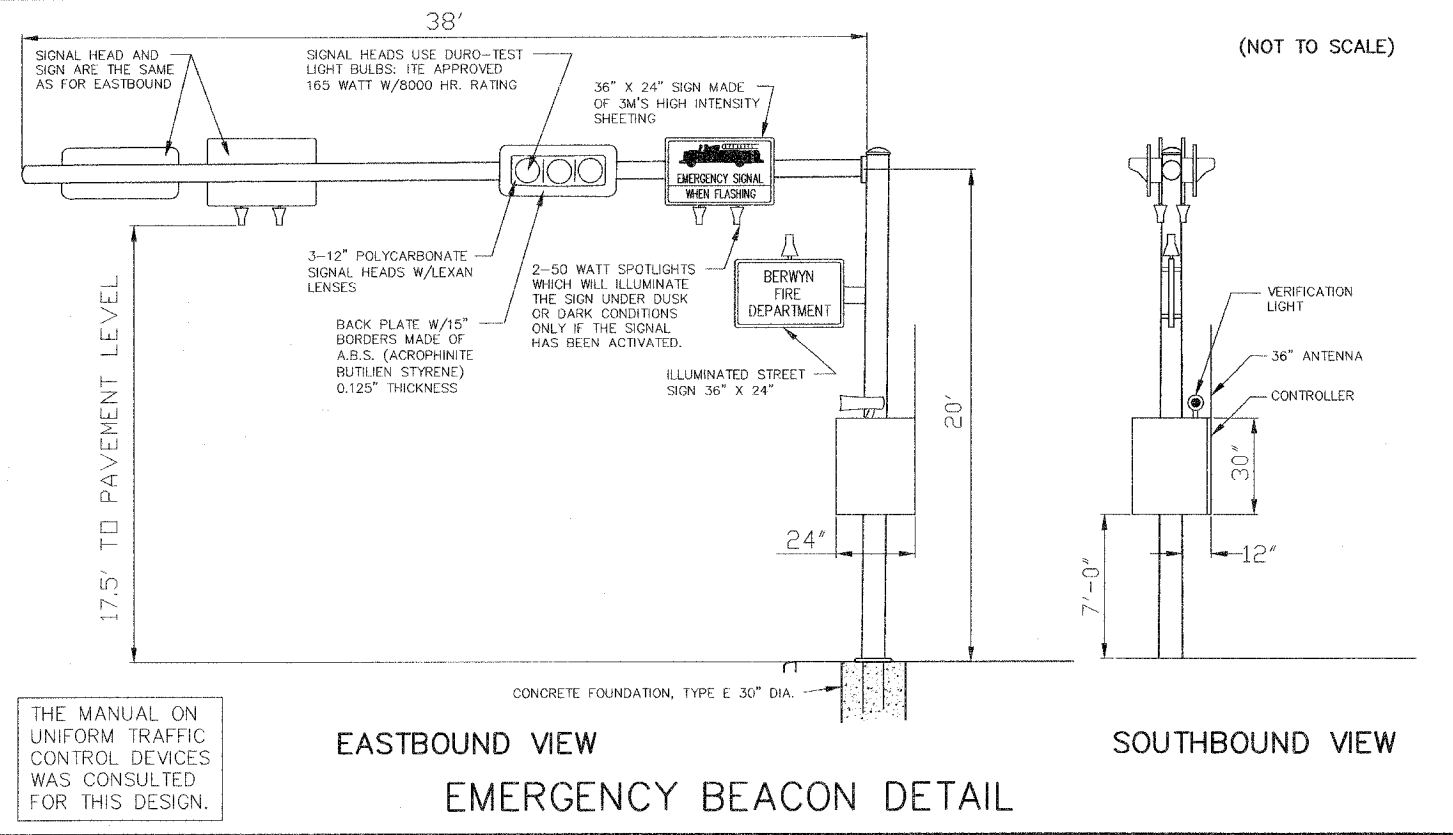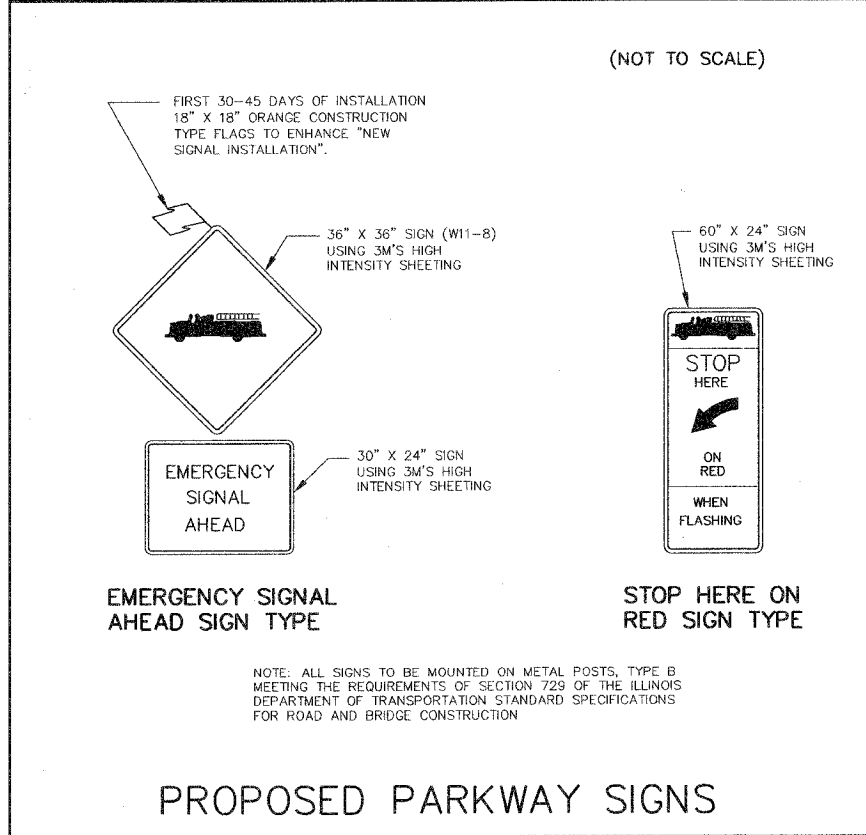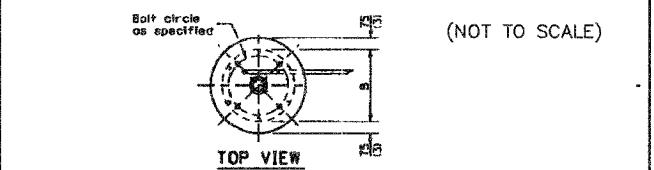

REVISIONS				
NO.	BY	DATE	DESCRIPTION	
1	THK	11/30/05	PER IDOT DIST. 1 B.L.R. COMMENTS	
2	THK	12/14/05	PER IDOT DIST. 1 B.L.R. COMMENTS	
3	THK	12/16/05	PER IDOT DIST. 1 B.L.R. COMMENTS	