


THE LOCATION, SIZE AND TYPE OF MATERIAL OF EXISTING UNDERGROUND UTILITIES INDICATED ON THE PLANS IS NOT REPRESENTED AS BEING ACCURATE, SUFFICIENT OR COMPLETE. IT SHALL BE THE CONTRACTOR'S RESPONSIBILITY TO DETERMINE THE ACTUAL LOCATION OF ALL SUCH FACILITIES, INCLUDING SERVICE CONNECTIONS TO UNDERGROUND UTILITIES. PRIOR TO CONSTRUCTION, THE CONTRACTOR SHALL NOTIFY THE UTILITY COMPANIES OF HIS OPERATIONAL PLANS AND SHALL OBTAIN FROM THE RESPECTIVE UTILITY COMPANIES DETAILED INFORMATION AND ASSISTANCE RELATIVE TO THE LOCATION OF THEIR FACILITIES AND THE WORKING SCHEDULE OF THE COMPANIES FOR REMOVAL OR ADJUSTMENT WHERE REQUIRED. IN THE EVENT AN UNEXPECTED UTILITY INTERFERENCE IS ENCOUNTERED DURING CONSTRUCTION, THE CONTRACTOR SHALL IMMEDIATELY NOTIFY THE UTILITY COMPANY OF JURISDICTION. THE ENGINEER SHALL ALSO BE IMMEDIATELY NOTIFIED. ANY SUCH MAINS AND SERVICES SHALL BE RESTORED TO SERVICE AT ONCE AND PAID FOR BY THE CONTRACTOR AT NO ADDITIONAL COST TO THE CONTRACT.


CALL J.U.L.I.E. FOR UTILITY INFORMATION AT 1-800-892-0123.

- LEGEND**
- EXISTING PAVEMENT
 - EXISTING BUILDINGS
 - EXISTING FENCE
 - EXISTING TELEPHONE LINE
 - EXISTING GAS LINE
 - EXISTING AIRFIELD LTG CABLES
 - EXISTING OVERHEAD ELECTRIC
 - EXISTING ELECTRICAL DUCT MARKERS
 - EXISTING GUY WIRE
 - EXISTING SEPTIC TANK
 - EXISTING ROTATING BEACON
 - EXISTING ELECTRICAL VAULT
 - EXISTING POWER POLE
 - EXISTING LIGHT POLE
 - EXISTING FIRE HYDRANT
 - EXISTING WATER VALVE
 - PROPOSED ELECTRICAL VAULT
 - PROPOSED ELECTRICAL HANDHOLE
 - PROPOSED ELECTRICAL CABLE IN CONDUIT. SEE PLAN FOR SIZE & TYPE (INCIDENTAL TO AR109200).
 - 4/C #6 XLP-USE 600V UG CABLE IN UD

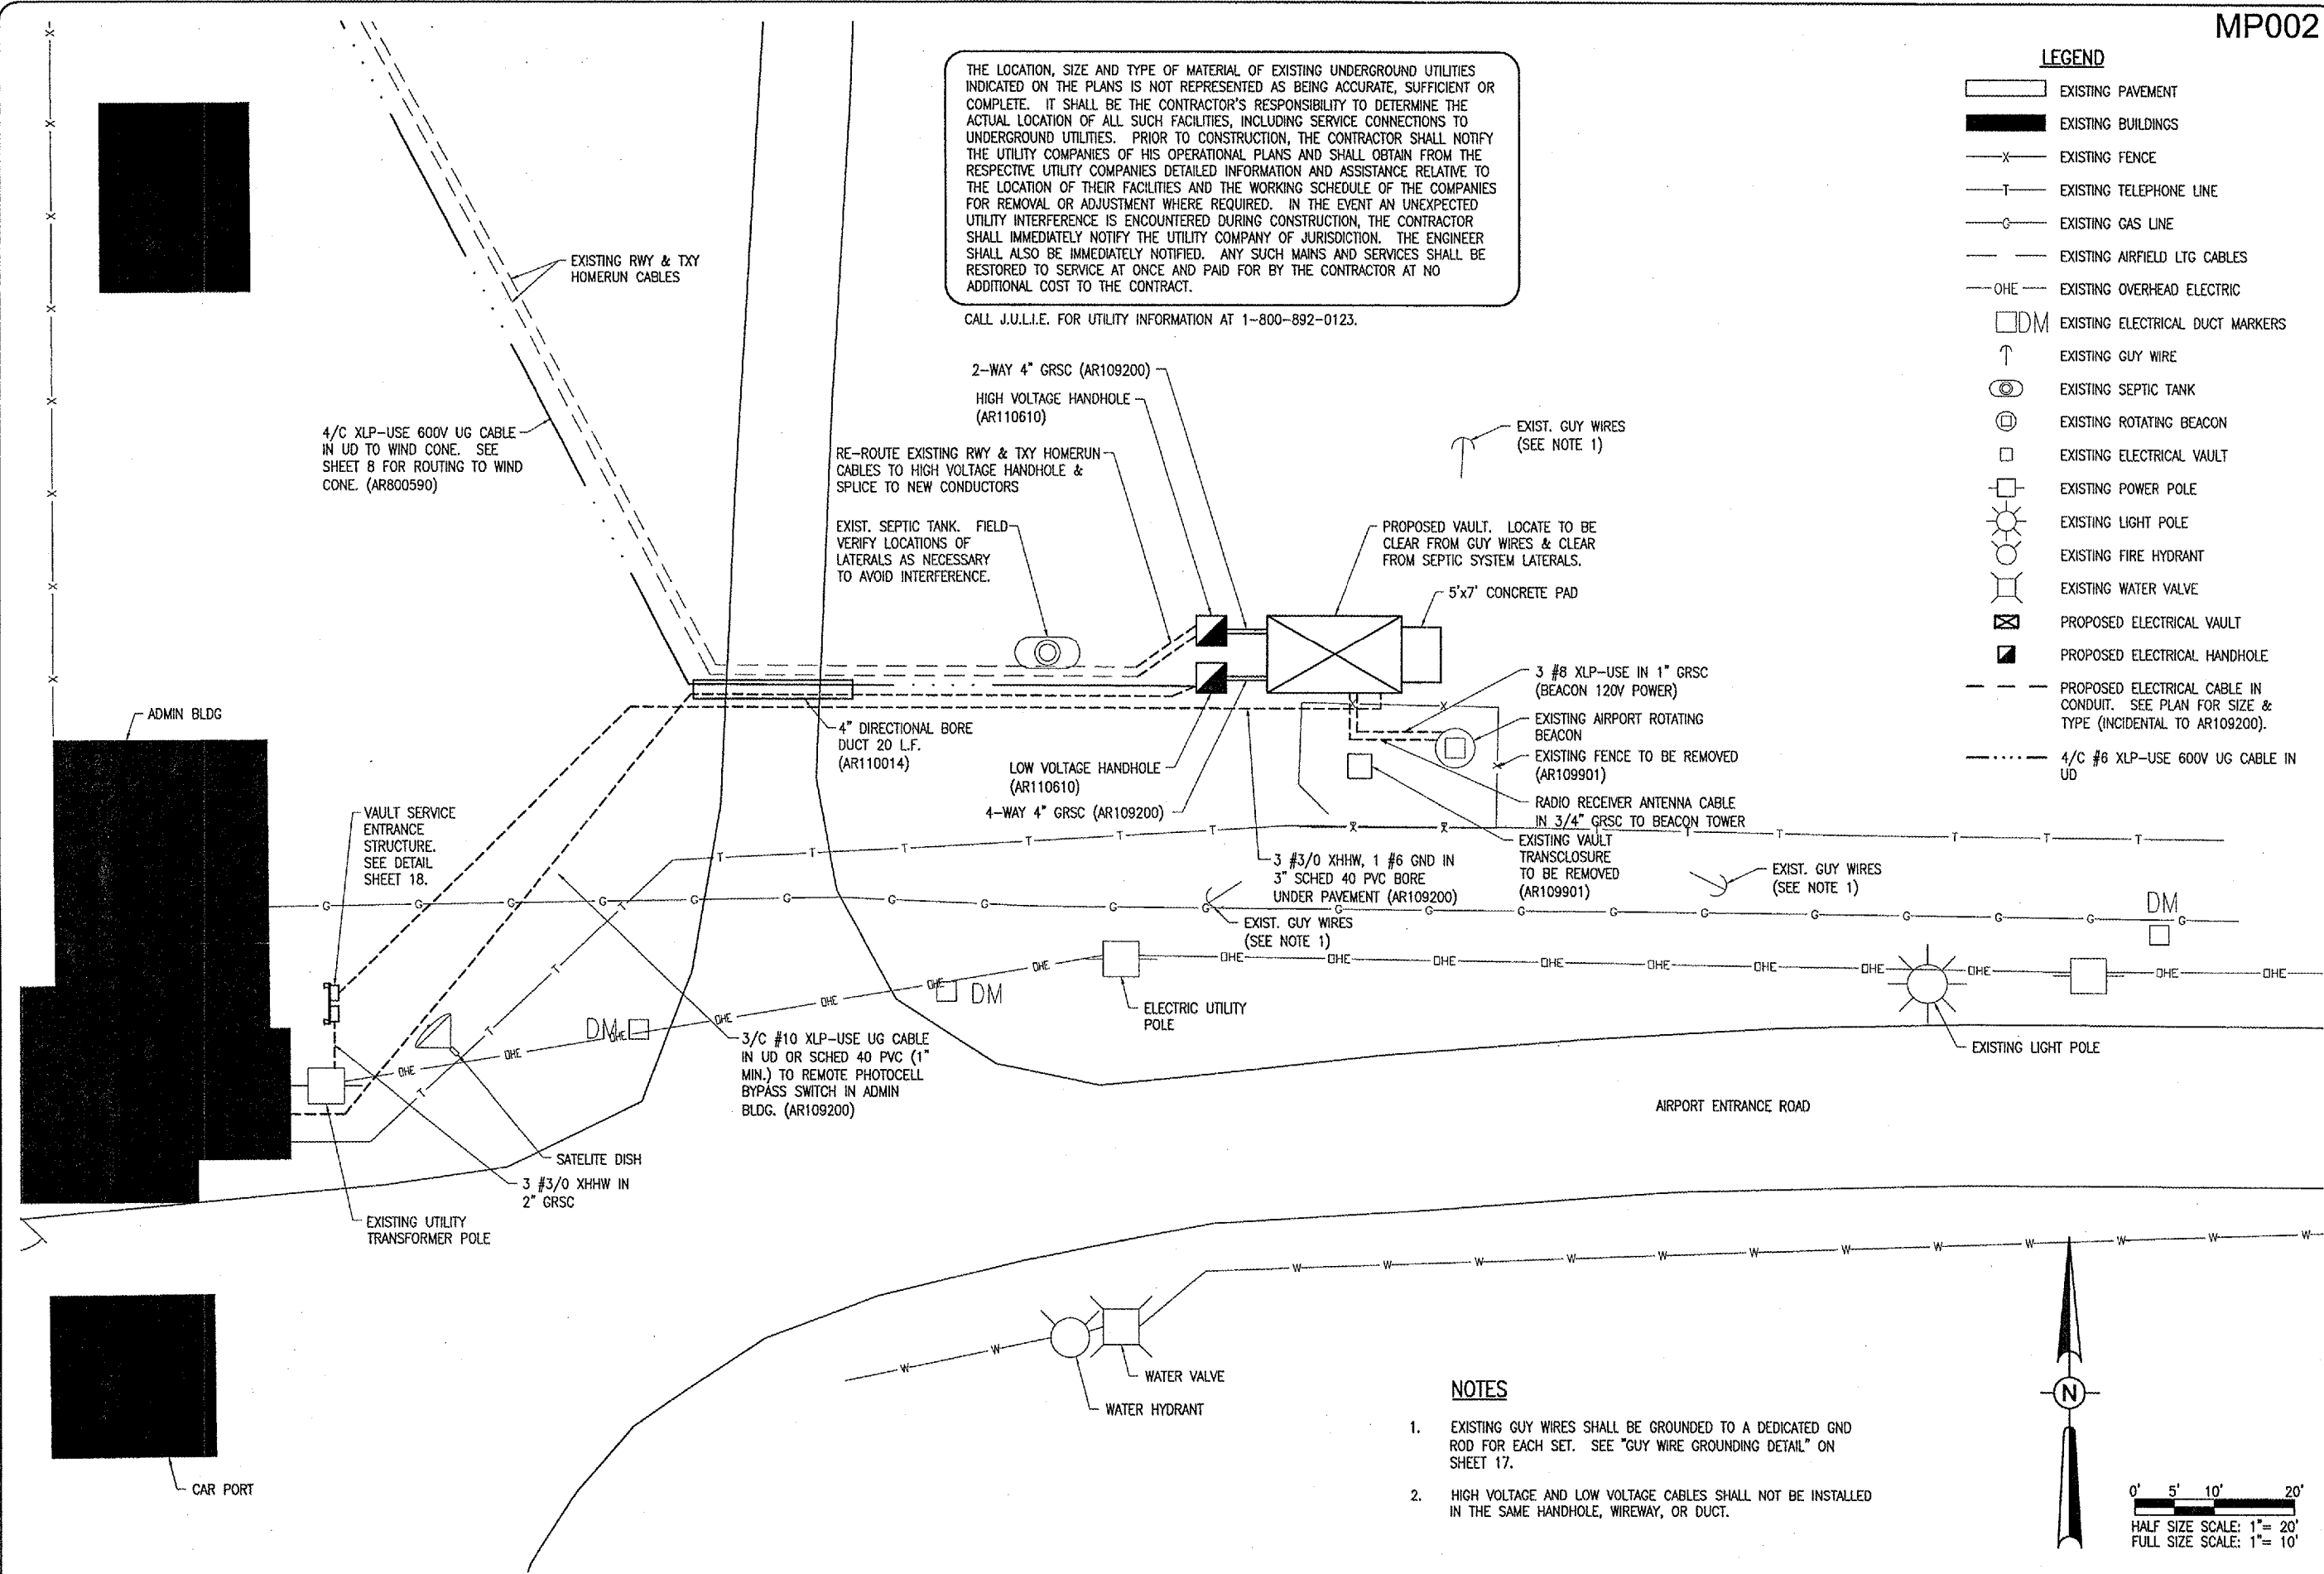

NOTES

1. EXISTING GUY WIRES SHALL BE GROUNDED TO A DEDICATED GND ROD FOR EACH SET. SEE "GUY WIRE GROUNDED DETAIL" ON SHEET 17.
2. HIGH VOLTAGE AND LOW VOLTAGE CABLES SHALL NOT BE INSTALLED IN THE SAME HANDHOLE, WIREWAY, OR DUCT.

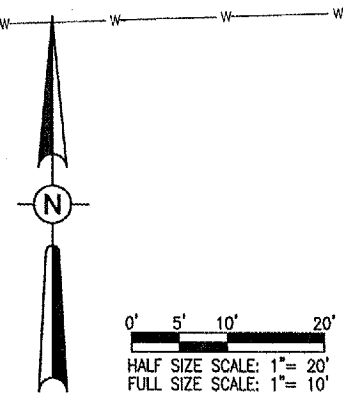

JAN 12, 2006 1:35 PM CAH
I:\AIRPORTS\METROPOLIS\B18-OBVLT\AIRPORT\SHEETS\R-102_SIT.DWG -- PROP. SITE

DATE	REVISION	BY	METROPOLIS MUNICIPAL AIRPORT METROPOLIS, ILLINOIS	A.I.P. PROJ.: 3-17-0067-BB I.L. PROJ.: M30-3541
I.E. Project No. 816-06/UTD-0800 File Name: R-102_SIT.DWG Scale: 1"=10' Date: 11/15/05		MDR 11/15/05 MDR 11/15/05 CAH 12/16/05	 Hanson Professional Services Inc. 1525 South State Street Springfield, Illinois 62703-2886 Offices Nationwide	
CONSTRUCT NEW VAULT		PROPOSED AIRPORT VAULT SITE PLAN	7	
7 of 22 sheets				