
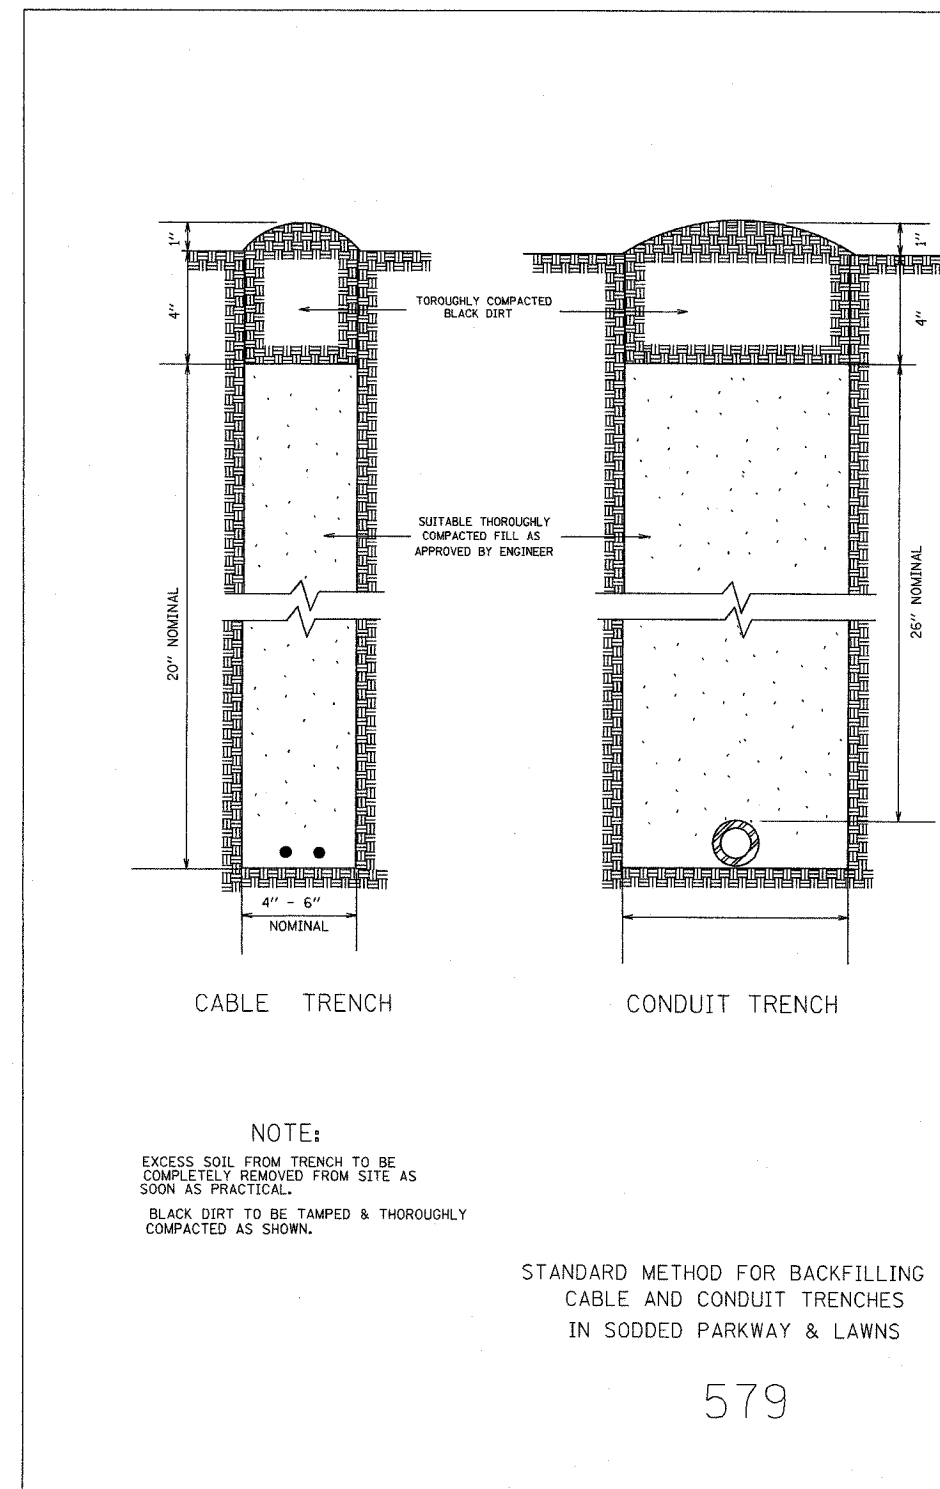


FAI RTE.	SECTION	COUNTY	TOTAL SHEETS	SHEET NO.
90	1314B	COOK	160	75
FED. ROAD DIST. NO.		ILLINOIS FED. AID PROJECT		

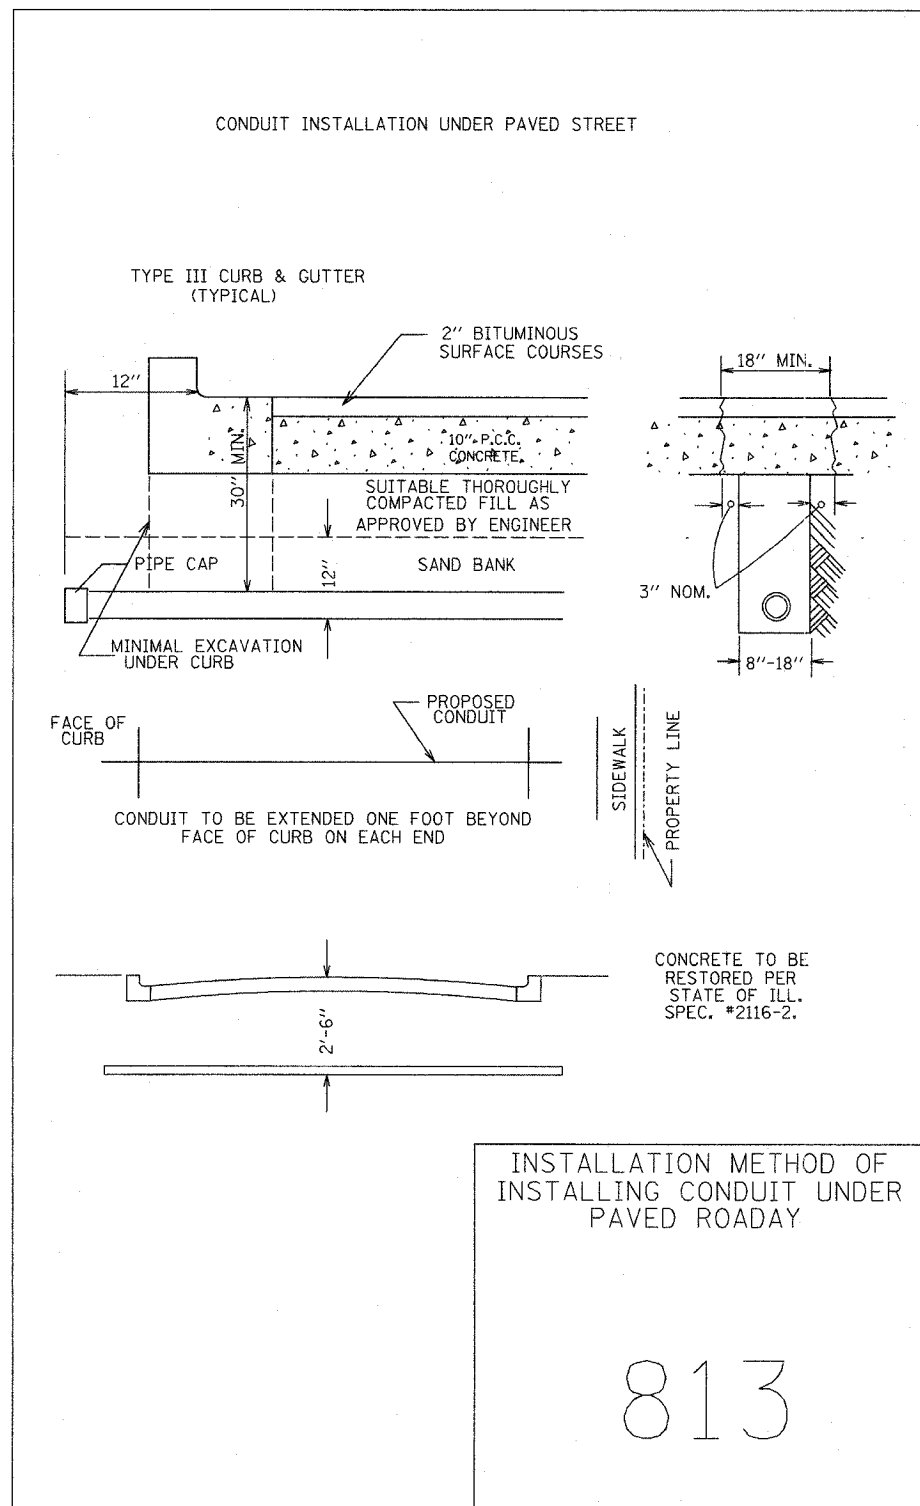

G:\PROJECTS\JOB268\LTG\NAGLE\E12.DGN

REVISIONS		ILLINOIS DEPARTMENT OF TRANSPORTATION NAGLE AVE. OVER FAI-90 (KENNEDY EXPY) CITY OF CHICAGO
NAME	DATE	
		MISCELLANEOUS ELECTRICAL DETAILS
SCALE: NONE		DRAWN BY: CBR
DATE: DEC 2004		CHECKED BY: SM