
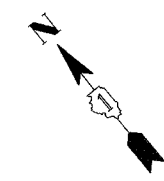


F.A. RTE.	SECTION	COUNTY	TOTAL SHEETS	SHEET NO.
337	19R-1	LAKE	800	521
STA.		TO STA.		
FED. ROAD DIST. NO.	ILLINOIS	FED. AID PROJECT		

CONTRACT NO. 60997

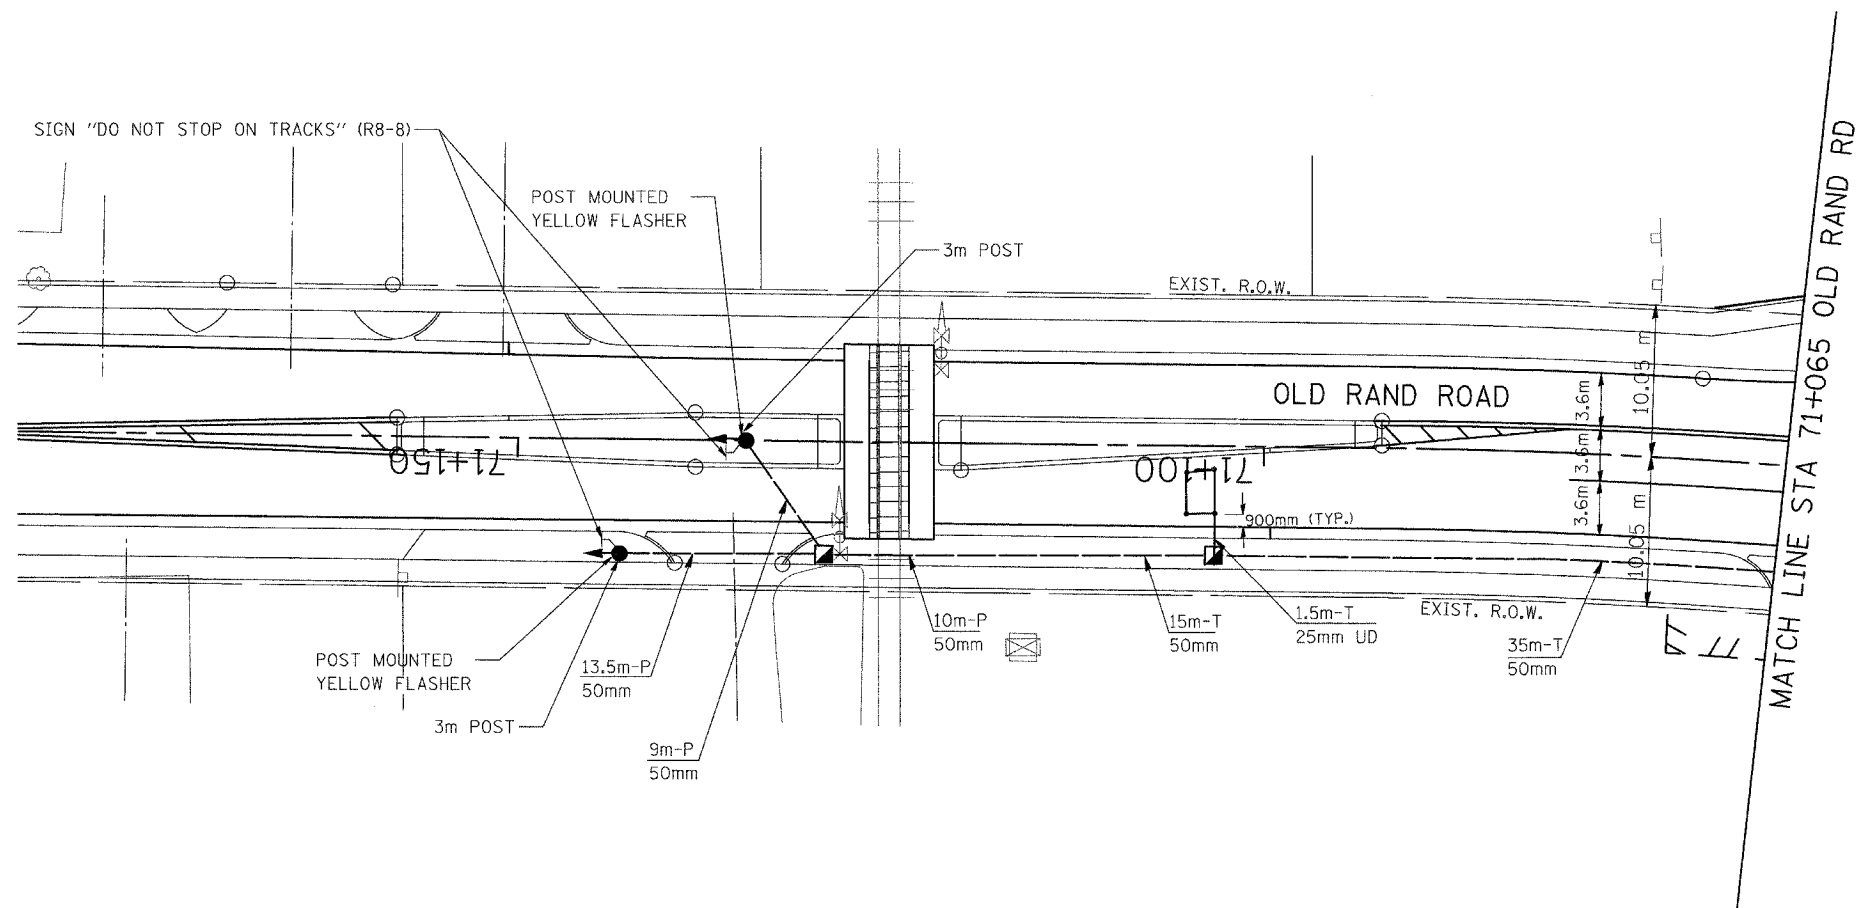

SEQUENCE OF OPERATION

SB OLD RAND RD PHASE INDICATION	GREEN	YELLOW	RED	FLASH
FLASHER INDICATION	DARK	FLASH YELLOW	FLASH YELLOW	FLASH YELLOW

REVISIONS	
NAME	DATE

ILLINOIS DEPARTMENT OF TRANSPORTATION
TRAFFIC SIGNAL INSTALLATION PLAN
IL RTE 22 & OLD RAND ROAD

SCALE : 1:250
DATE : 07/21/04
DRAWN BY VAP
DESIGNED BY RAM
CHECKED BY DDL