

F.A.I. RTE.	SECTION	COUNTY	TOTAL SHEETS	SHEET NO.
55	2002-022 K	WILL	172	48
STA. 10+00		TO STA. 22+96.05		
FED. ROAD DIST. NO.		ILLINOIS FED. AID PROJECT		
CONTRACT NO. 62389				

I-55 NORTHBOUND ENTRANCE RAMP A STA 300+00 = ILLINOIS ROUTE 53 STA 1458+53

I-55 NORTHBOUND EXIT RAMP D STA. 112+46 = ILLINOIS ROUTE 53 STA 1458+31

70 STA 110+84.65, 34.85'RT (RAMP D)  
CB TA 4 DIA T24 F&G  
ELEV. 700.10  
INV. 695.51 S (Ex.)

71 STA 111+10.09, 24'LT (RAMP D)  
CB TA 4 DIA T24 F&G  
ELEV. 701.05  
INV. 696.21 NE (Ex.)

75 STA 301+45.8, 68.25'LT (RAMP A)  
MAN TA 4 DIA T1F CL  
ELEV. 698.67  
INV. 693.89 E & W (Ex.)  
INV. 694.67 S

72 STA 111+19.80, 62.93'LT (RAMP D)  
INLETS TA T24 F&G  
ELEV. 701.50  
INV. 697.50 SE

SS CLASS A, TY. 1, 12"  
74 FT.  
SS CLASS A, TY. 1, 15"  
5 FT.

73 STA 301+08.30, 39.28'RT (RAMP A)  
CB TA 4 DIA T24F&G  
ELEV. 700.59  
INV. 694.27 NW & SE (Ex.)  
INV. 696.59 NE & SW


SS CLASS A, TY. 1, 12"  
28 FT.

76 STA 301+35.05, 34.75'RT (RAMP A)  
INLETS TA T24F&G  
ELEV. 700.74  
INV. 696.74 SW

77 STA 301+53.83, 28.20'LT (RAMP A)  
INLETS TA T24F&G  
ELEV. 700.16  
INV. 695.22 N (Ex.)


74 STA 301+34.25, 31.85'LT (RAMP A)  
CB TA 4 DIA T24F&G  
ELEV. 700.20  
INV. 696.20 N

SS CLASS A, TY. 1, 12"  
39 FT.

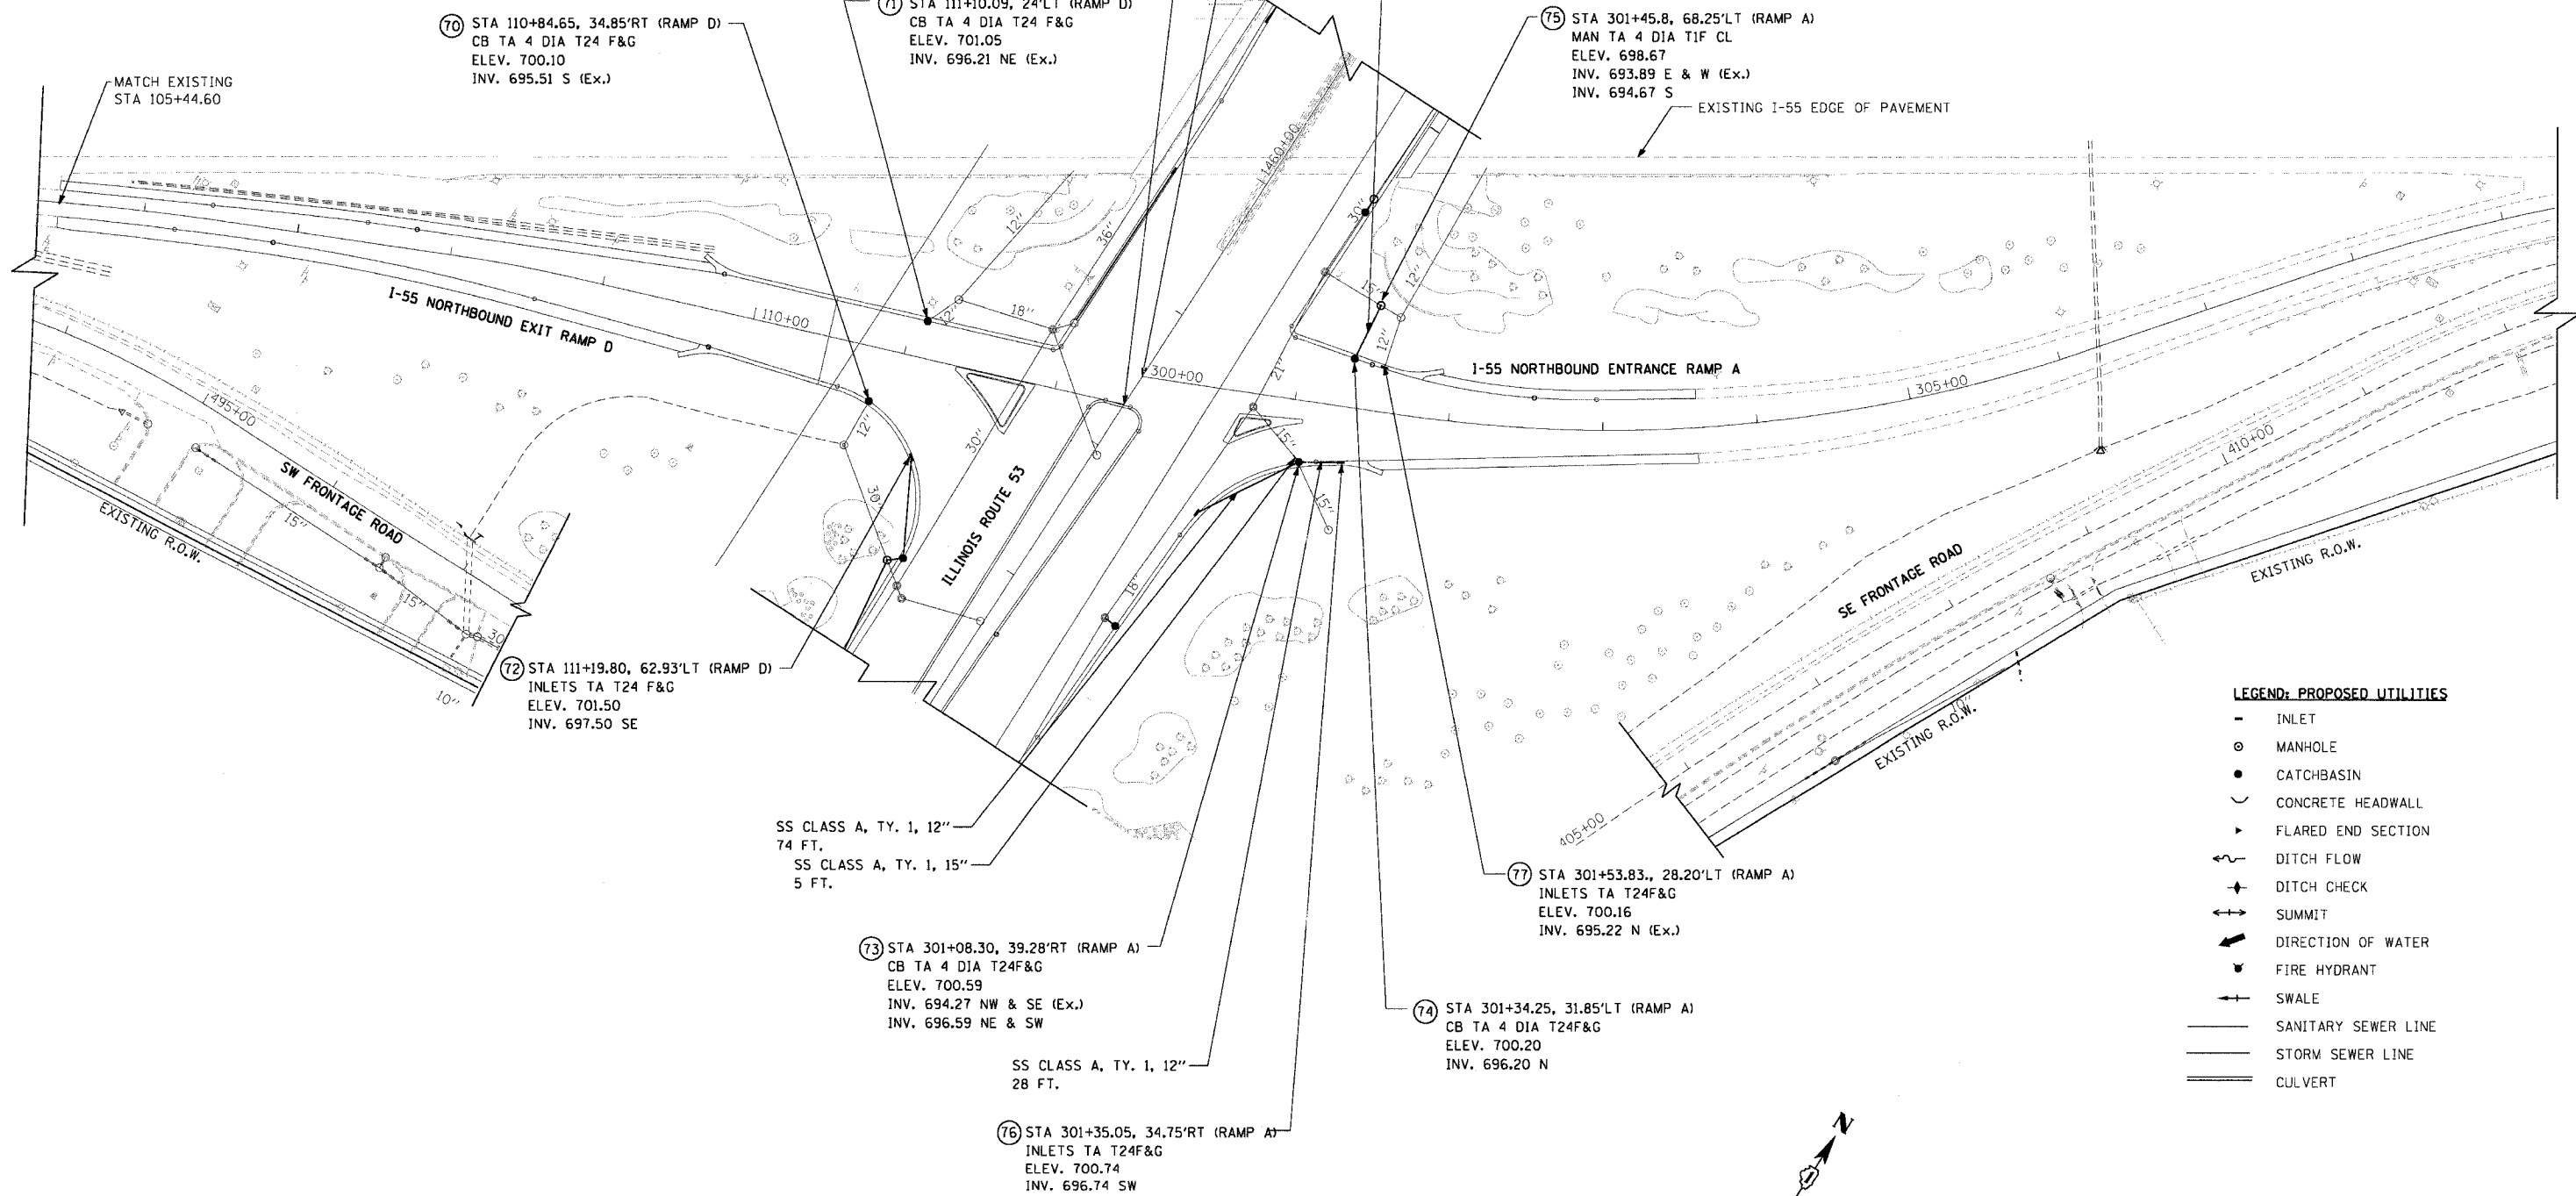

**LEGEND: PROPOSED UTILITIES**

- INLET
- MANHOLE
- CATCHBASIN
- ∩ CONCRETE HEADWALL
- ▶ FLARED END SECTION
- ~ DITCH FLOW
- ⊕ DITCH CHECK
- ↔ SUMMIT
- ➔ DIRECTION OF WATER
- ⦿ FIRE HYDRANT
- SWALE
- SANITARY SEWER LINE
- STORM SEWER LINE
- CULVERT

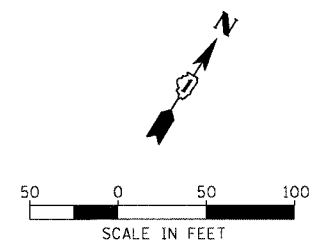

REVISIONS	
NAME	DATE

ILLINOIS DEPARTMENT OF TRANSPORTATION  
 PROPOSED DRAINAGE PLAN  
 I-55 NORTHBOUND EXIT RAMP D  
 STA 105+45 TO STA 111+85  
 I-55 NORTHBOUND ENTRANCE RAMP A  
 STA 301+57 TO STA 303+61  
 SCALE: 1"=50'  
 DATE: 11/8/2004  
 DRAWN BY: CC  
 CHECKED BY: RI

**DMJM HARRIS**  
 303 East Wacker Drive, Suite 600  
 Chicago, Illinois, 60601 Phone: 312.321.6101 Fax: 312.396.2392

PLAN	REVISIONS	DATE
NO.	NO.	NO.

PROFILE	REVISIONS	DATE
NO.	NO.	NO.