
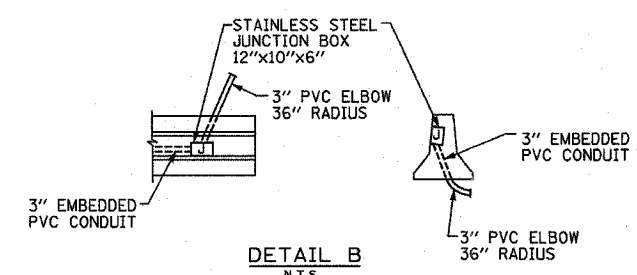
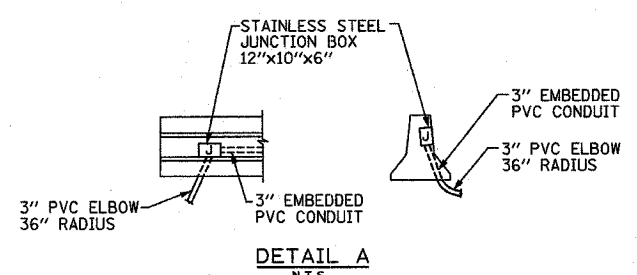


F.A.I. RTE.	SECTION	COUNTY	TOTAL SHEETS	SHEET NO.
55	2002-022 K	WILL	172	73
STA.	TO STA.			
FED. ROAD DIST. NO.	ILLINOIS	FED. AID PROJECT		
CONTRACT # 62389				

PLAN	SURVEYED	DATE
NOTE BOOK	ALIGNED	BY
NO.	INT. OF WAY CHECKED	
	PAID FILE NAME	

PROFILE	SURVEYED	DATE
NOTE BOOK	GRADES CHECKED	BY
NO.	S.L. NOTED	
	STRUCTURE NOTATIONS CHECKED	

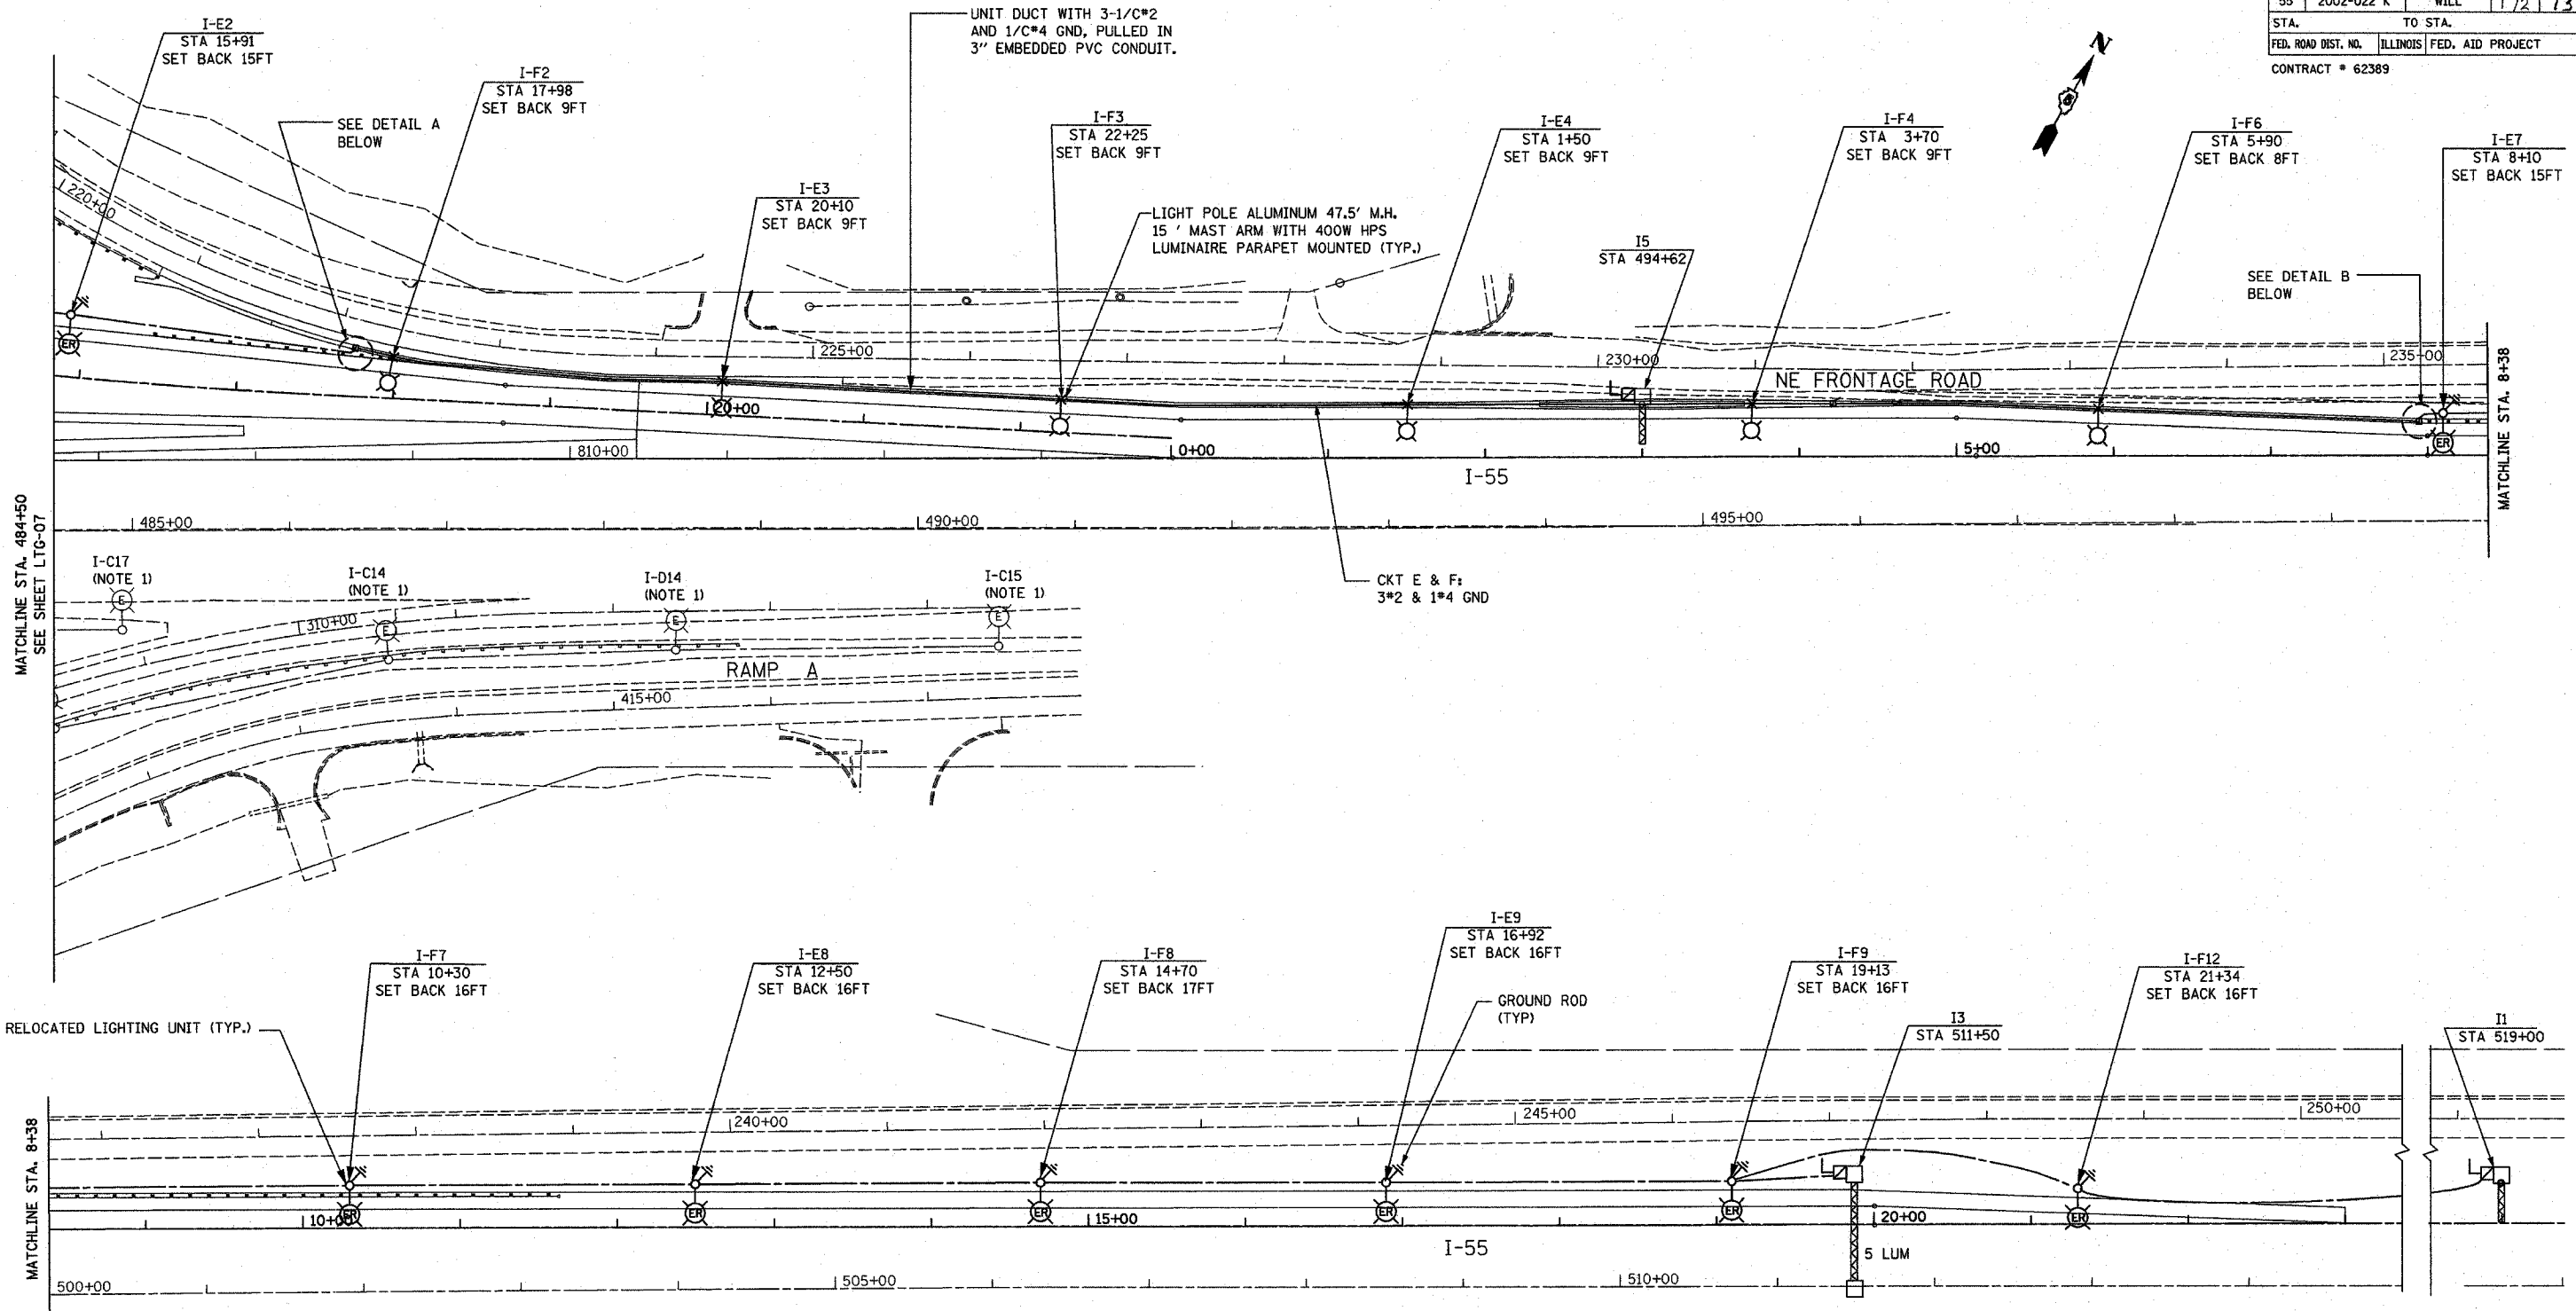

REVISIONS	
NAME	DATE

ILLINOIS DEPARTMENT OF TRANSPORTATION

**PROPOSED LIGHTING PLAN**

SCALE: 1"=50'

DATE: OCTOBER 25, 2004

DRAWN BY: SM  
DESIGNED BY: SM  
CHECKED BY: SM

