

 
 




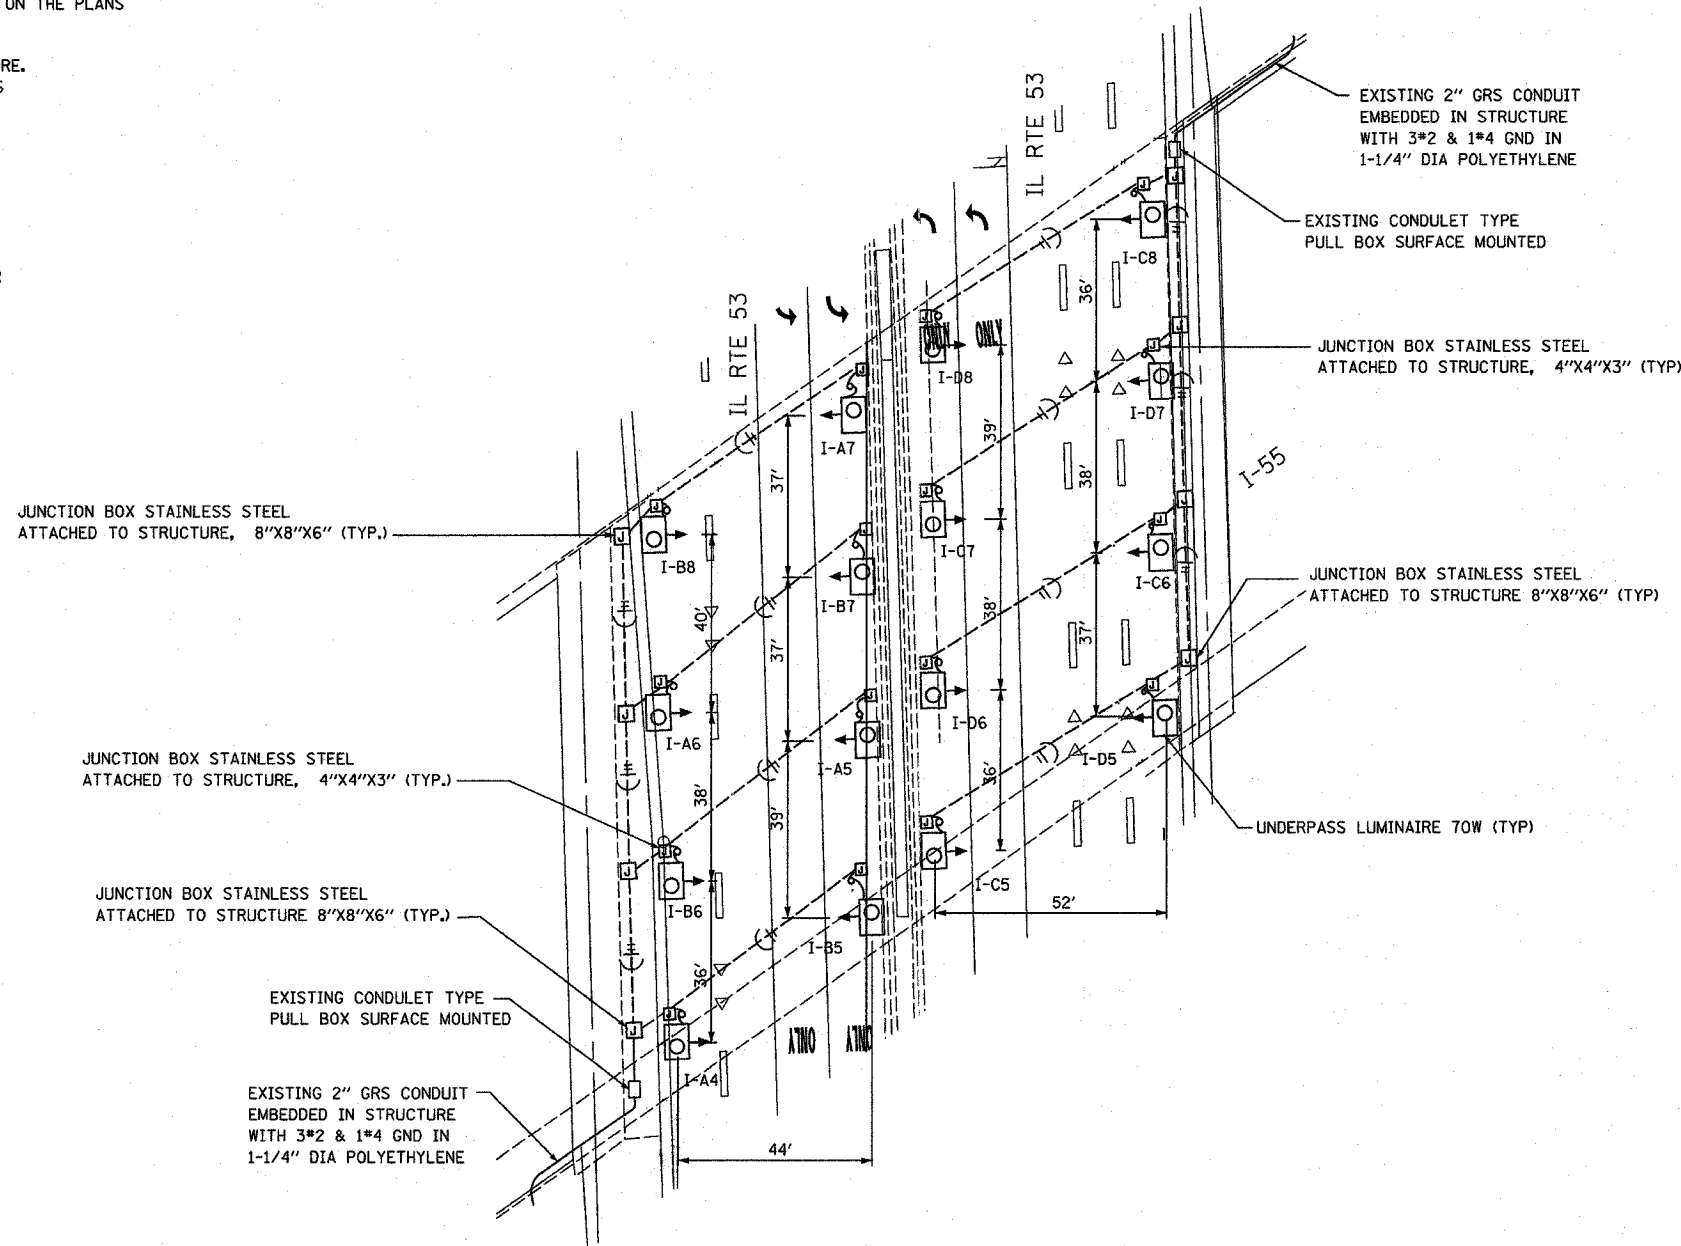
F.A.I. RTE.	SECTION	COUNTY	TOTAL SHEETS	SHEET NO.
55	2002-022 K	WILL	172	74
STA.		TO STA.		
FED. ROAD DIST. NO.	ILLINOIS	FED. AID PROJECT		
CONTRACT # 62389				

LEGEND

-  UNDERPASS LUMINAIRE 70W HPS
-  JUNCTION BOX STAINLESS STEEL ATTACHED TO STRUCTURE. SIZE INDICATED ON THE PLANS
-  CONDUIT ATTACHED TO STRUCTURE. 1" DIA RGS PVC COATED UNLESS NOTED OTHERWISE
-  DENOTES PHASE CONDUCTORS (#10 AWG MIN)
-  DENOTES NEUTRAL CONDUCTOR
-  DENOTES GROUND CONDUCTOR

PLAN	SURVEYED	DATE
NO.	BY	
	CHECKED	
	DATE	
	BY	
	CHECKED	
	DATE	

PROFILE	SURVEYED	DATE
NO.	BY	
	CHECKED	
	DATE	
	BY	
	CHECKED	
	DATE	



LTC-09

REVISIONS	
NAME	DATE

ILLINOIS DEPARTMENT OF TRANSPORTATION

UNDERPASS LIGHTING PLAN

K&E KAM ENGINEERING, INC.
CONSULTING ENGINEERS
707A Davis Road, Suite 205
Eggs, Illinois 60623-5283

SCALE: 1"=20'
DATE: OCTOBER 25, 2004
DRAWN BY: SM
DESIGNED BY: SM
CHECKED BY: SM