
 
 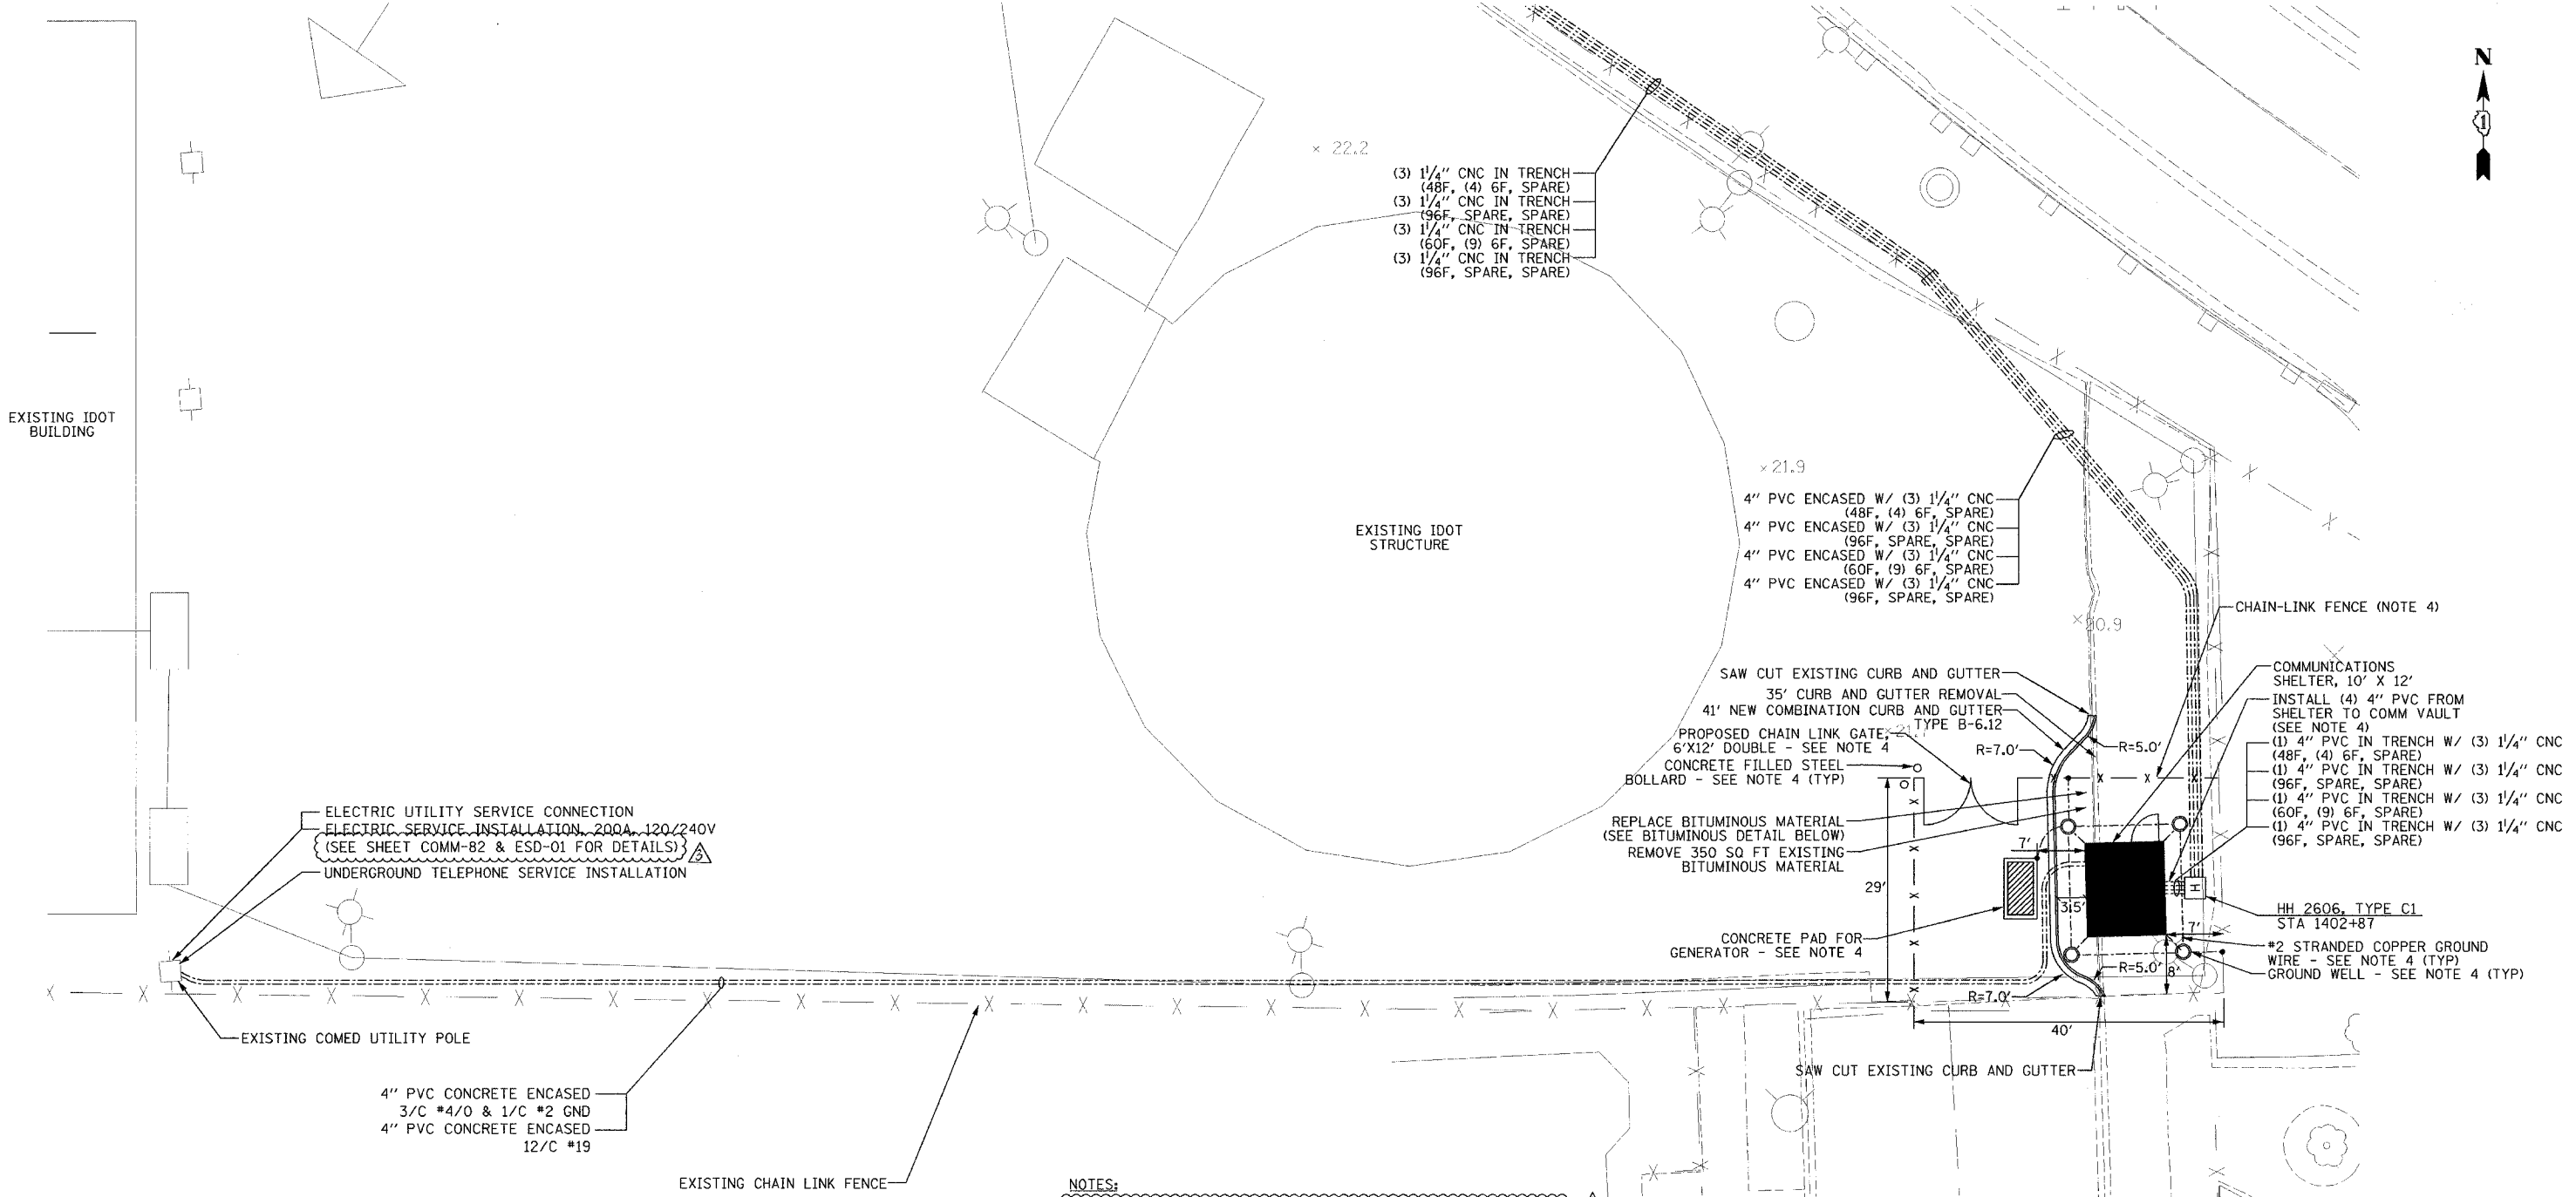


SECTION	COUNTY	TOTAL SHEETS	SHEET NO.
2003-0311	COOK	976	846
STA.	TO STA.		
FED. ROAD DIST. No. ILLINOIS	FED. AID PROJECT		
	62583		



- NOTES:**
1. FOR COMMUNICATIONS SHELTER DETAILS, REFER TO SHEETS COMM-91 THRU COMM-94.
  2. CONTRACTOR IS RESPONSIBLE FOR IDENTIFYING AND RELOCATING ALL EXISTING UNDERGROUND UTILITIES AS NECESSARY TO CONSTRUCT THE COMMUNICATIONS SHELTER.
  3. CONTRACTOR SHALL COORDINATE WITH IDOT MAINTENANCE YARD PERSONNEL WHEN RELOCATING EXISTING EQUIPMENT AT SHELTER SITE.
  4. DESIGNATED WORK/MATERIAL SHALL BE PAID FOR AS PART OF SHELTER.
  5. PAVEMENT AND SIDEWALK REPLACEMENT SHALL BE CONSIDERED INCLUDED IN THE COST OF THE CONCRETE ENCASED CONDUIT INSTALLATION.
  6. ALL WORK ASSOCIATED WITH THE INSTALLATION OF THE SHELTER UTILITY SERVICE FEED MUST BE COORDINATED WITH AND APPROVED BY COMED.
  7. ALL MATERIALS AND LABOR FOR THE INSTALLATION OF THE CONCRETE ENCASED DUCTBANK FOR UTILITY SERVICE FEED MUST MEET WITH ALL COMED REQUIREMENTS AND STANDARDS.



REVISIONS	
NAME	DATE
REVISION 1	12/17/04
REVISION	2/11/05

ILLINOIS DEPARTMENT OF TRANSPORTATION  
F.A.I. 94/90 (DAN RYAN EXPRESSWAY)  
31st STREET to I-57

MAINTENANCE YARD SHELTER (R02)  
SITE PLAN

SCALE:                          DRAWN BY: DHI  
DATE: October 29, 2004                          CHECKED BY: MJL

**Edwards AND Kelcey**  
ONE NORTH FRANKLIN  
CHICAGO, IL 60606  
PHONE: (312) 251-3000  
FAX: (312) 251-3015  
WEB: WWW.EDKORP.COM

02/09/2005 03:59:55 PM P:\03\0019\035\TSCADD\PROJ\0019E-SJT