
 


F.A.I. NO.	SECTION	COUNTY	TOTAL SHEETS	SHEET NO.
90/94	2003-0311	COOK	976	77
STA. 2024+00		TO STA. 2011+00		
FED. ROAD DIST. NO.		ILLINOIS FED. AID PROJECT		

62583

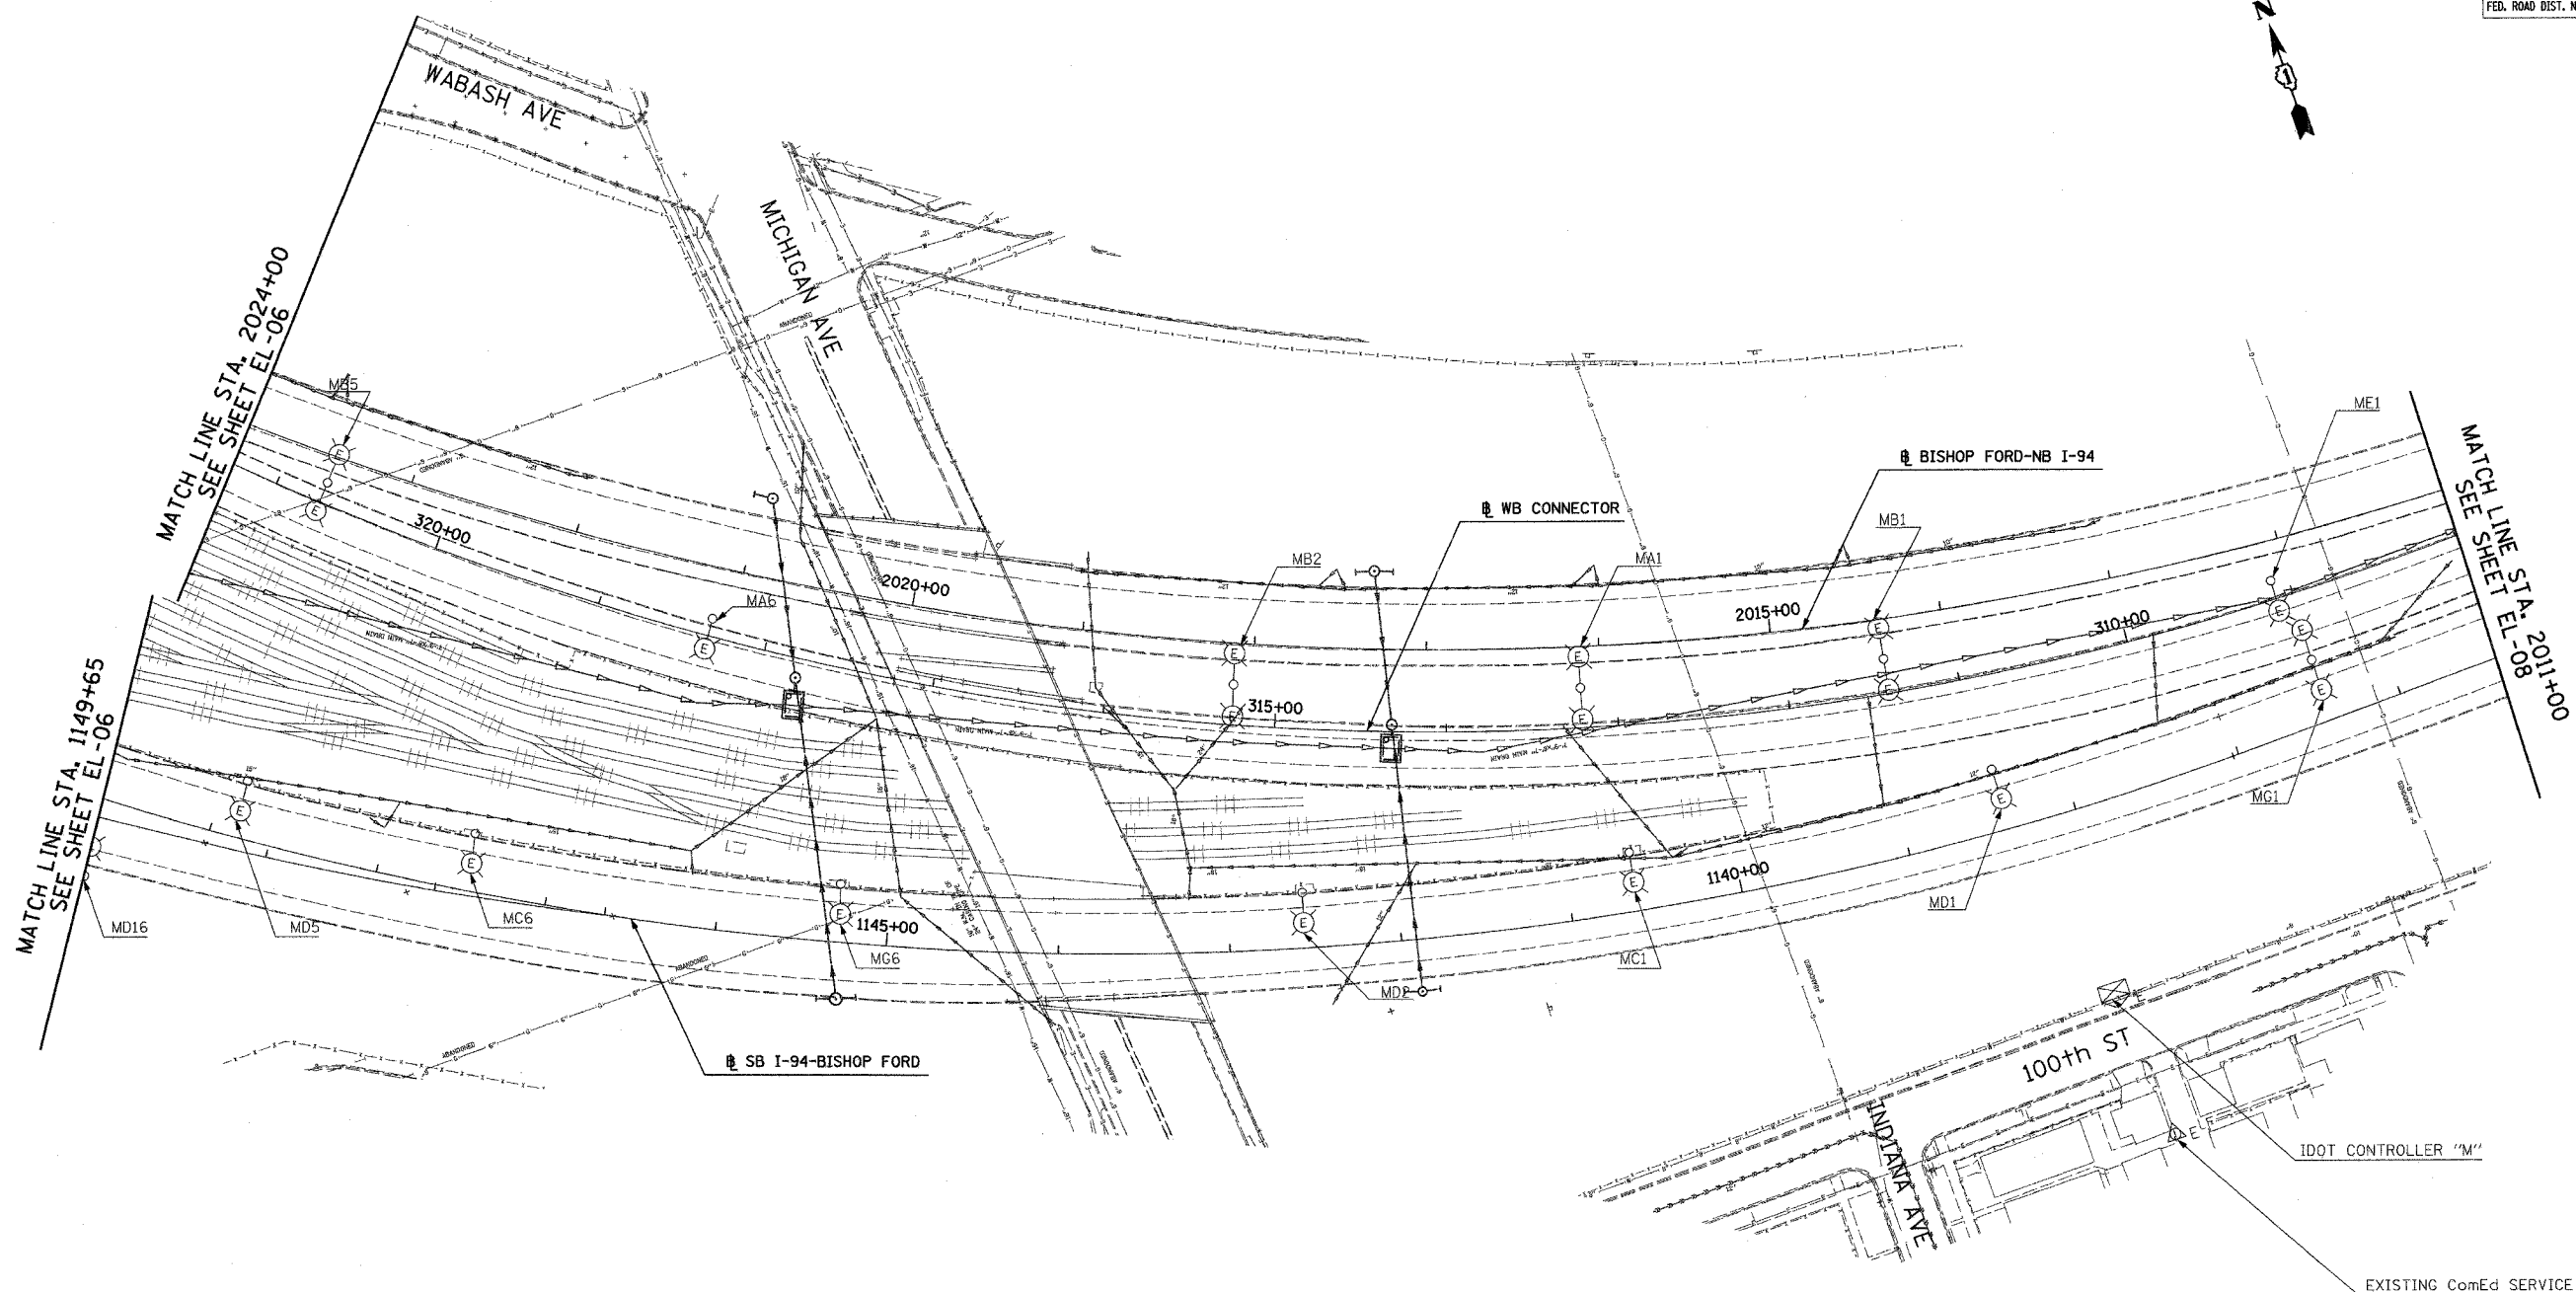

NO ELECTRICAL WORK THIS SHEET  
FOR REFERENCE ONLY



EL-07

REVISIONS	
NAME	DATE

ILLINOIS DEPARTMENT OF TRANSPORTATION  
F.A.I. 90/94 (DAN RYAN EXPRESSWAY)  
31st STREET TO I-57

ROADWAY LIGHTING PLANS EXISTING  
CONDITIONS, TEMPORARY AND REMOVAL

SCALE: 1"=50'  
DATE: OCTOBER 29, 2004

DRAWN BY: SP  
CHECKED BY: TM

**SINGH** 300 N. ADAMS ST.  
CHICAGO, IL 60606  
SINGH & ASSOCIATES, INC.  
CONSULTING ENGINEERS TEL: (312) 629-0240  
FAX: (312) 629-6449

10/20/2004 6:03:28 PM