
 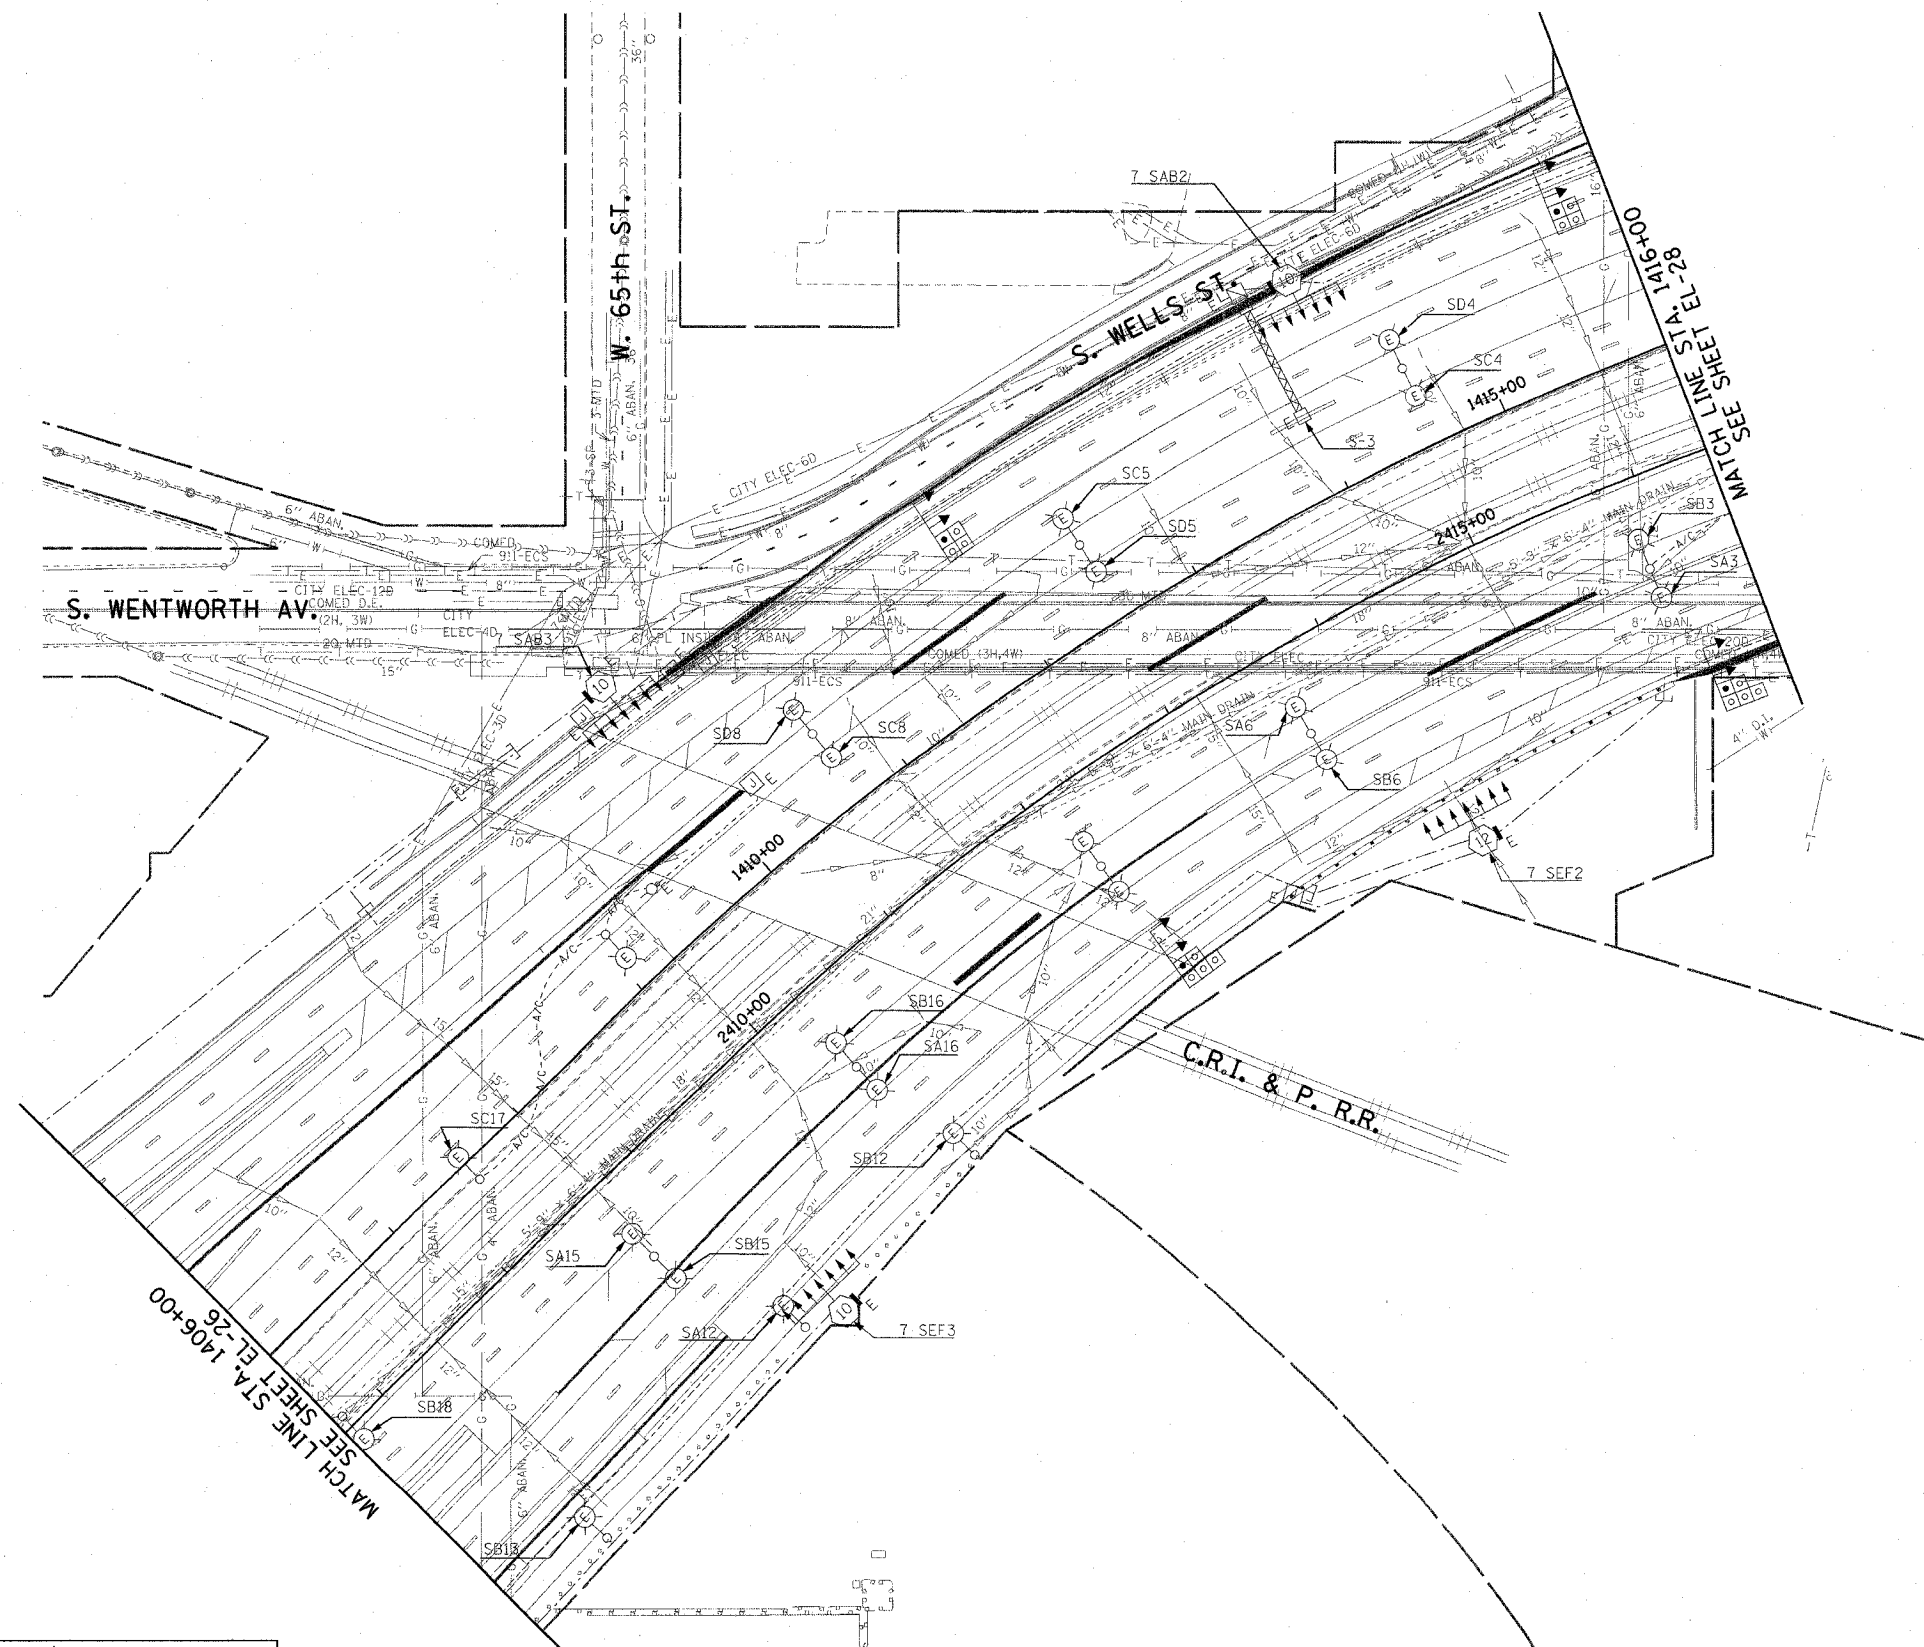


F.A.I. RTE.	SECTION	COUNTY	TOTAL SHEETS	SHEET NO.
90/94	2003-0311	COOK	976	49
STA. 1406+00.00		TO STA. 1416+00.00		
FED. ROAD DIST. NO. 1		ILLINOIS FED. AID PROJECT		


62583

**NOTES:**

 - SEE DRAWINGS ME-01 AND ME-02 FOR ELECTRICAL SYMBOLS AND ABBREVIATIONS.



THIS SHEET IS FOR INFORMATIONAL PURPOSES ONLY. HIGH MAST LIGHT TOWERS, CONTROLLERS, AND WIRING ARE INSTALLED IN IDOT CONTRACT NO. 62733.



EL-27

REVISIONS	
NAME	DATE

ILLINOIS DEPARTMENT OF TRANSPORTATION  
 F.A.I. 90/94 (DAN RYAN EXPRESSWAY)  
 31st STREET TO I-57  
 ROADWAY LIGHTING PLANS  
 EXISTING CONDITIONS AND DEMOLITION  
 SCALE: 1"=50' DRAWN BY: CJM  
 DATE: October 29, 2004 CHECKED BY: WDS

**CTE ENGINEERS**  
 CONSOER TOWNSEND ENVIRODYNE ENGINEERS, INC.  
 303 EAST WACKER DRIVE, SUITE 600  
 CHICAGO ILLINOIS 60601-5202, PHONE: (312) 938-0300

10/15/2004 02:34:08 PM