


F.A.I. RTE.	SECTION	COUNTY	TOTAL SHEETS	SHEET NO.
90/94	2003-0311	COOK	976	101
STA. 1426+00.00		TO STA. 1436+00.00		
FED. ROAD DIST. NO. 1		ILLINOIS	FED. AID PROJECT	

62583

NOTES:

 
- SEE DRAWINGS ME-01 AND ME-02 FOR ELECTRICAL SYMBOLS AND ABBREVIATIONS.
- NOT USED.
- UNLESS NOTED OTHERWISE, ALL ITEMS AND WORK SHOWN IN HEAVY LINE WEIGHT ON THIS DRAWING ARE PROPOSED ITEMS AND WORK.
- NOT USED.
- NOT USED.
- NOT USED.
- THE EXISTING ROADWAY LIGHTING MOUNTED ON THE MEDIAN BARRIER WALL NORTH OF 63rd ST. TO 59th ST. MUST REMAIN IN OPERATION UNTIL THE PROPOSED ROADWAY LIGHTING SYSTEM HAS BEEN INSTALLED, ENERGIZED, TESTED, AND ACCEPTED BY THE ENGINEER, UNLESS OTHERWISE DIRECTED.
- DISCONNECT THE EXISTING TEMPORARY AERIAL CABLE FROM SIGN STRUCTURE "S-5" AND COIL AT THE NEAREST LIGHTING UNIT TO REMAIN. THE TEMPORARY AERIAL CABLE SHALL NOT BE DISCONNECTED UNTIL THE PERMANENT FEED TO THE SIGN STRUCTURE HAS BEEN INSTALLED, TESTED, AND ACCEPTED BY THE ENGINEER.

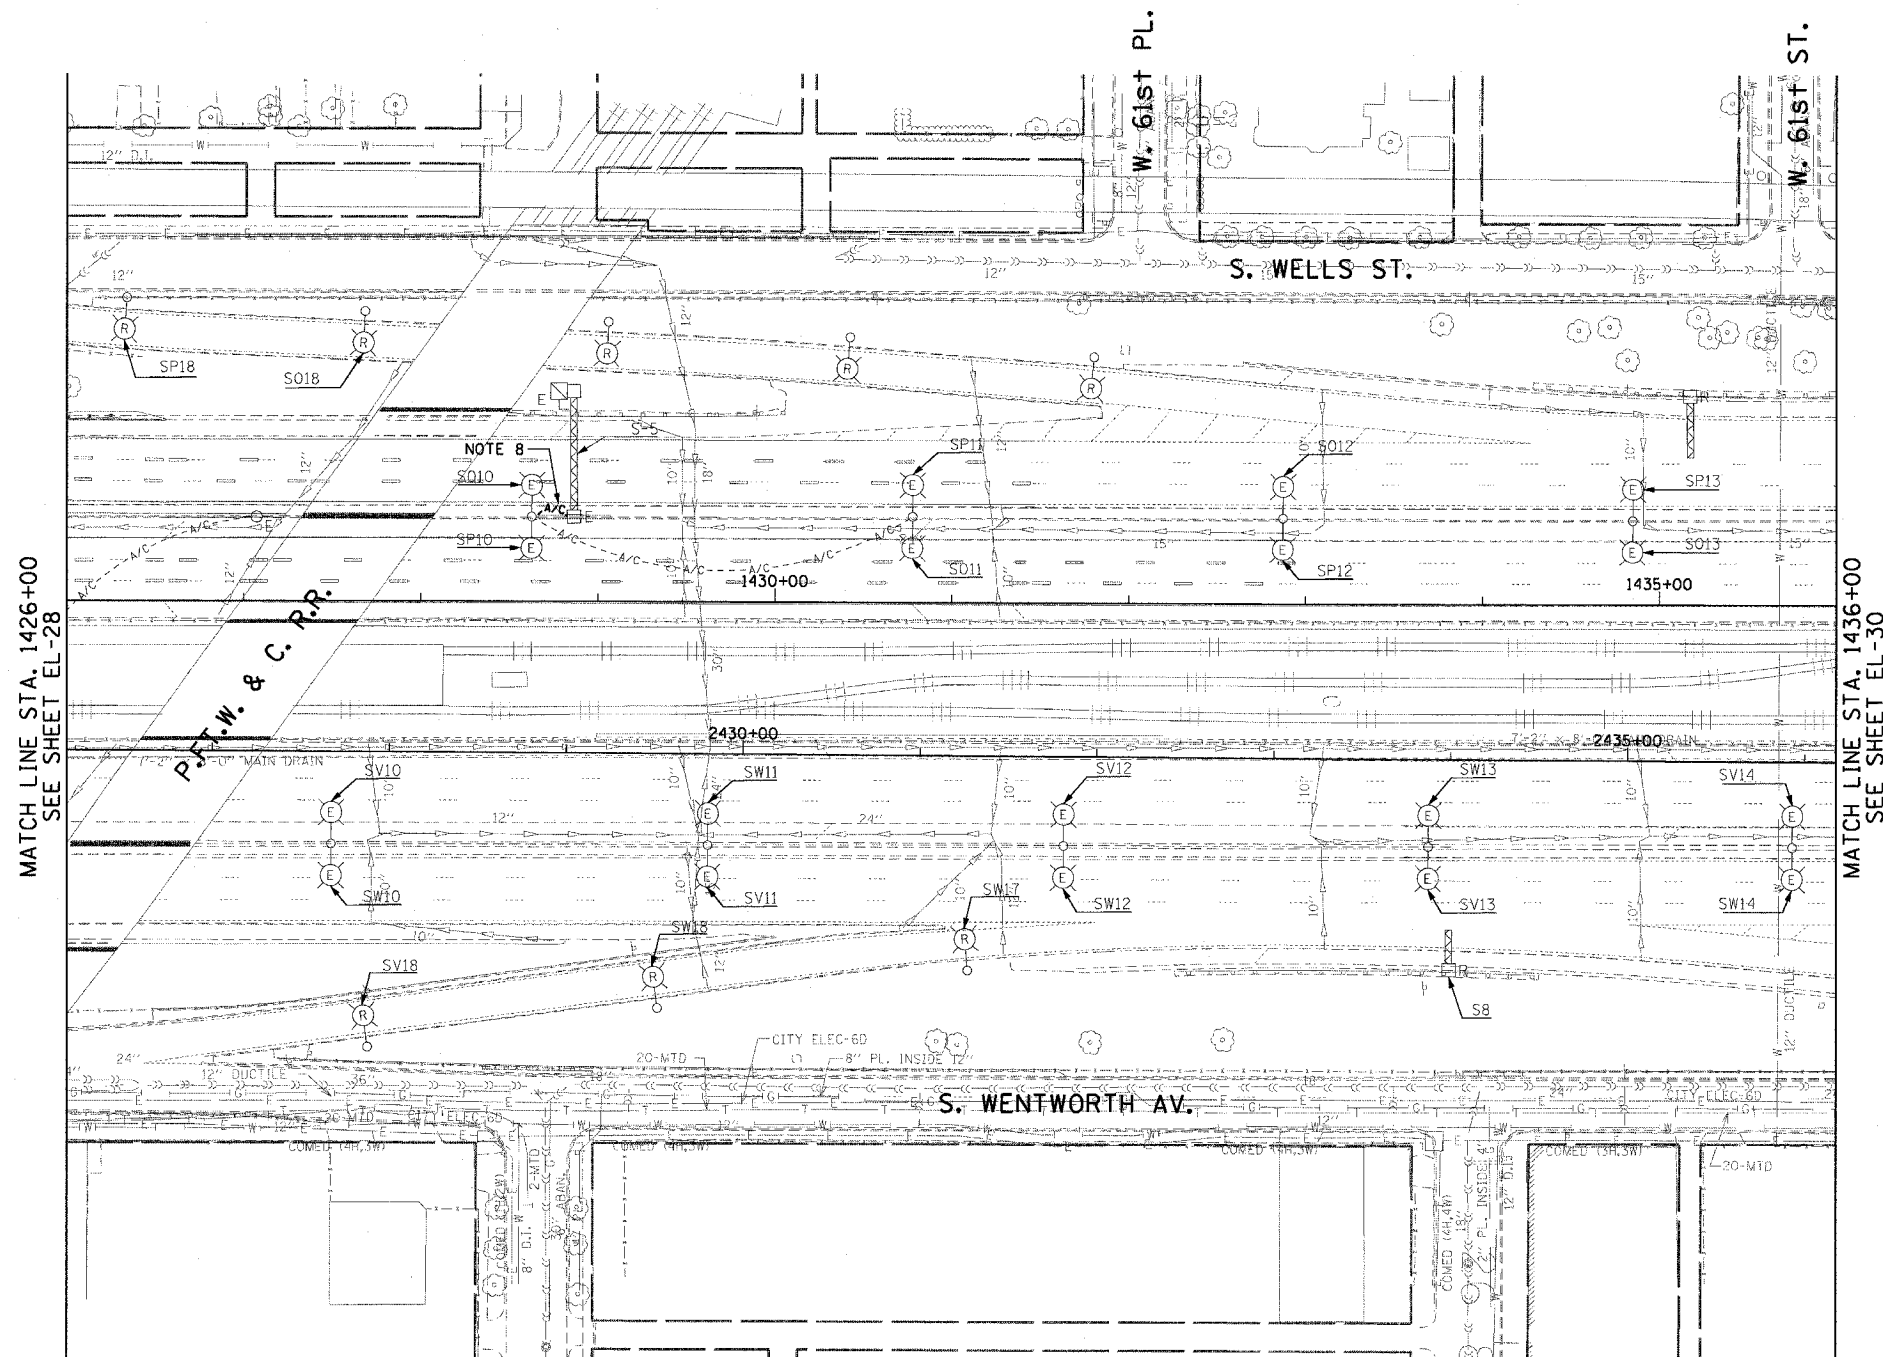

MATCH LINE STA. 1426+00
SEE SHEET EL-28

MATCH LINE STA. 1436+00
SEE SHEET EL-30

EXISTING RAMP LIGHTING AND LIGHTED SIGN LIGHTING ARE REMOVED IN IDOT CONTRACT NO. 62733.



EL-29

REVISIONS	
NAME	DATE
REVISED	1/21/05

ILLINOIS DEPARTMENT OF TRANSPORTATION
F.A.I. 90/94 (DAN RYAN EXPRESSWAY)
31st STREET TO I-57

**ROADWAY LIGHTING PLANS
EXISTING CONDITIONS AND DEMOLITION**

SCALE: 1"=50' DRAWN BY: CJM
DATE: October 29, 2004 CHECKED BY: WDS

CTE ENGINEERS
CONSOER TOWNSEND ENVIRONMENTAL ENGINEERS, INC.
303 EAST WACKER DRIVE, SUITE 600
CHICAGO, ILLINOIS 60601-5262, PHONE: (312) 938-0300

m:\p\0460\elec\16-ent\20\ent\contract\2004\el29\el29.dwg 01/24/2005 11:59:34 AM