


F.A.I. RTE.	SECTION	COUNTY	TOTAL SHEETS	SHEET NO.
90/94	2003-0311	COOK	976	102
STA. 1436+00.00		TO STA. 1446+50.00		
FED. ROAD DIST. NO. 1		ILLINOIS FED. AID PROJECT		

62583

**NOTES:**

 
1. SEE DRAWINGS ME-01 AND ME-02 FOR ELECTRICAL SYMBOLS AND ABBREVIATIONS.
2. NOT USED.
3. NOT USED.
4. NOT USED.
5. NOT USED.
6. THE EXISTING ROADWAY LIGHTING MOUNTED ON THE MEDIAN BARRIER WALL NORTH OF 63rd ST. TO 59th ST. MUST REMAIN IN OPERATION UNTIL THE PROPOSED ROADWAY LIGHTING SYSTEM HAS BEEN INSTALLED, ENERGIZED, TESTED, AND ACCEPTED BY THE ENGINEER, UNLESS OTHERWISE DIRECTED.

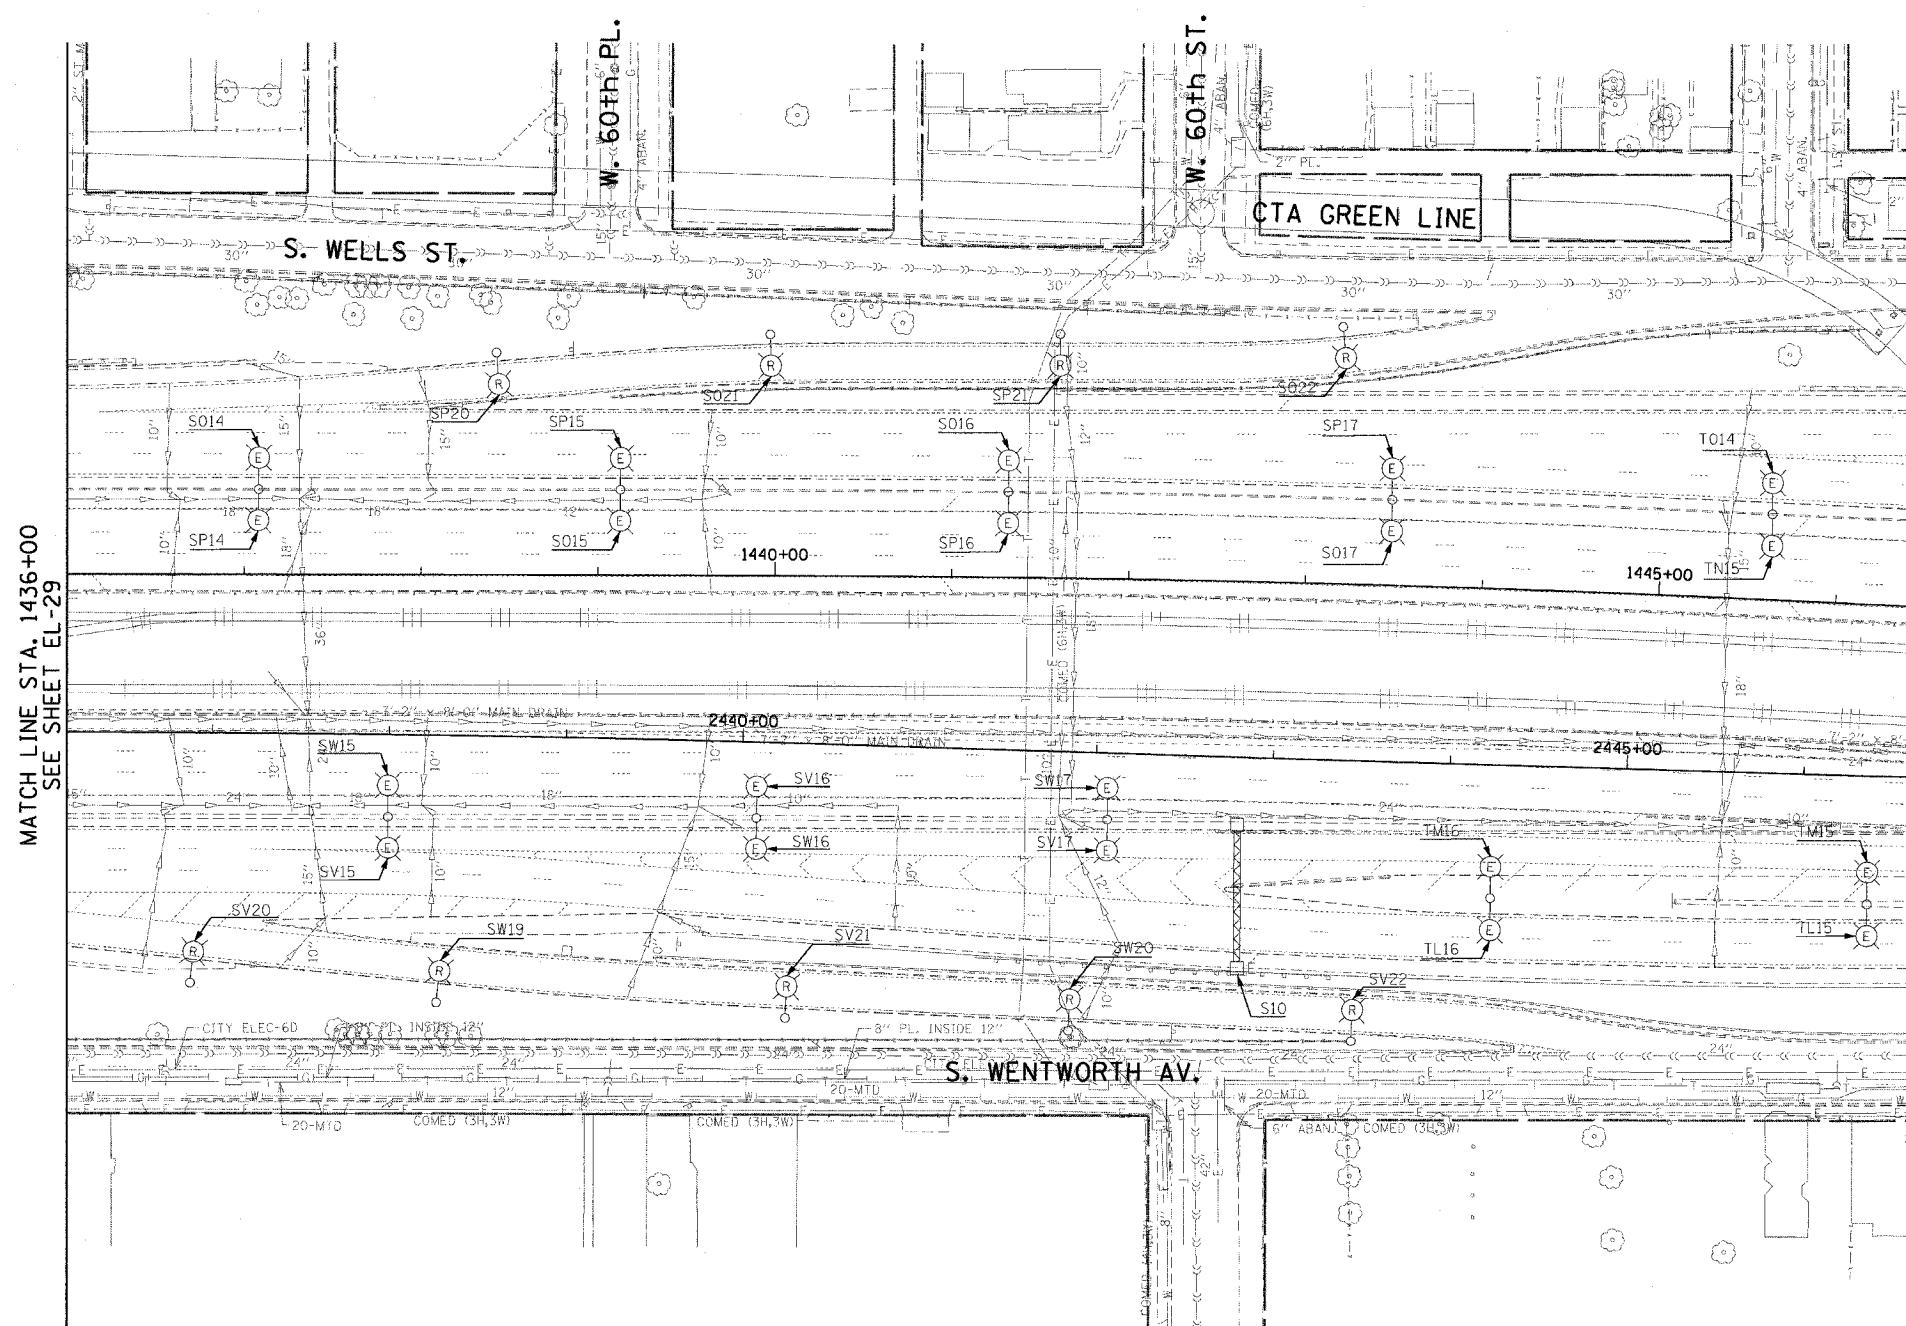

MATCH LINE STA. 1436+00  
SEE SHEET EL-29

MATCH LINE STA. 1446+50  
SEE SHEET EL-31

THIS SHEET IS FOR INFORMATIONAL PURPOSES ONLY.  
EXISTING RAMP LIGHTING IS REMOVED IN IDOT  
CONTRACT NO. 62733.




EL-30

REVISIONS	
NAME	DATE
REVISOR	1/21/05

ILLINOIS DEPARTMENT OF TRANSPORTATION  
F.A.I. 90/94 (DAN RYAN EXPRESSWAY)  
31st STREET TO I-57  
  
ROADWAY LIGHTING PLANS  
EXISTING CONDITIONS AND DEMOLITION

 SCALE: 1"=50'      DRAWN BY: CJM  
DATE: October 29, 2004      CHECKED BY: WDS



01/24/2005 11:59:35 AM