


F.A.I. RTE.	SECTION	COUNTY	TOTAL SHEETS	SHEET NO.
90/94	2003-0311	COOK	976	149
STA. 1506+50.00		TO STA. 1518+00.00		
FED. ROAD DIST. NO. 1		ILLINOIS FED. AID PROJECT		

62583


**NOTES:**

 1. SEE DRAWINGS ME-01 AND ME-02 FOR ELECTRICAL SYMBOLS AND ABBREVIATIONS.
2. UNLESS NOTED OTHERWISE, ALL ITEMS AND WORK SHOWN IN HEAVY LINE WEIGHT ON THIS DRAWING ARE PROPOSED ITEMS AND WORK.
3. PROVIDE A TEMPORARY POWER FEED TO THE EXISTING SIGN TRUSS STRUCTURE LIGHTING UNITS. SEE DRAWING ME-25 FOR TEMPORARY POWER FEED TO SIGN STRUCTURE DETAILS.

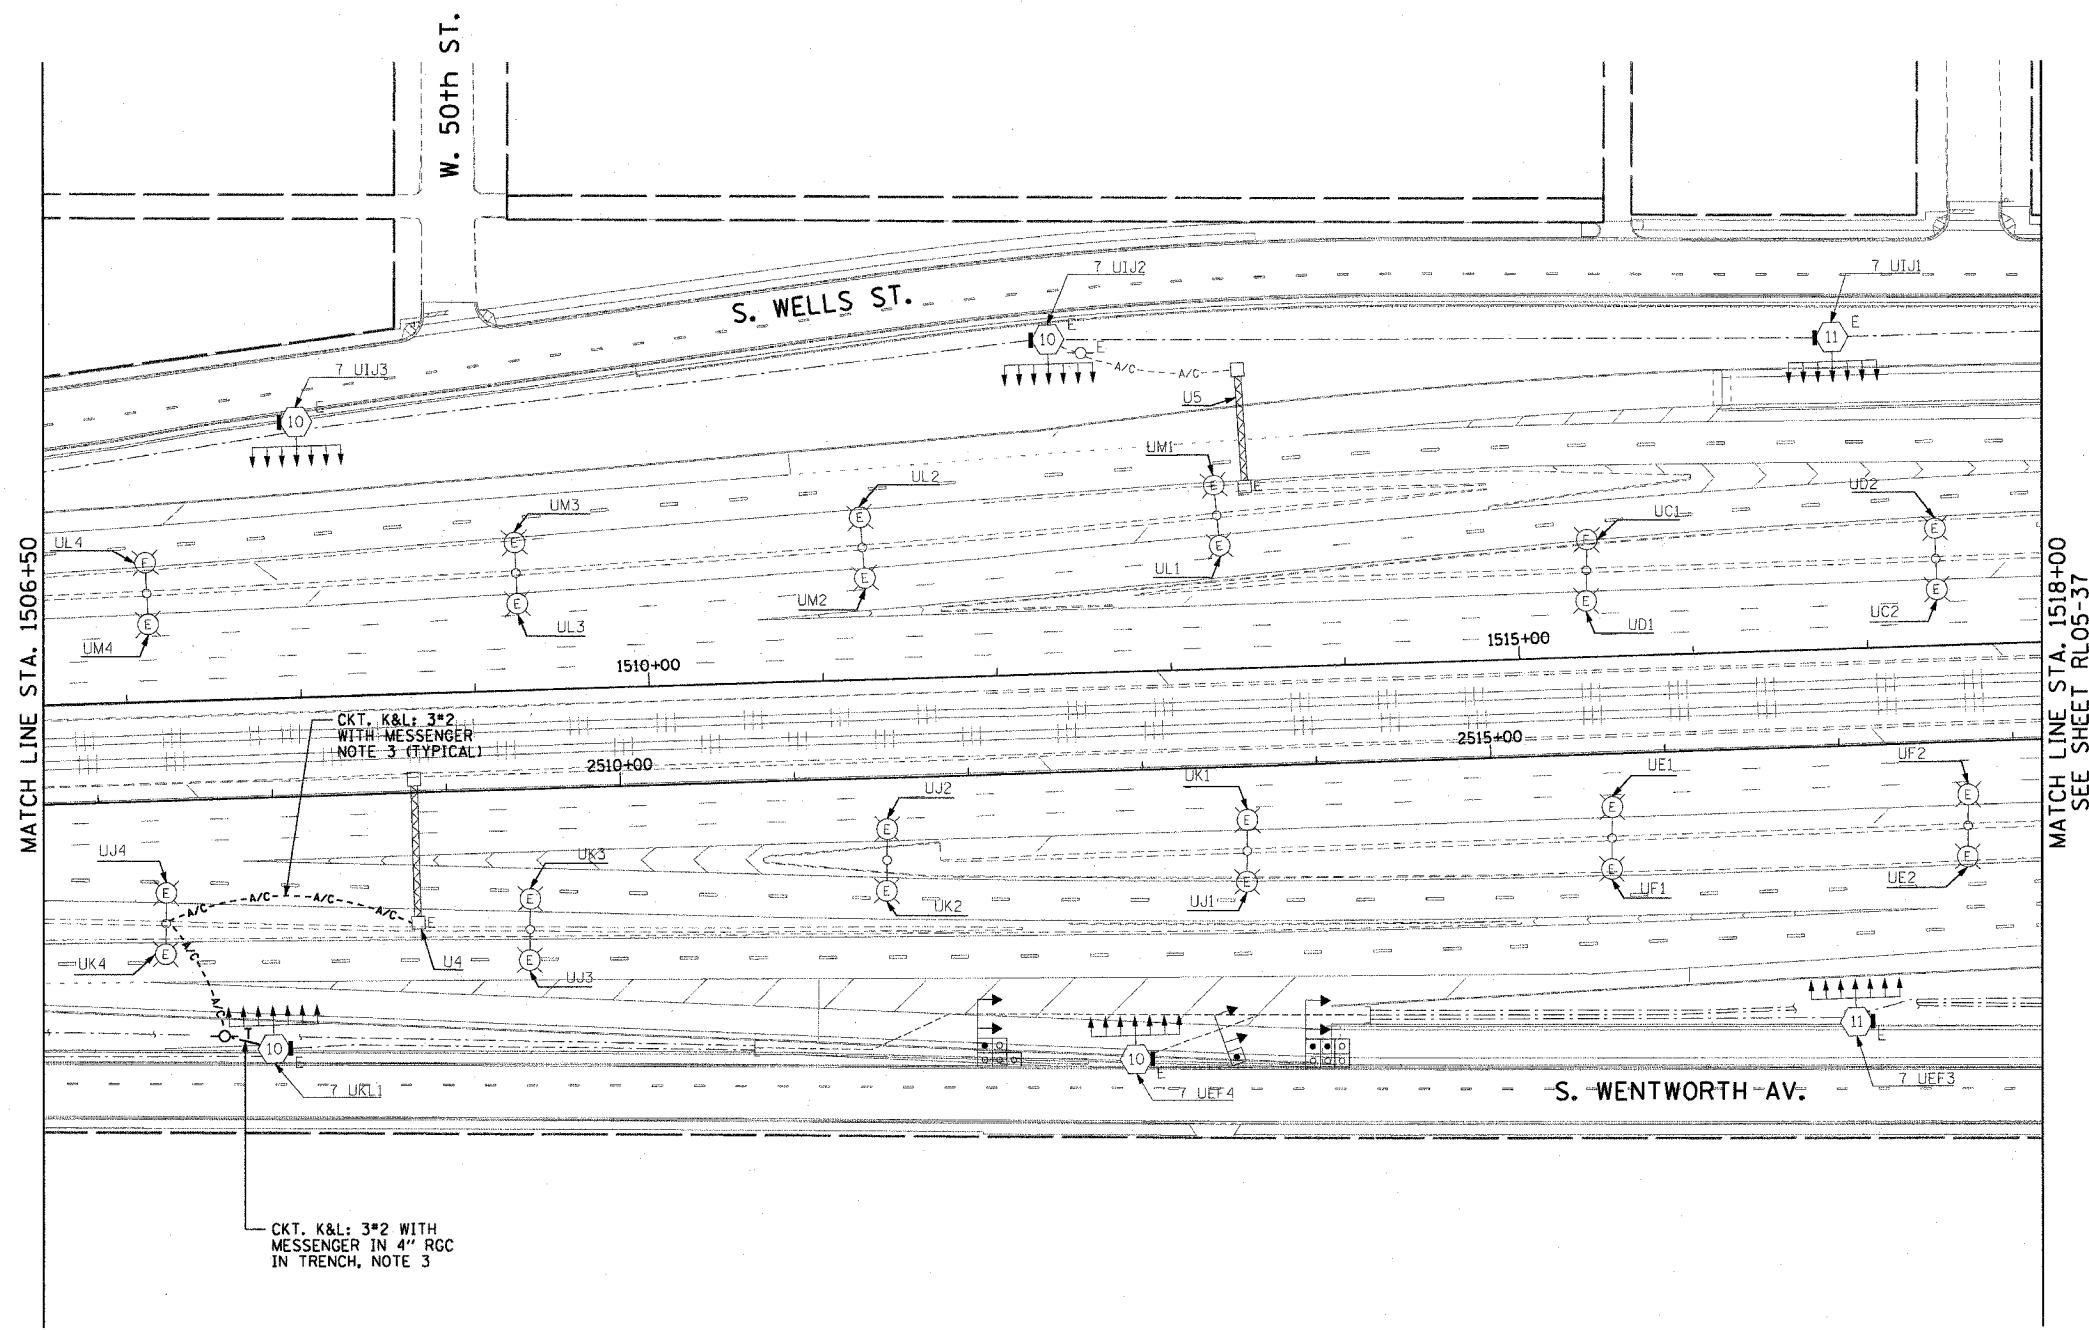

CKT. K&L: 3\*2 WITH MESSENGER NOTE 3 (TYPICAL)

CKT. K&L: 3\*2 WITH MESSENGER IN 4" RCC IN TRENCH, NOTE 3



RL05-36

REVISIONS	
NAME	DATE

ILLINOIS DEPARTMENT OF TRANSPORTATION  
 F.A.I. 90/94 (DAN RYAN EXPRESSWAY)  
 31st STREET TO I-57  
**ROADWAY LIGHTING PLANS  
 PROPOSED IMPROVEMENTS 2005**  
 SCALE: 1"=50' DRAWN BY: CJM  
 DATE: October 29, 2004 CHECKED BY: WDS

**CTE ENGINEERS**  
 CONSER TOWNSEND ENVRONDIENE ENGINEERS, INC.  
 303 EAST WACKER DRIVE, SUITE 600  
 CHICAGO, ILLINOIS 60601-5222, PHONE: (312) 938-0300

m:\p4\6666\elect\VE cmt\21\SP\contract\2\2005\70203620\_C\_05.rvt 10/15/2004 02:35:32 PM