


F.A.I. RTE.	SECTION	COUNTY	TOTAL SHEETS	SHEET NO.
90/94	2003-0311	COOK	976	150
STA. 1518+00.00		TO STA. 1529+50.00		
FED. ROAD DIST. NO. 1 ILLINOIS FED. AID PROJECT				

62583

 
NOTES:

- SEE DRAWINGS ME-01 AND ME-02 FOR ELECTRICAL SYMBOLS AND ABBREVIATIONS.
- UNLESS NOTED OTHERWISE, ALL ITEMS AND WORK SHOWN IN HEAVY LINE WEIGHT ON THIS DRAWING ARE PROPOSED ITEMS AND WORK.
- PROVIDE A TEMPORARY POWER FEED TO THE EXISTING SIGN TRUSS STRUCTURE LIGHTING UNITS. SEE DRAWING ME-25 FOR TEMPORARY POWER FEED TO SIGN STRUCTURE DETAILS.
- SPLICE NEW LIGHTING CIRCUIT CABLES TO THE CORRESPONDING EXISTING LIGHTING CIRCUITS LOCATED WITHIN THE EXISTING JUNCTION BOX.
- CONTRACTOR MUST DRILL AN ACCESS HOLE ON THE BOTTOM OF THE EXISTING JUNCTION BOX FOR THE TEMPORARY AERIAL CABLES. PROVIDE A WEATHERTIGHT SEAL WHERE THE AERIAL CABLES ENTER THE JUNCTION BOX.
- PROVIDE A TEMPORARY POWER FEED TO HIGH MAST LIGHT TOWER 7 UC1. SEE DRAWING ME-16 FOR TEMPORARY ROADWAY LIGHTING WOOD POLE DETAILS.
- PROVIDE A TEMPORARY POWER FEED TO THE TEMPORARY LIGHTING UNIT AT STA. 2530+88. SEE DRAWING ME-16 FOR TEMPORARY ROADWAY LIGHTING WOOD POLE DETAILS.

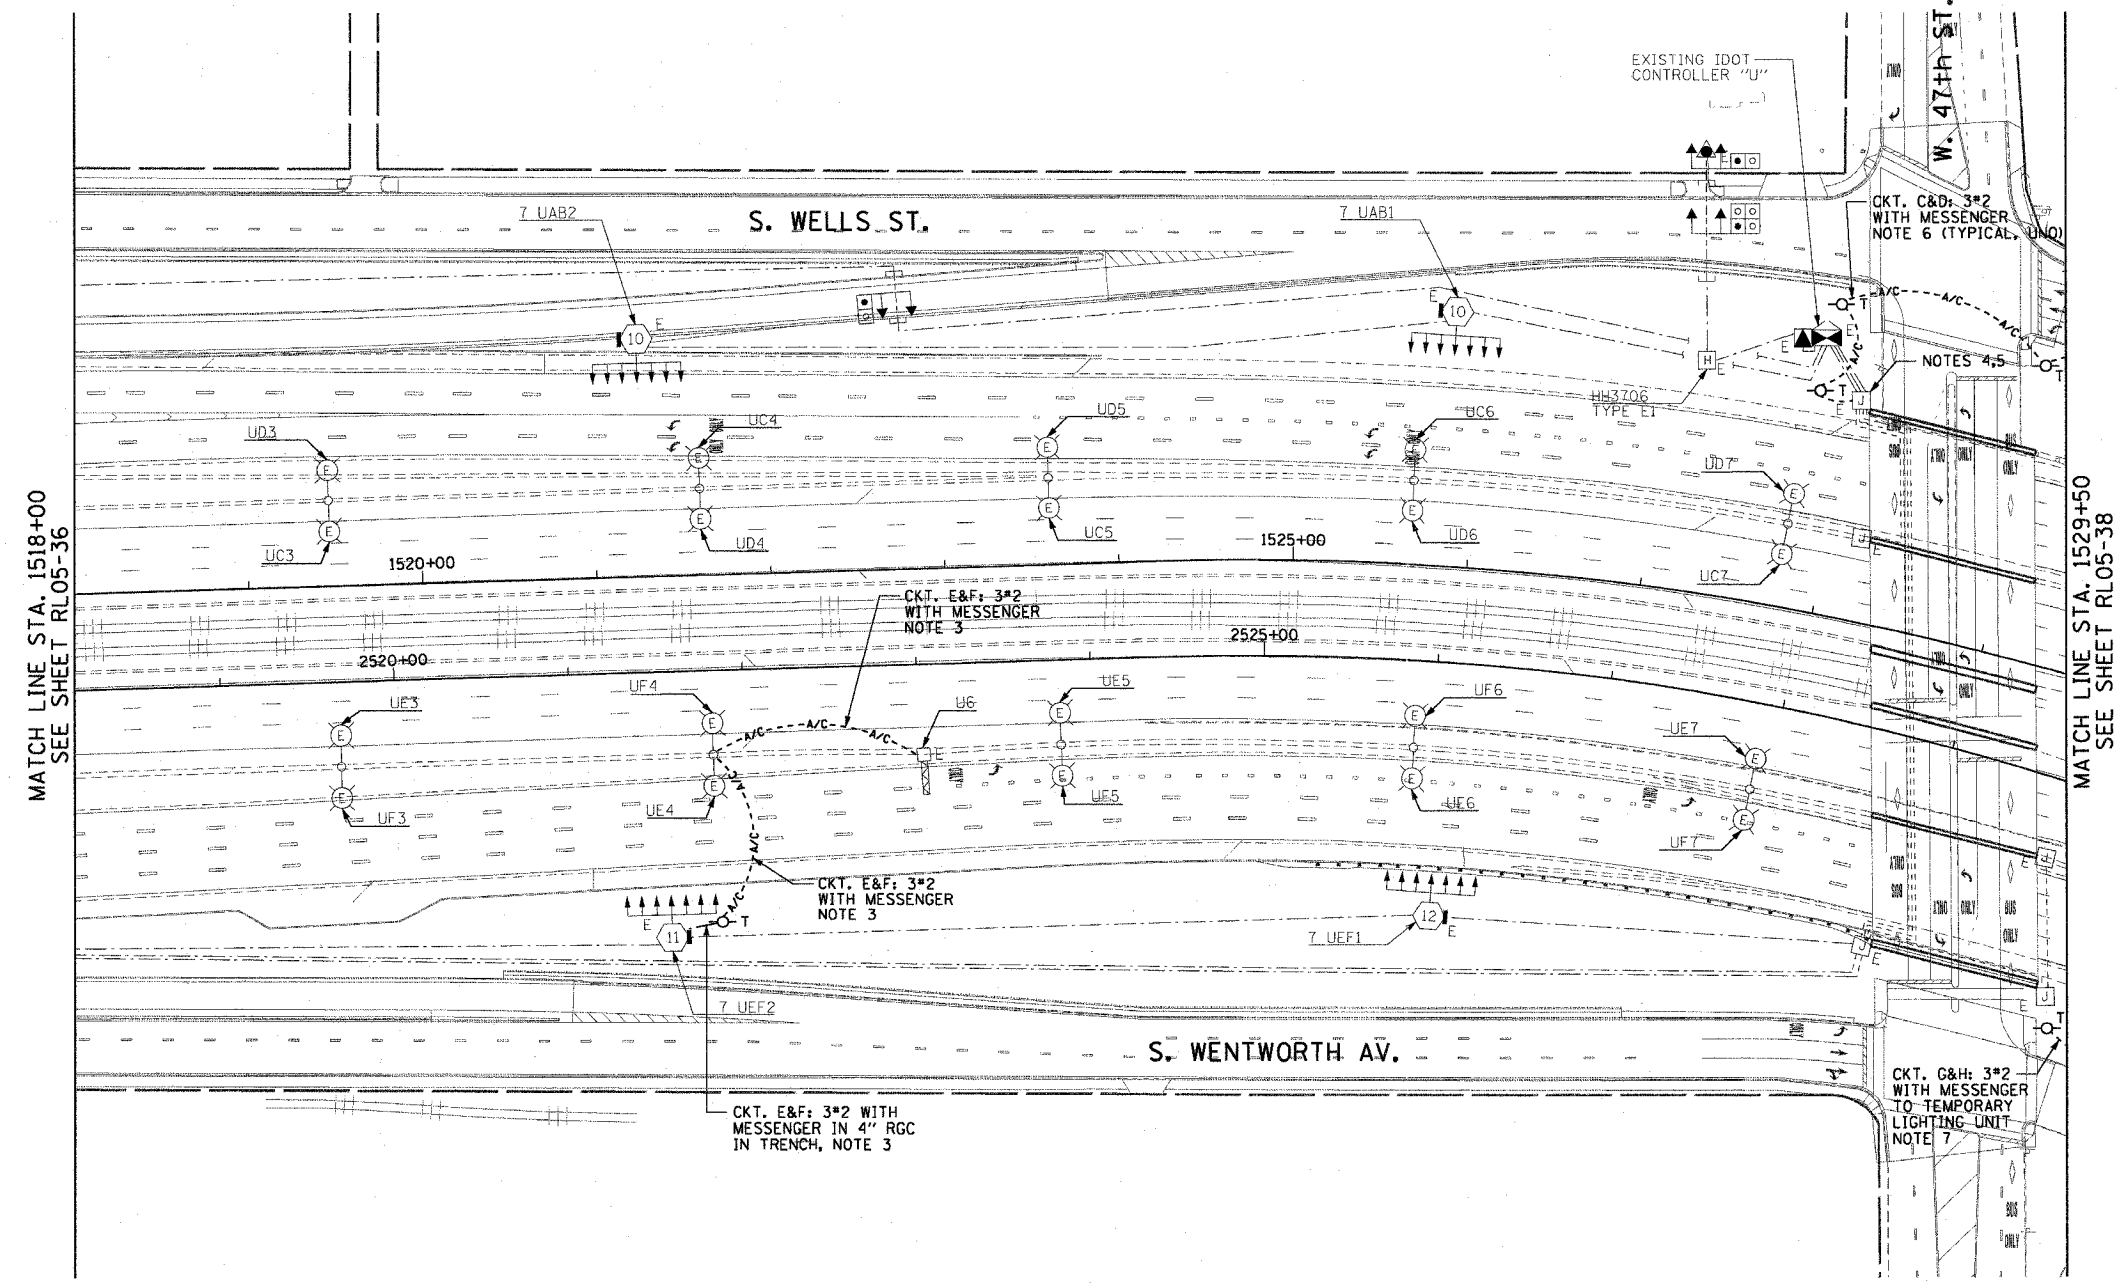

MATCH LINE STA. 1518+00
SEE SHEET RL05-36

MATCH LINE STA. 1529+50
SEE SHEET RL05-38



RL05-37

REVISIONS		ILLINOIS DEPARTMENT OF TRANSPORTATION F.A.I. 90/94 (DAN RYAN EXPRESSWAY) 31st STREET TO I-57
NAME	DATE	
		ROADWAY LIGHTING PLANS PROPOSED IMPROVEMENTS 2005
SCALE: 1"=50'	DRAWN BY: CJM	October 29, 2004
DATE:	CHECKED BY: WDS	

CTE ENGINEERS
 CONSER TOWNSEND ENVIRONMENTAL ENGINEERS, INC.
 303 EAST WACKER DRIVE, SUITE 600
 CHICAGO, ILLINOIS 60601-5222, PHONE: (312) 938-0300

10/15/2004 02:35:34 PM