
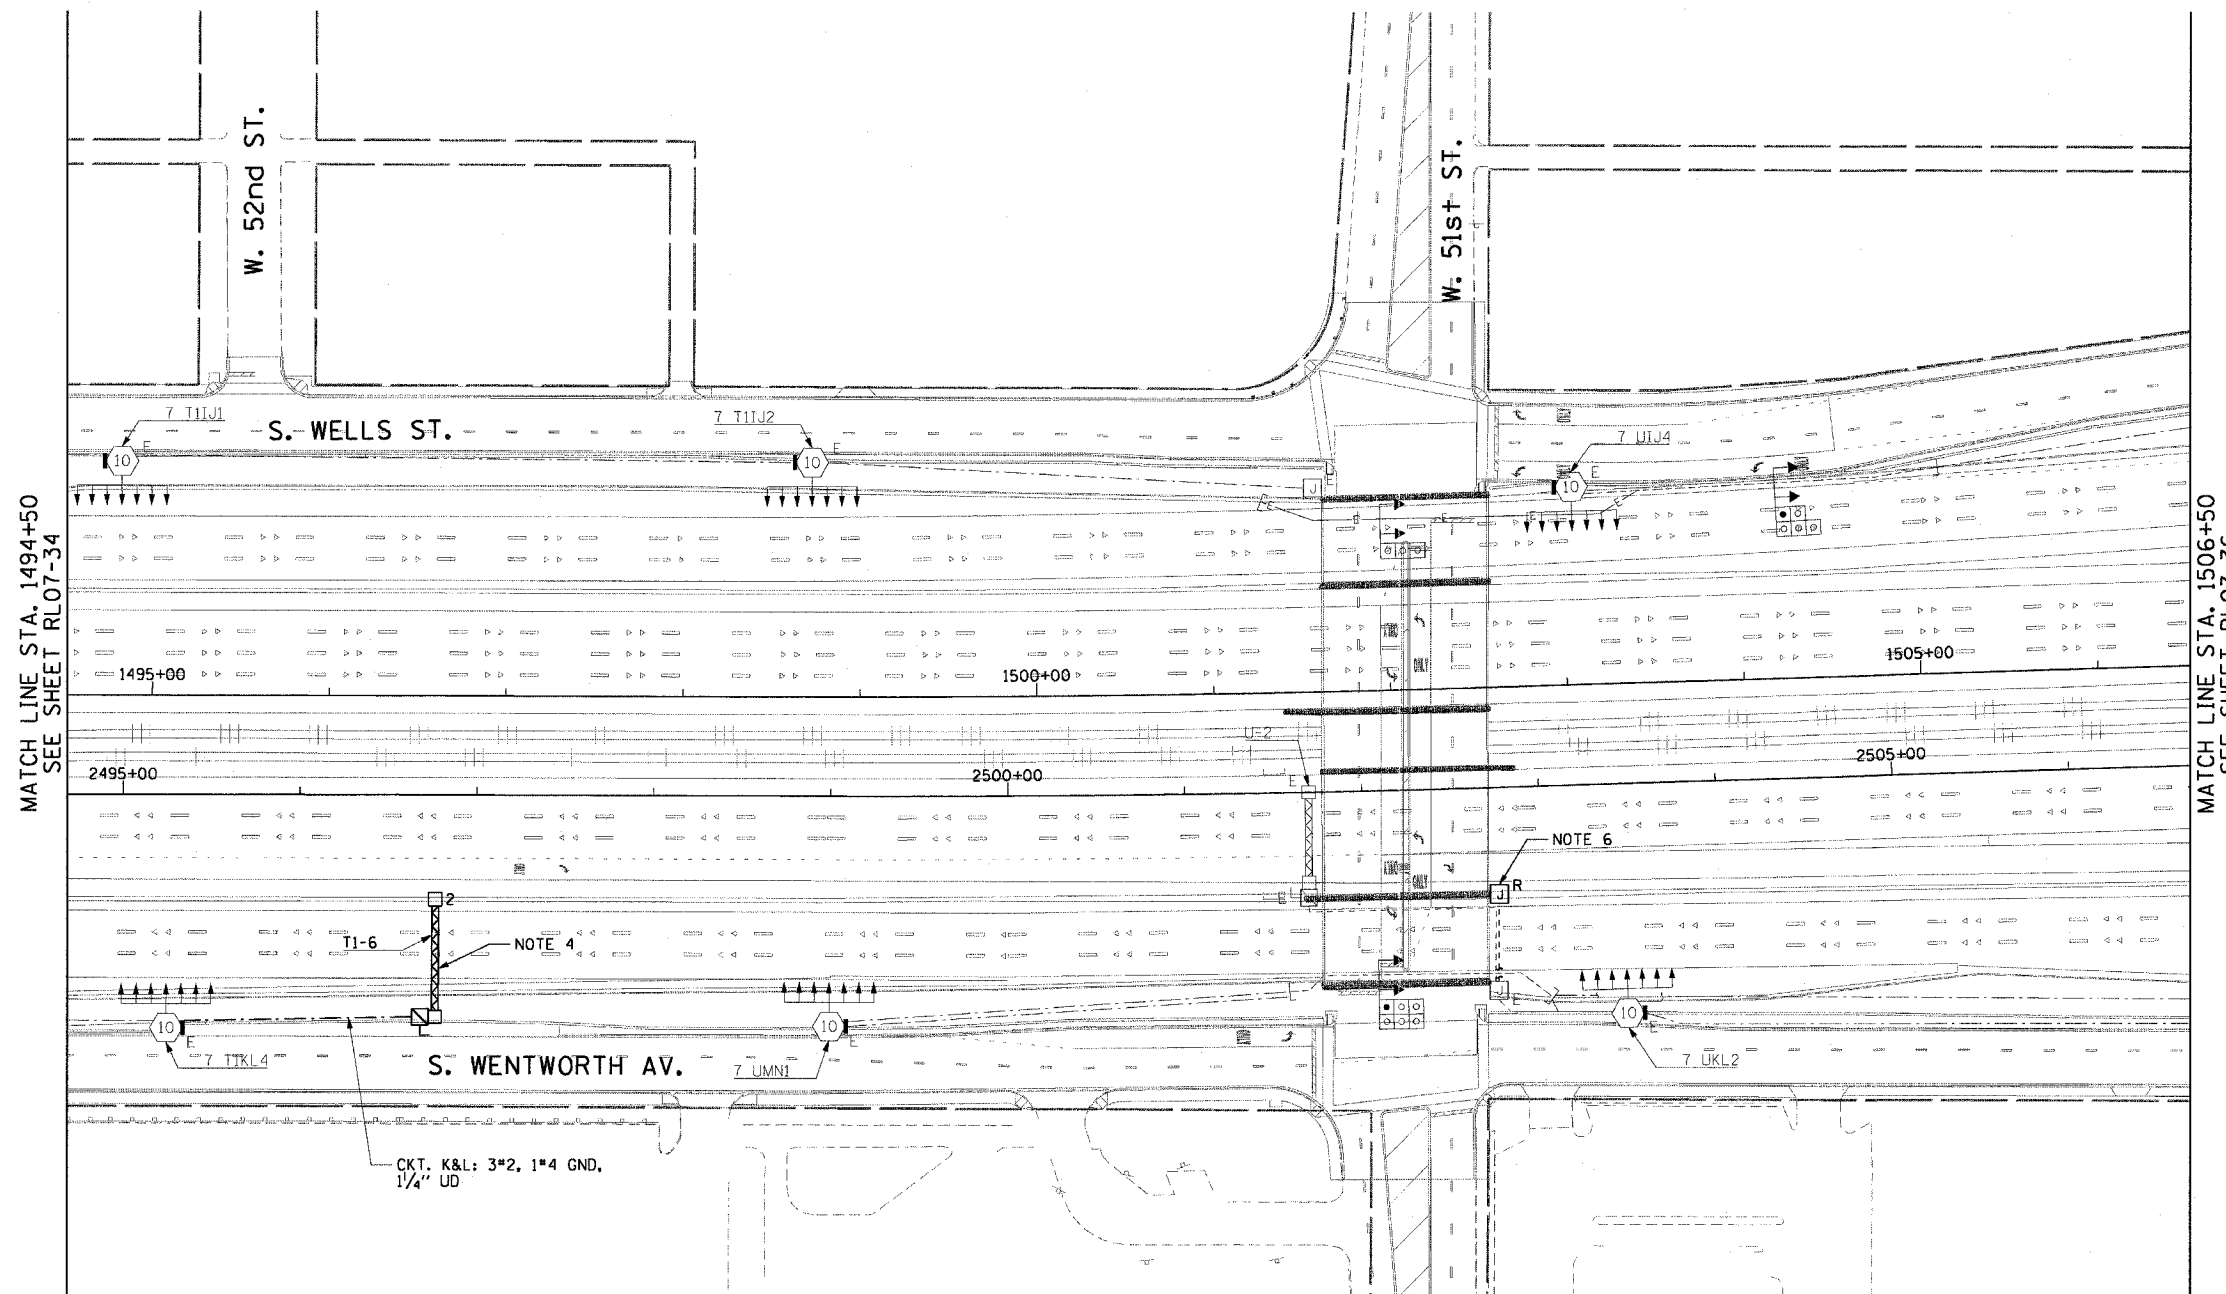 


| F.A.I. RTE.           | SECTION   | COUNTY             | TOTAL SHEETS | SHEET NO.        |
|-----------------------|-----------|--------------------|--------------|------------------|
| 90/94                 | 2003-0311 | COOK               | 976          | 243              |
| STA. 1494+50.00       |           | TO STA. 1506+50.00 |              |                  |
| FED. ROAD DIST. NO. 1 |           | ILLINOIS           |              | FED. AID PROJECT |

62583

**NOTES:**

1. SEE DRAWINGS ME-01 AND ME-02 FOR ELECTRICAL SYMBOLS AND ABBREVIATIONS.
2. COORDINATE WORK WITH IDOT CONTRACT NOS. 62301 AND 62303.
3. UNLESS NOTED OTHERWISE, ALL ITEMS AND WORK SHOWN IN HEAVY LINE WEIGHT ON THIS DRAWING ARE PROPOSED ITEMS AND WORK.
4. SEE IDOT STANDARD DRAWINGS FOR ELECTRIC CONNECTION TO SIGN STRUCTURE DETAILS.
5. THE FINAL INSTALLATION LOCATIONS OF THE LIGHTING RACEWAYS MUST BE COORDINATED WITH THE RACEWAYS SHOWN ON THE SURVEILLANCE PLANS.
6. REMOVE THE EXISTING JUNCTION BOX, CONDUIT, AND MOUNTING HARDWARE FOR THE TEMPORARY POWER FEED TO THE UNDERPASS AND ROADWAY LIGHTING UNITS.




MATCH LINE STA. 1494+50  
SEE SHEET RL07-34

MATCH LINE STA. 1506+50  
SEE SHEET RL07-36

CKT. K&L: 3#2, 1#4 GND,  
1/4" UD

NOTE 6

 NOTE 4



RL07-35

**CTE ENGINEERS**  
CONSER TOWNSEND ENVIRONMENTAL ENGINEERS, INC.  
303 EAST WACKER DRIVE, SUITE 600  
CHICAGO, ILLINOIS 60601-5202, PHONE: (312) 938-0300

| REVISIONS |      |
|-----------|------|
| NAME      | DATE |
|           |      |
|           |      |
ILLINOIS DEPARTMENT OF TRANSPORTATION  
F.A.I. 90/94 (DAN RYAN EXPRESSWAY)  
31st STREET TO I-57  
  
ROADWAY LIGHTING PLANS  
PROPOSED IMPROVEMENTS 2007

SCALE: 1"=50' DRAWN BY: CJM  
DATE: October 29, 2004 CHECKED BY: WDS

10/22/2004 10:46:07 AM