


F.A.I. RTE.	SECTION	COUNTY	TOTAL SHEETS	SHEET NO.
94/90	2003-0311	COOK	976	296
STA. 1548+00	TO STA. 1560+00			
FED. ROAD DIST. NO.	ILLINOIS	FED. AID PROJECT		
62583				

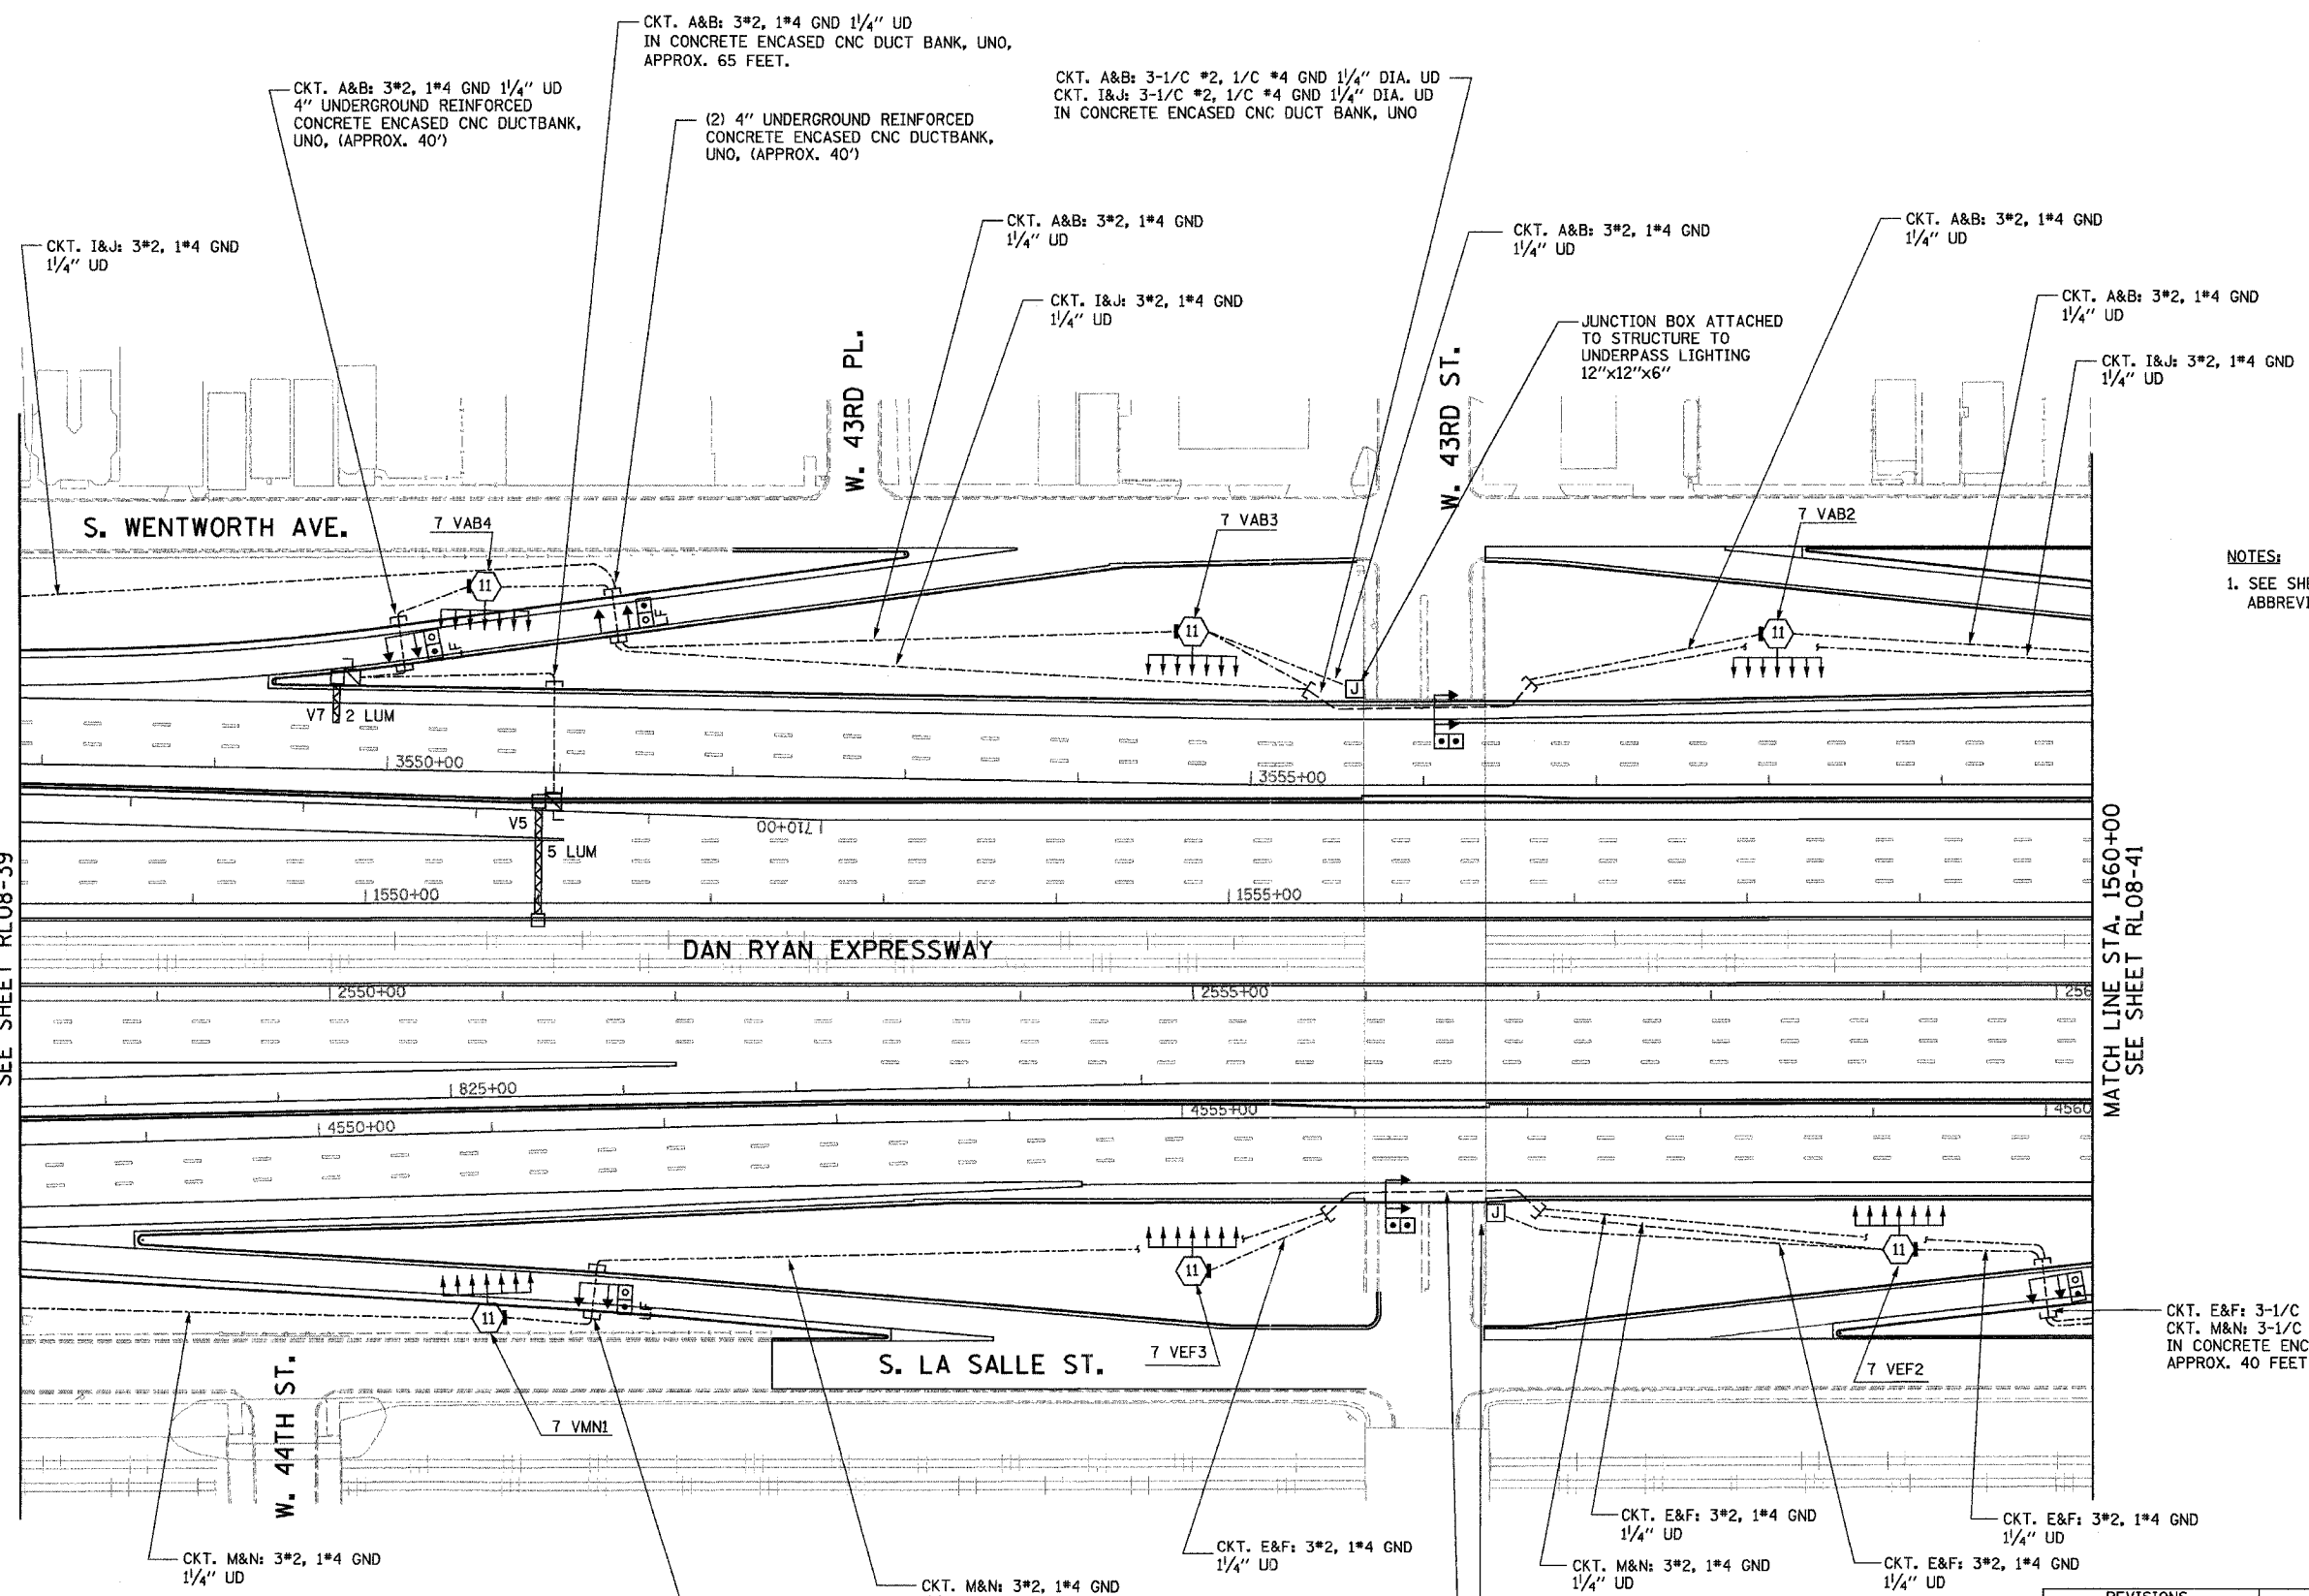

MATCH LINE STA. 1548+00
SEE SHEET RL08-39

MATCH LINE STA. 1560+00
SEE SHEET RL08-41



NOTES:
1. SEE SHEET ME-01 FOR ELECTRICAL SYMBOLS, ABBREVIATIONS, AND NOTES.

CKT. E&F: 3-1/C #2, 1/C #4 GND 1/4" DIA. UD
CKT. M&N: 3-1/C #2, 1/C #4 GND 1/4" DIA. UD
IN CONCRETE ENC ENCASED DUCT BANK, UNO,
APPROX. 40 FEET

CKT. M&N: 3*2, 1*4 GND
1/4" UD

CKT. M&N: 3*2, 1*4 GND
1/4" UD

CKT. E&F: 3*2, 1*4 GND
1/4" UD

CKT. E&F: 3*2, 1*4 GND
1/4" UD

CKT. M&N: 3*2, 1*4 GND
1/4" UD

 
CKT. E&F: 3*2, 1*4 GND
1/4" UD

CKT. E&F: 3*2, 1*4 GND
1/4" UD

4" UNDERGROUND REINFORCED
CONCRETE ENCASED CNC DUCTBANK,
UNO, (APPROX. 40')

CKT. E&F: 3-1/C #2, 1/C #4 GND 1/4" DIA. UD
CKT. M&N: 3-1/C #2, 1/C #4 GND 1/4" DIA. UD
IN CONCRETE CNC ENCASED DUCT BANK, UNO

JUNCTION BOX ATTACHED TO
STRUCTURE TO UNDERPASS
LIGHTING 12"x12"x6"



REVISIONS	
NAME	DATE
REVISED	1/21/05

ILLINOIS DEPARTMENT OF TRANSPORTATION
F.A.I. 94/90 (DAN RYAN EXPRESSWAY)
31st STREET TO I-57

**ROADWAY LIGHTING PLANS
FINAL IMPROVEMENTS**

SCALE: 1"=50'
DATE: OCTOBER 29, 2004

DRAWN BY: BL
CHECKED BY: SM

KAM ENGINEERING, INC.
CONSULTING ENGINEERS
707A Davis Road, Suite 205
Elgin, Illinois 60123-1369

RL08-40

01/24/2005 03:37:50 PM