

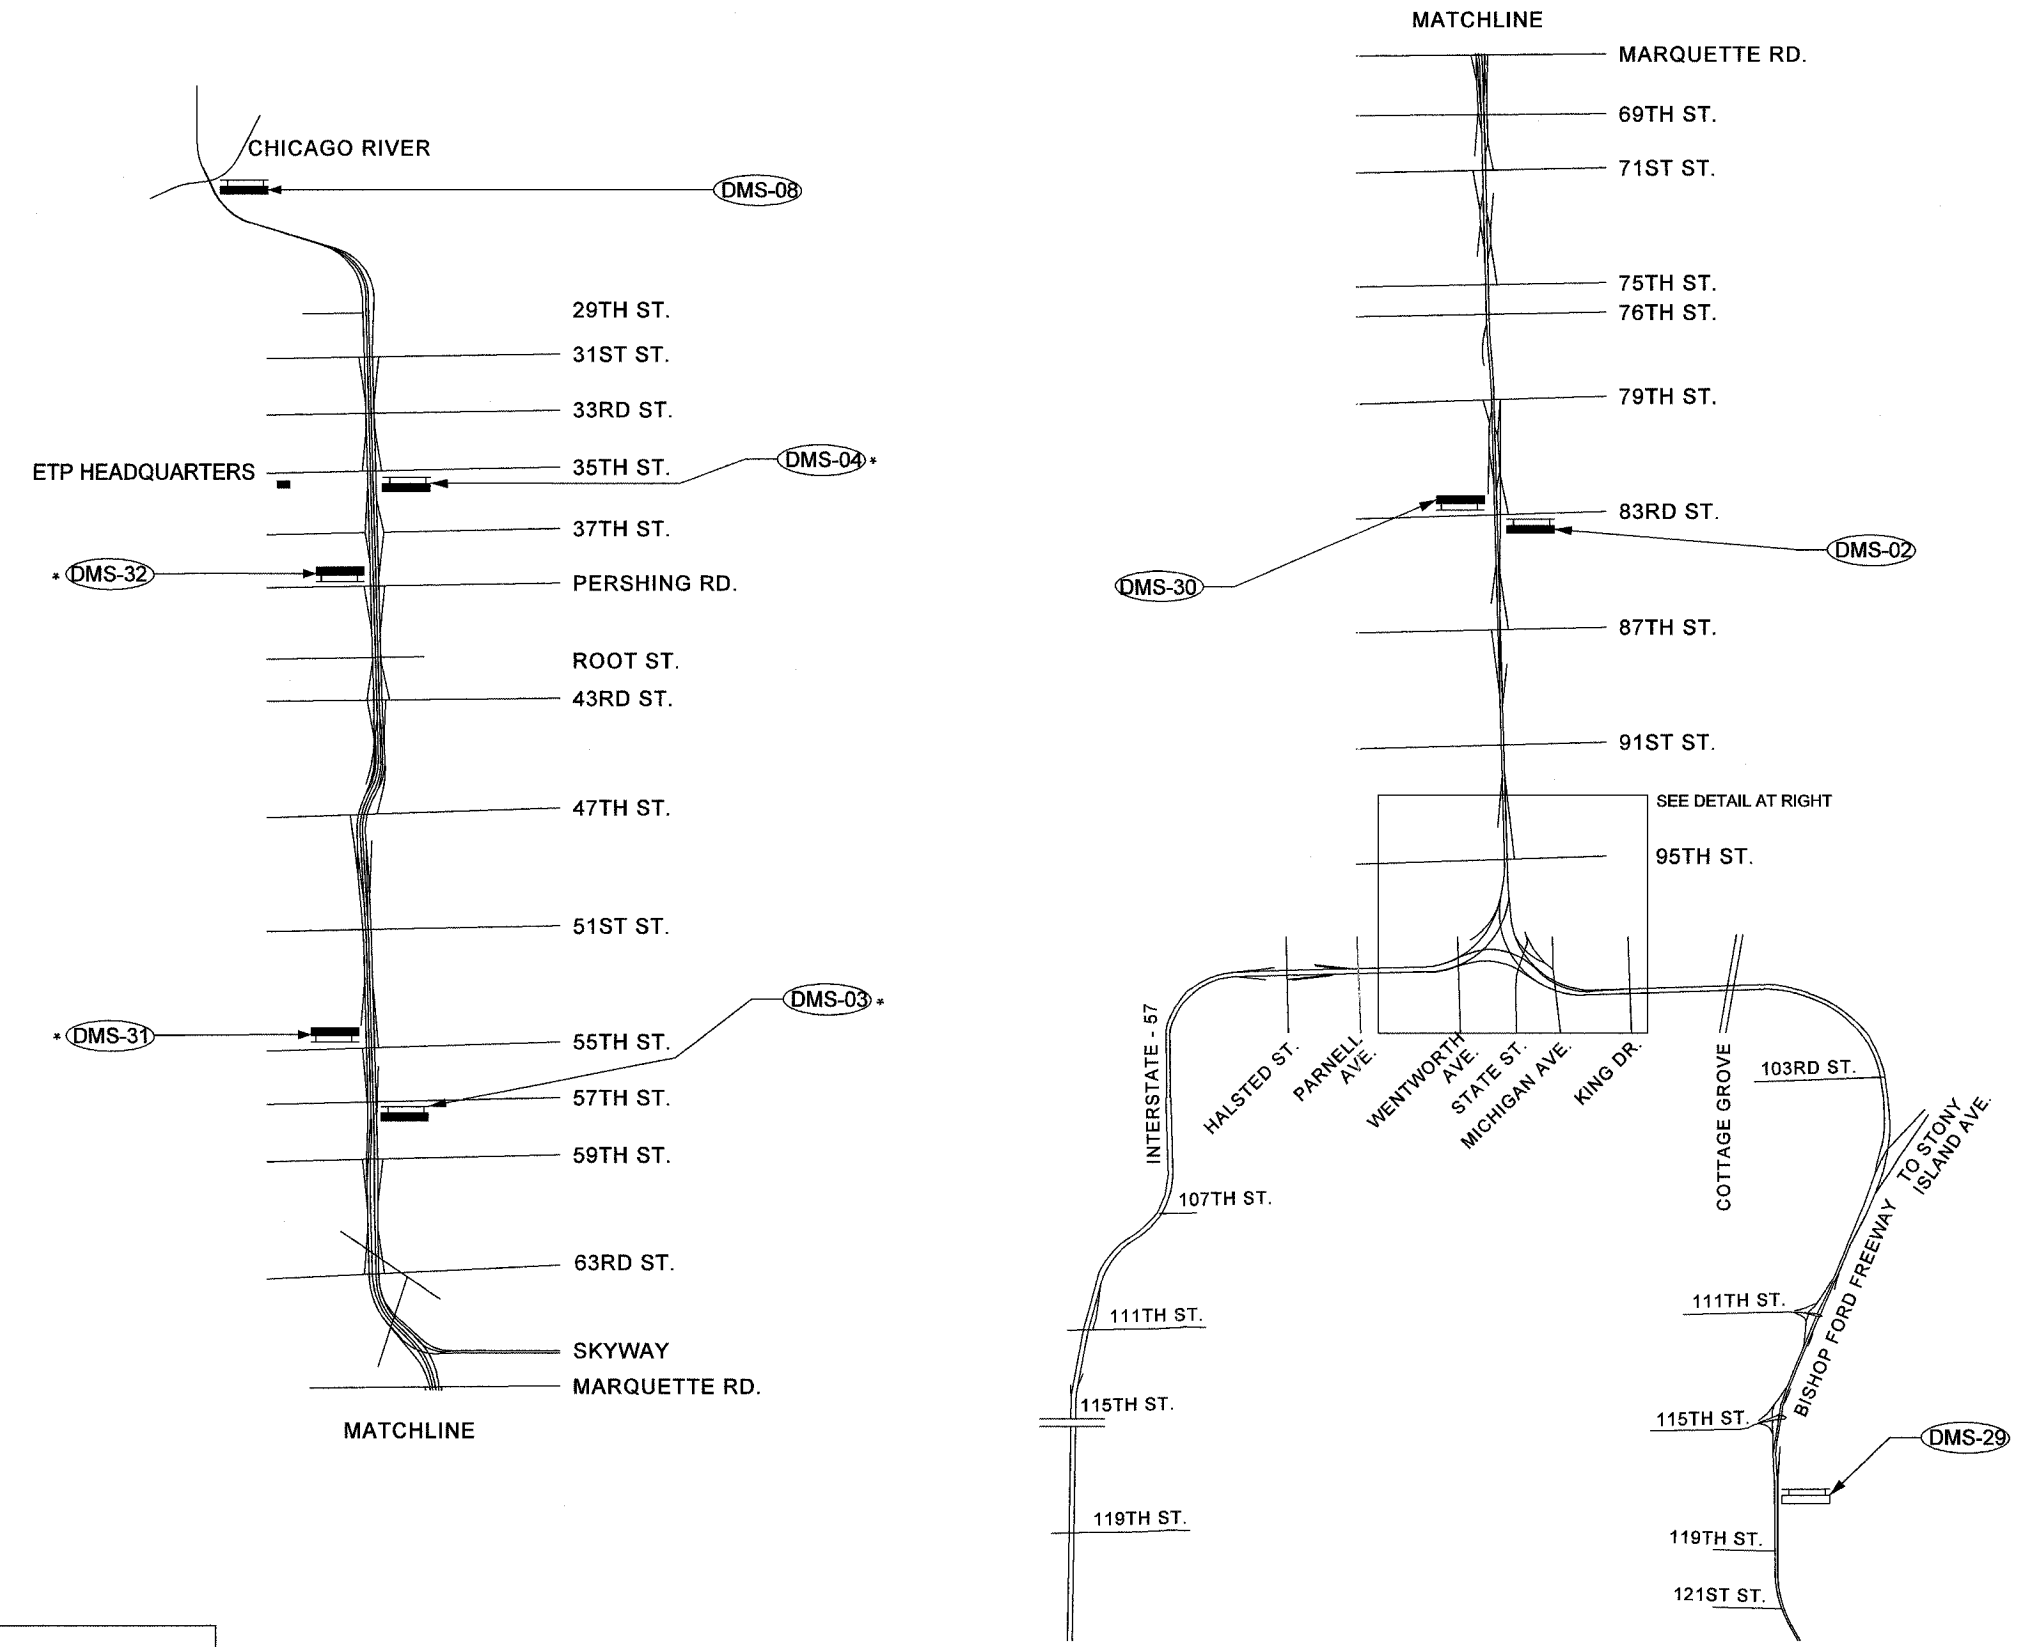


SECTION	COUNTY	TOTAL SHEETS	SHEET NO.
2003-0311	COOK	976	607
STA.	TO STA.		
FED. ROAD DIST. NO.	ILLINOIS	FED. AID PROJECT	
62583			

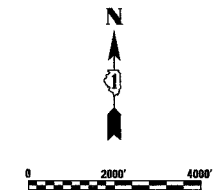

LEGEND		
FEATURE	SYMBOL-PROPOSED	SYMBOL-EXISTING
DYNAMIC MESSAGE SIGN		
SYSTEM DETECTOR STATION - RAMP		
SYSTEM DETECTOR STATION - SPOT		
SYSTEM DETECTOR STATION - FULL		
CCTV CAMERA ASSEMBLY		
FUTURE CAMERA LOCATION		NA
COMMUNICATION HUB		
RAMP METER SIGNAL HEAD		
HAR ANTENNA		
FLASHING BEACON SIGN		

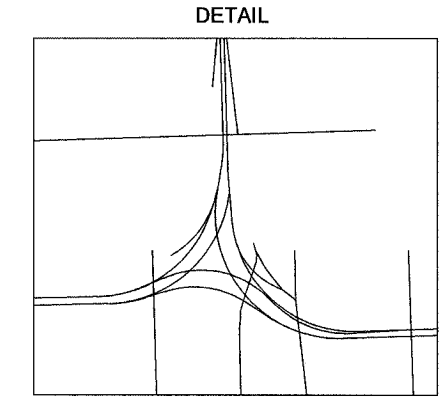

NOTE:

* DMS-03, DMS-31, DMS-32, DMS-04 ARE SHOWN IN THESE PLANS AS INSTALLED ON BUTTERFLY TRUSSES. SITE PLANS FOR THESE DRAWINGS WILL BE MODIFIED BY ADDENDUM TO SHOW TWO SIGNS AT EACH OF THESE LOCATIONS INSTALLED ON SEPARATE FULL SPAN TRUSSES. ONE SIGN WILL BE POSITIONED OVER THE EXPRESS LANES AND ONE OVER THE LOCAL LANES AT EACH LOCATION.

SYS-01

REVISIONS	
NAME	DATE
REVISED	1/21/05

ILLINOIS DEPARTMENT OF TRANSPORTATION
 F.A.I. 94/90 (DAN RYAN EXPRESSWAY)
 31st STREET to I-57

DYNAMIC MESSAGE SIGN SUBSYSTEM

SCALE: 1"=2000'
 DATE: October 29, 2004

DRAWN BY: CH
 CHECKED BY: MJL

Edwards AND Kelcey

ONE NORTH FRANKLIN
 CHICAGO, IL 60606
 PHONE: (312) 251-3000
 FAX: (312) 251-3015
 WEB: WWW.EKCORP.COM

F:\03009035\1\SCADD\SYSD020102.PE.SHT 01/24/2005 03:45:05 PM