


SECTION	COUNTY	TOTAL SHEETS	SHEET NO.
2003-0311	COOK	976	678
STA. 142+00/245+00/ 338+00/41+00	TO STA. 1204+00		
FED. ROAD DIST. NO.	ILLINOIS	FED. AID PROJECT	
62583			

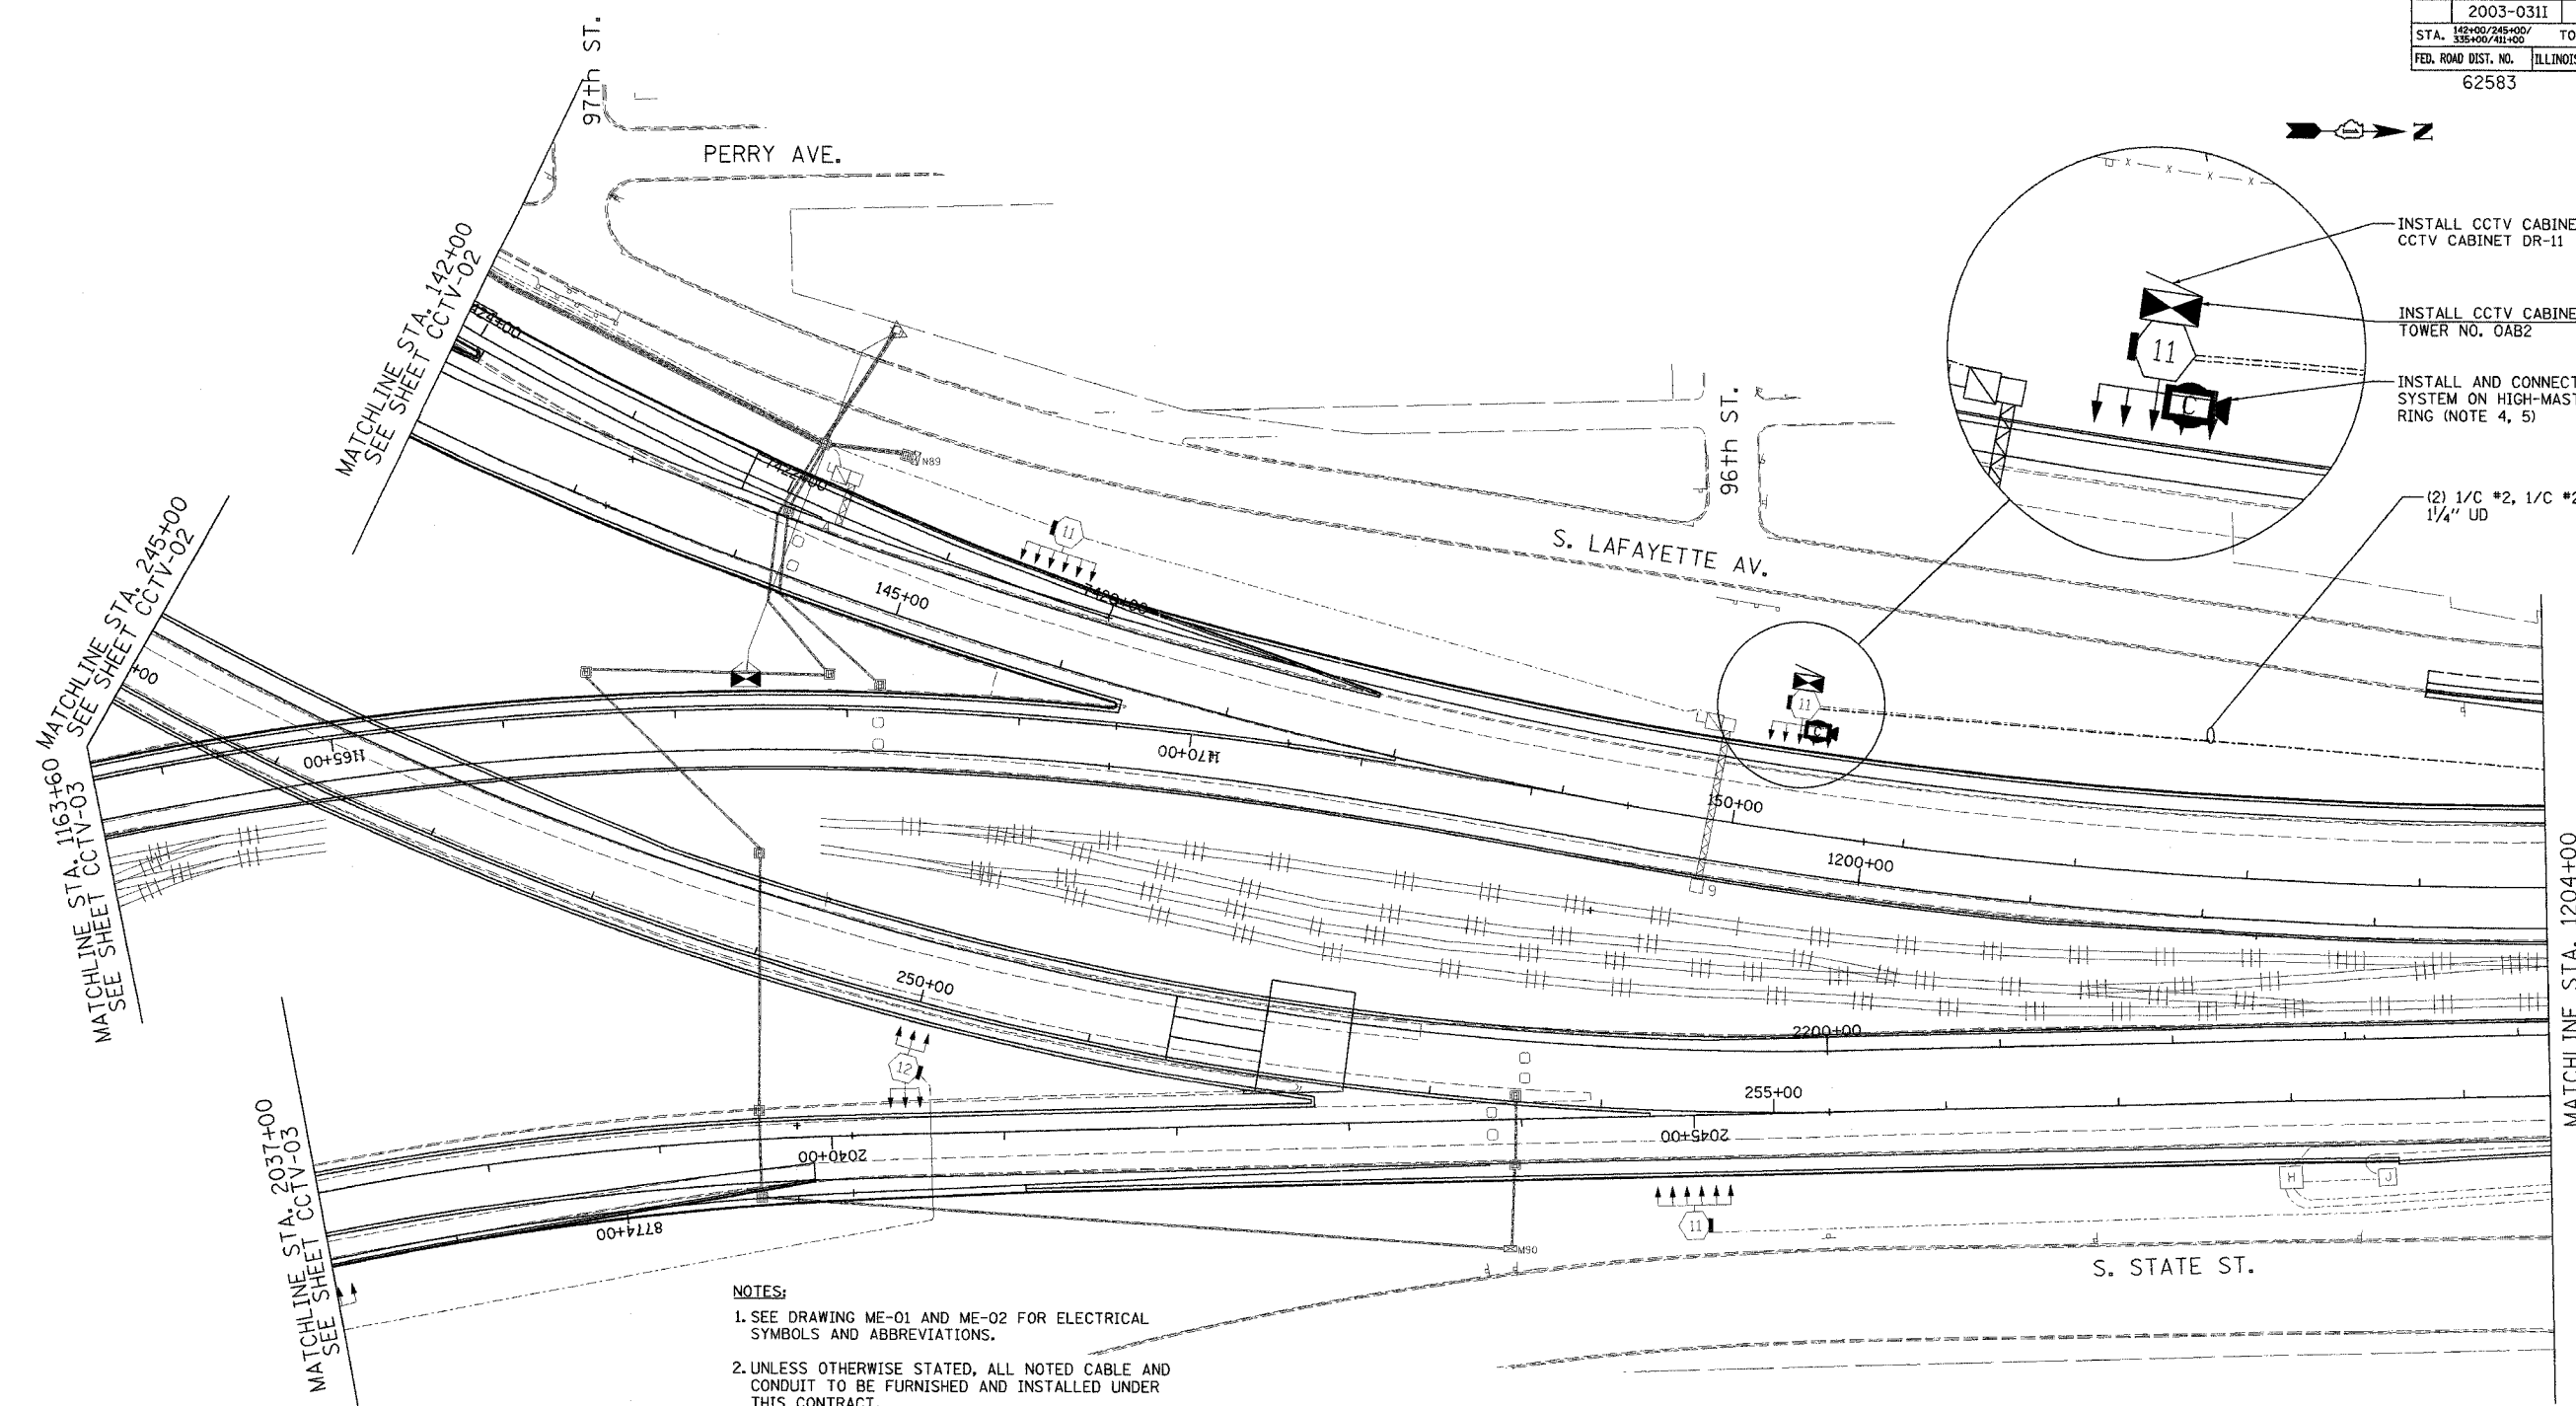

- INSTALL CCTV CABINET EQUIPMENT IN CCTV CABINET DR-11
- INSTALL CCTV CABINET DR-11 (NOTE 6) TOWER NO. OAB2
- INSTALL AND CONNECT CCTV CAMERA SYSTEM ON HIGH-MAST LIGHT TOWER RING (NOTE 4, 5)

 
(2) 1/C #2, 1/C #2 GND, 1/4" UD

MATCHLINE STA. 1163+60
MATCHLINE STA. 245+00
SEE SHEET CCTV-03
SEE SHEET CCTV-02

MATCHLINE STA. 2037+00
SEE SHEET CCTV-03

MATCHLINE STA. 1204+00
SEE SHEET CCTV-07

- NOTES:**
1. SEE DRAWING ME-01 AND ME-02 FOR ELECTRICAL SYMBOLS AND ABBREVIATIONS.
 2. UNLESS OTHERWISE STATED, ALL NOTED CABLE AND CONDUIT TO BE FURNISHED AND INSTALLED UNDER THIS CONTRACT.
 3. THIS SHEET ONLY DEPICTS INSTALLATION OF CLOSED CIRCUIT TELEVISION ELEMENTS. SEE LIGHTING PLANS FOR LIGHTING ELEMENT INSTALLATION.
 4. SUPPORT ARM OF THE CCTV DOME CAMERA SHALL BE INSTALLED ON THE EXPRESSWAY SIDE OF THE HIGH-MAST LIGHT TOWER RING AS SHOWN ON DETAIL DRAWING DT-17. THE ARM SHALL BE PERPENDICULAR TO BOTH THE HIGH-MAST LIGHT TOWER RING AND THE CENTERLINE OF THE EXPRESSWAY OR AS DIRECTED BY THE ENGINEER.
 5. SEE DRAWING CCTV-09 FOR CCTV COMMUNICATIONS SYSTEM CONDUIT AND CABLE LAYOUT.
 6. SEE DRAWING DT-17 FOR CCTV CABINET MOUNTING DETAILS ON A HIGH-MAST LIGHT TOWER.



CCTV-06

Edwards AND Kelcey
 ONE NORTH FRANKLIN
 CHICAGO, IL 60606
 PHONE: (312) 251-3000
 FAX: (312) 251-3015
 WEB: WWW.EKCORP.COM

REVISIONS	
NAME	DATE

ILLINOIS DEPARTMENT OF TRANSPORTATION
 F.A.I. 94/90 (DAN RYAN EXPRESSWAY)
 31st STREET TO I-57
 CLOSED CIRCUIT TELEVISION
 SITE LAYOUT
 CAMERA DR-11 (SHEET 1 OF 4)
 SCALE: 1"=50'
 DATE: October 29, 2004
 DRAWN BY: DHI
 CHECKED BY: MJL

A:030009.035\15\cadd\cctv\0206e.ctb 09/22/04 07:14:2004 AM