 

 


|                     |                 |                  |           |
|---------------------|-----------------|------------------|-----------|
| SECTION             | COUNTY          | TOTAL SHEETS     | SHEET NO. |
| 2003-0311           | COOK            | 976              | 679       |
| STA. 1204+00        | TO STA. 1217+00 |                  |           |
| FED. ROAD DIST. NO. | ILLINOIS        | FED. AID PROJECT |           |
| 62583               |                 |                  |           |

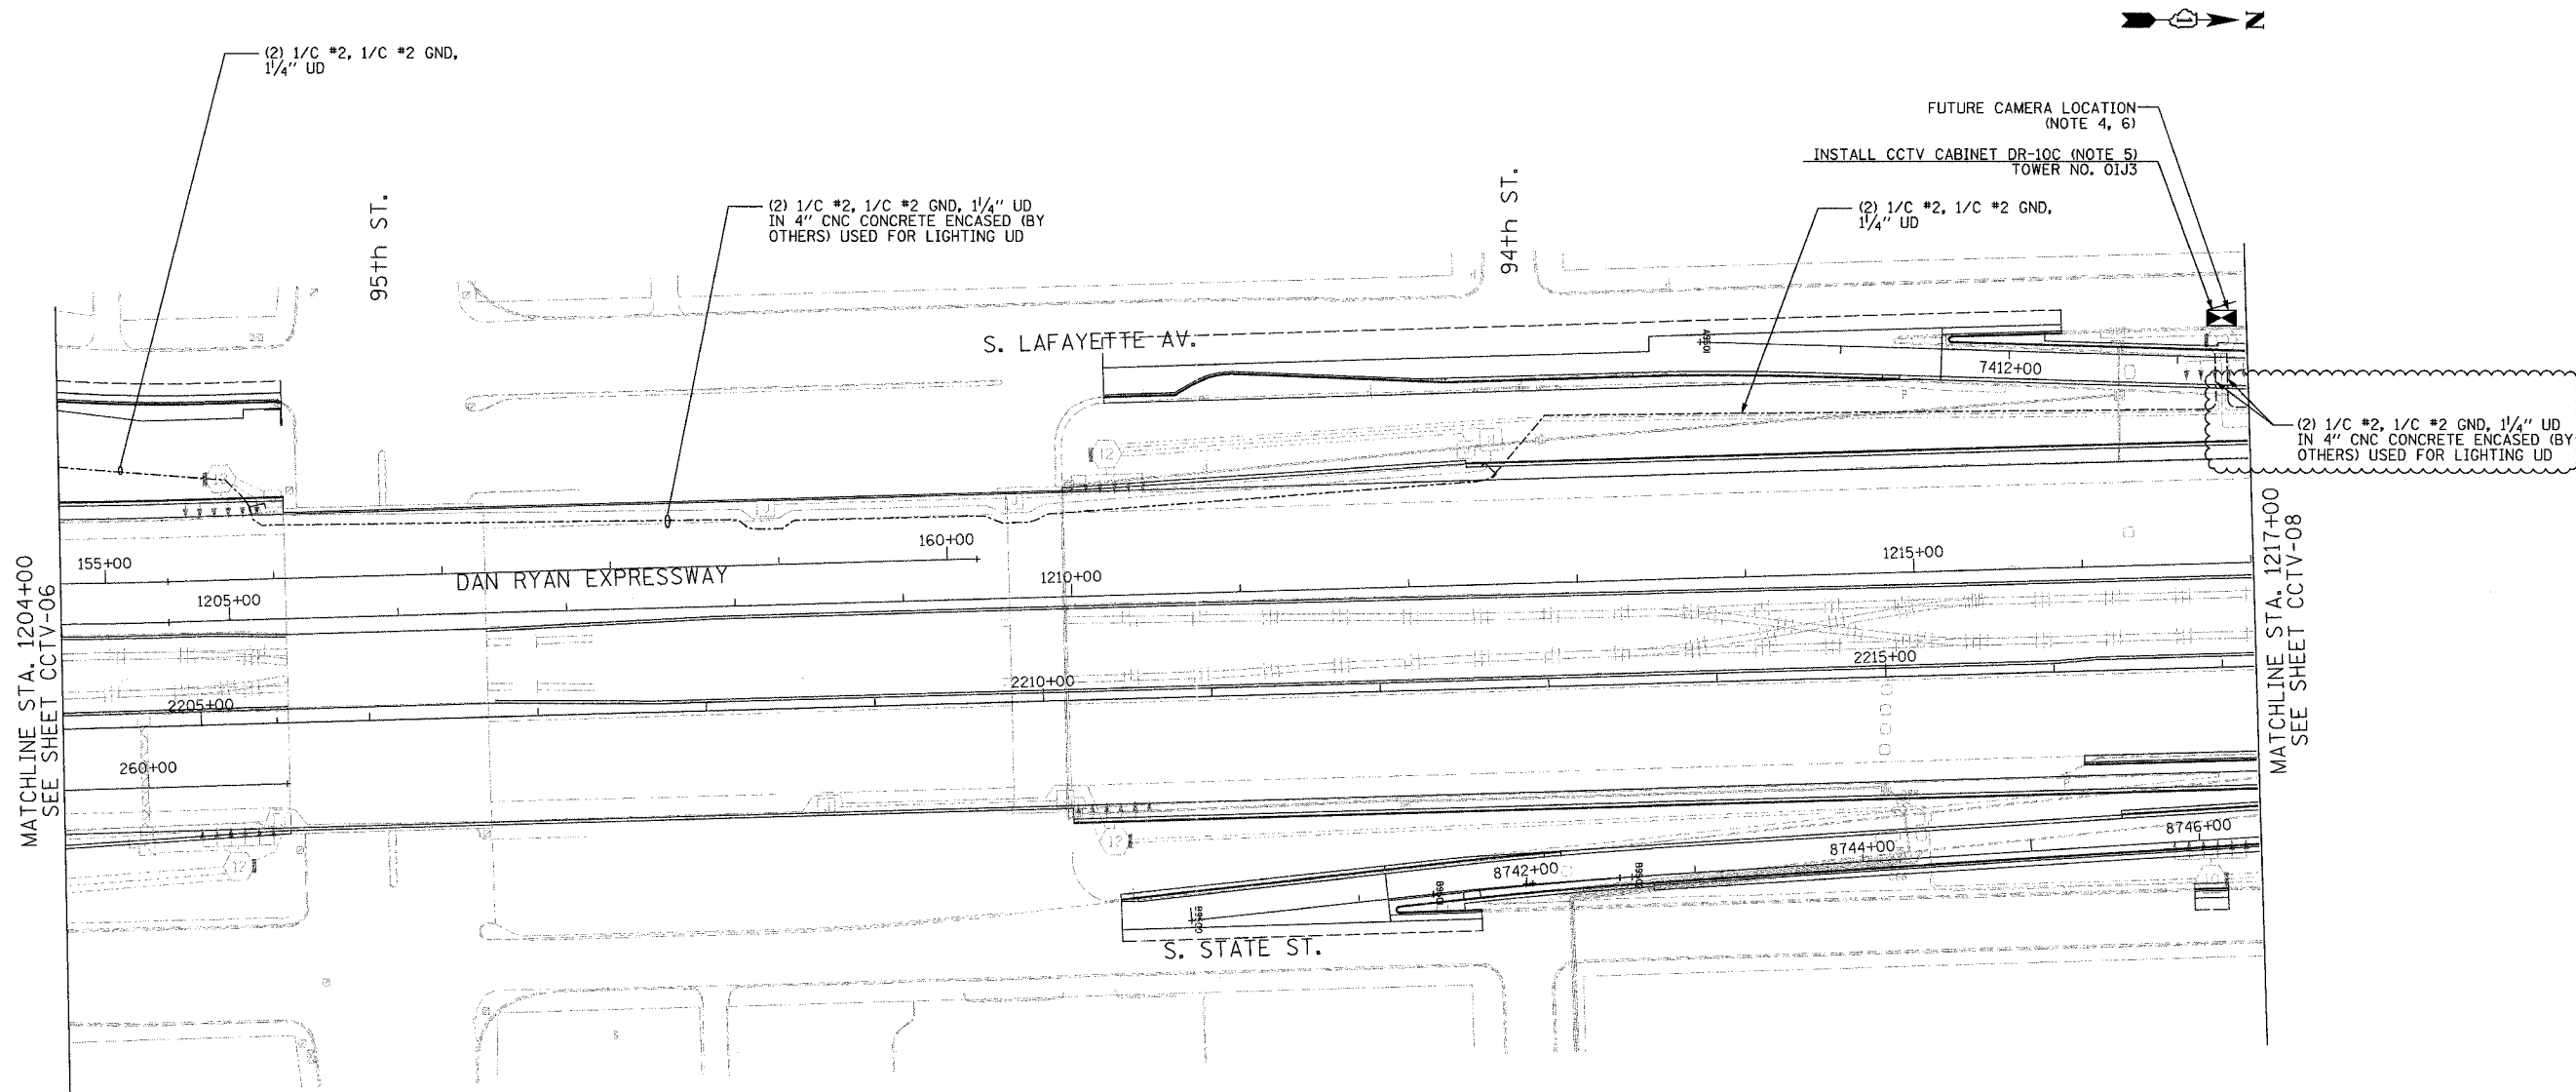

- NOTES:**
- SEE DRAWINGS ME-01 AND ME-02 FOR ELECTRICAL SYMBOLS AND ABBREVIATIONS.
  - UNLESS OTHERWISE STATED, ALL NOTED CABLE AND CONDUIT TO BE FURNISHED AND INSTALLED UNDER THIS CONTRACT.
  - THIS SHEET ONLY DEPICTS INSTALLATION OF CLOSED CIRCUIT TELEVISION ELEMENTS. SEE LIGHTING PLANS FOR LIGHTING ELEMENT INSTALLATION.
  - SEE DRAWING COMM-10 FOR CCTV COMMUNICATIONS SYSTEM CONDUIT AND CABLE LAYOUT.
  - SEE DRAWING DT-17 FOR CCTV CABINET MOUNTING DETAILS ON A HIGH-MAST LIGHT TOWER.
  - CONTRACTOR SHALL SPLICE (2) 1/C #2, 1/C #2 GND IN CCTV CABINET DR-10C FOR CABINET DR-11 POWER FEED. SEE DRAWING CCTV-06 FOR CONTINUATION.



CCTV-07

**Edwards AND Kelcey**  
 ONE NORTH FRANKLIN  
 CHICAGO, IL 60606  
 PHONE: (312) 251-3000  
 FAX: (312) 251-3015  
 WEB: WWW.EKCORP.COM

| REVISIONS  |          |
|------------|----------|
| NAME       | DATE     |
| REVISION 1 | 12/17/04 |
|            |          |
|            |          |
|            |          |
|            |          |
|            |          |
|            |          |
|            |          |
|            |          |

ILLINOIS DEPARTMENT OF TRANSPORTATION  
 F.A.I. 94/90 (DAN RYAN EXPRESSWAY)  
 31st STREET TO I-57  
 CLOSED CIRCUIT TELEVISION  
 SITE LAYOUT  
 CAMERA DR-11 (SHEET 2 OF 4)  
 CAMERA DR-10C (SHEET 1 OF 3)  
 SCALE: 1"=50'  
 DATE: October 29, 2004  
 DRAWN BY: DHI  
 CHECKED BY: MJL

P:\030009\0311\T\S\CADD\CCTV\0207\0212.SHT 12/10/2004 10:11:21 AM