
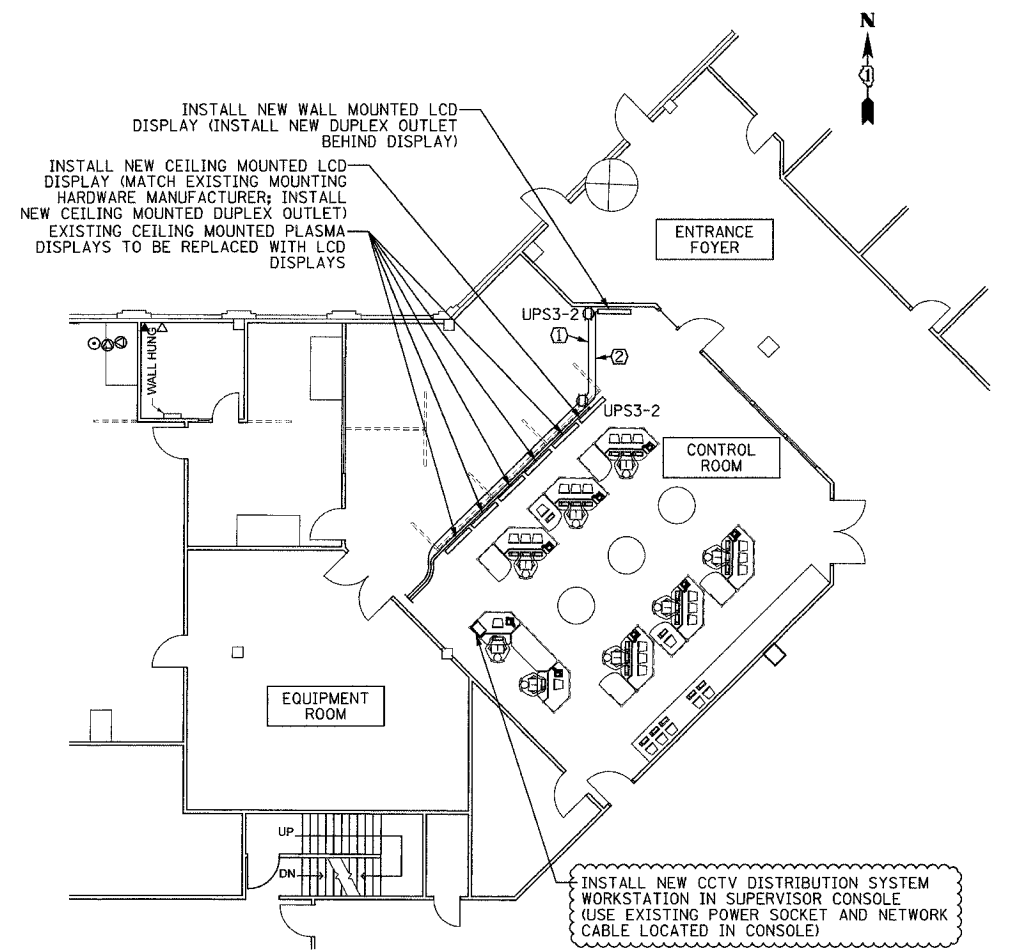


SECTION	COUNTY	TOTAL SHEETS	SHEET NO.
2003-031I	COOK	976	867
STA.	TO STA.		
FED. ROAD DIST. NO.	ILLINOIS	FED. AID PROJECT	
62583			

- NOTES:**
- EQUIPMENT LOCATIONS ARE BASED ON CURRENT CONDITIONS AND ARE ANTICIPATED TO CHANGE. THE CONTRACTOR SHALL COORDINATE THE ACTUAL LOCATION OF NEW EQUIPMENT WITH SITE PERSONNEL, SUBJECT TO THE APPROVAL OF THE ENGINEER. THE CONTRACTOR SHOULD ANTICIPATE THAT CHANGES TO THE LOCATION DO NOT AFFECT OVERALL SCOPE OF WORK OR MATERIALS FURNISHED.
 - CONTRACTOR SHALL PROVIDE ADDITIONAL CABLE TO MOVE RACKS FORWARD TO PROVIDE ACCESS TO REAR OF CABINET.
 - MOBILE SYSTEM TESTER TO BE RELOCATED BY IDOT.
- ① (2) #12 & (1) #12 GND, 3/4" C
 ② PLENUM RATED COAX CABLE
 ③ PLENUM RATED CAT-5 CABLE

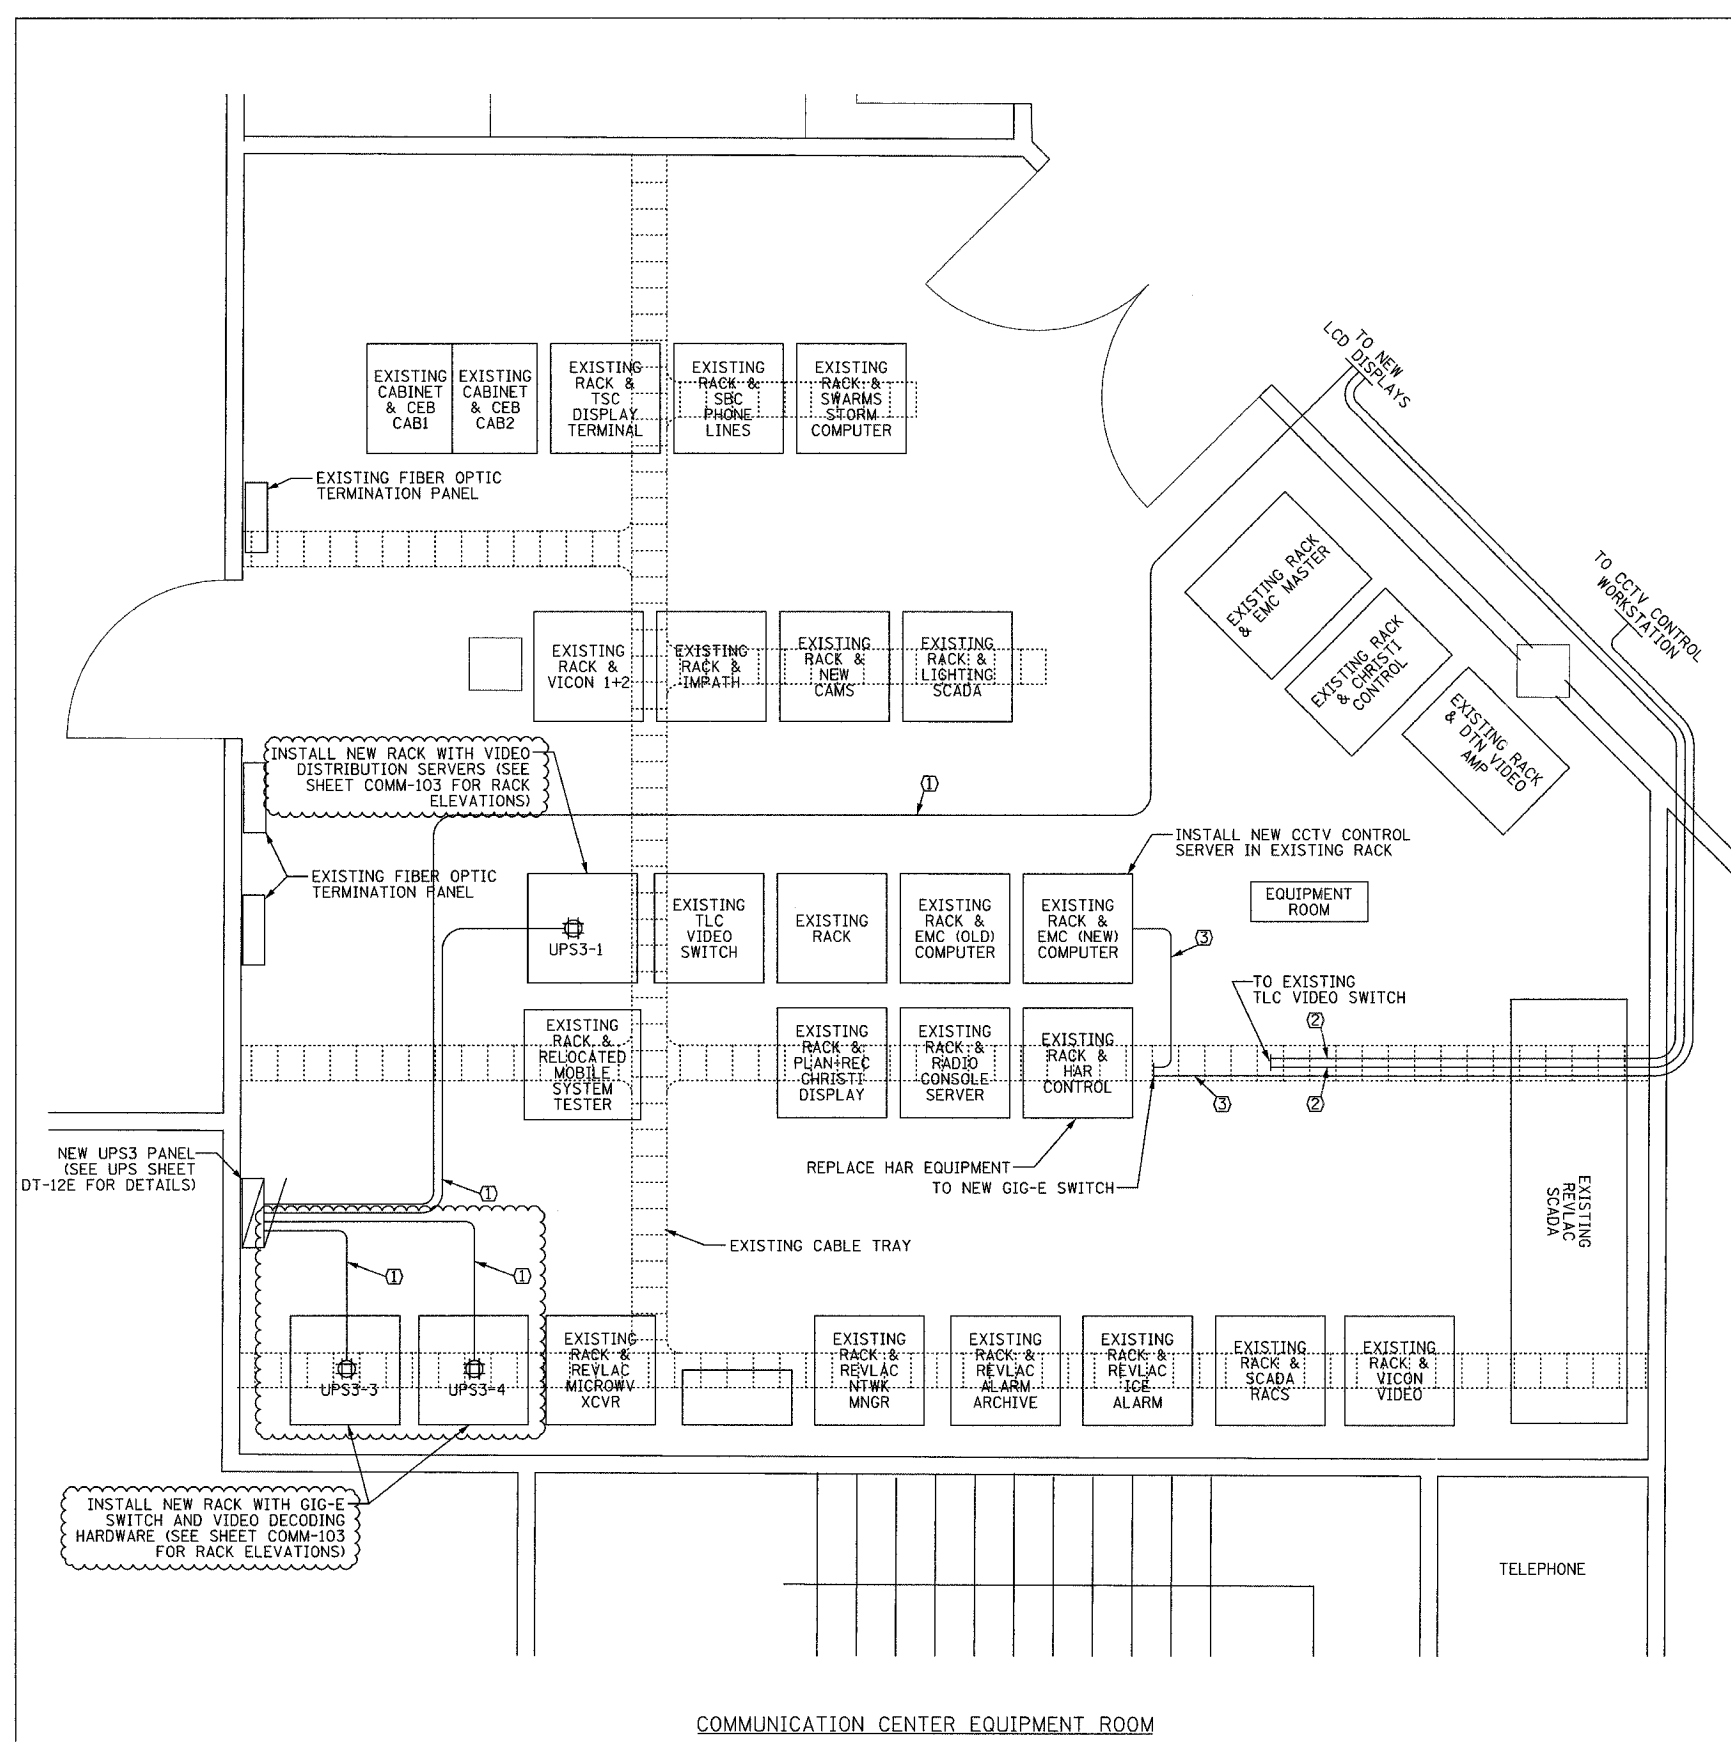

COMMUNICATION CENTER MAIN FLOOR
 COMM-101

REVISIONS		ILLINOIS DEPARTMENT OF TRANSPORTATION F.A.I. 94/90 (DAN RYAN EXPRESSWAY) 31st STREET to I-57
NAME	DATE	
REVISION 1	12/17/04	COMMUNICATIONS CENTER (SCHAUMBURG) SITE PLAN

SCALE: NOT TO SCALE
 DATE: October 29, 2004
 DRAWN BY: DHI
 CHECKED BY: JEZ

Edwards AND Kelcey
 ONE NORTH FRANKLIN
 CHICAGO, IL 60606
 PHONE: (312) 251-3000
 FAX: (312) 251-3015
 WEB: WWW.EDKCORP.COM

P:\030019\03015\19s\coord\0302003025a.dwg 12/15/2004 01:51:47 PM