



F.A.I. RTE.	SECTION	COUNTY	TOTAL SHEETS	SHEET NO.
94/90	2003-0311	COOK	976	868
STA.	TO STA.			
FED. ROAD DIST. NO.	ILLINOIS	FED. AID PROJECT		
62583				

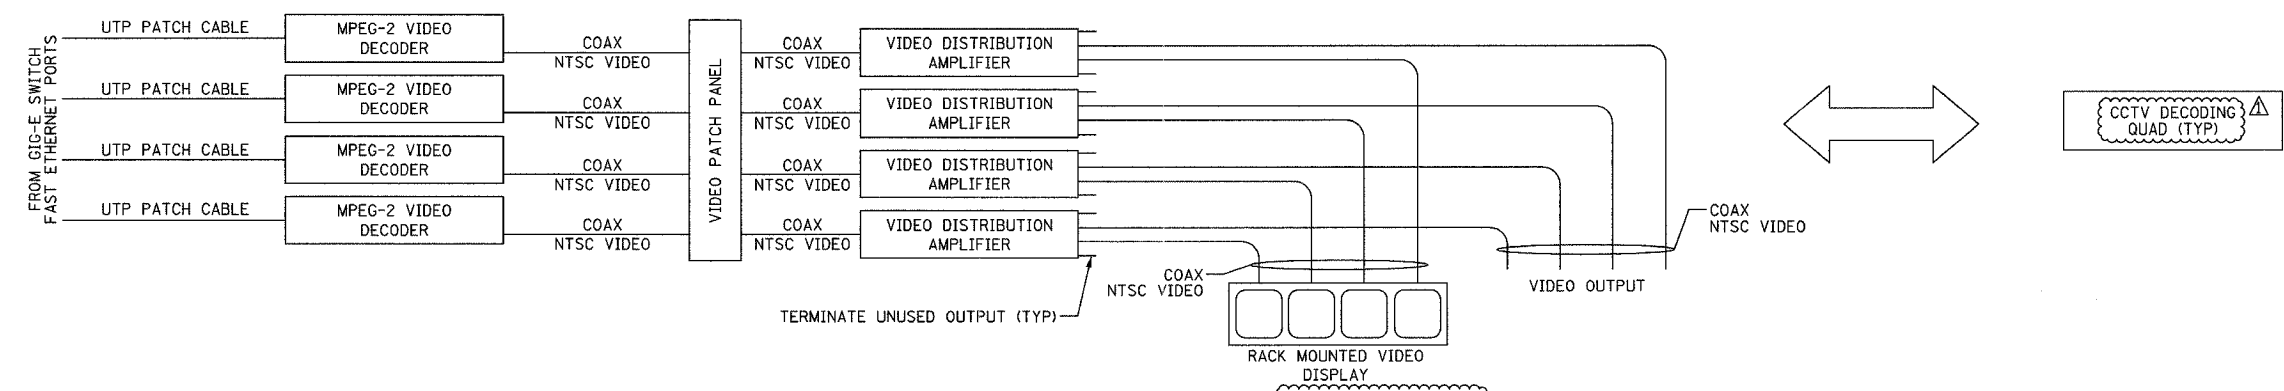

ONE-LINE DIAGRAM FOR CCTV DECODING QUAD
NOT TO SCALE

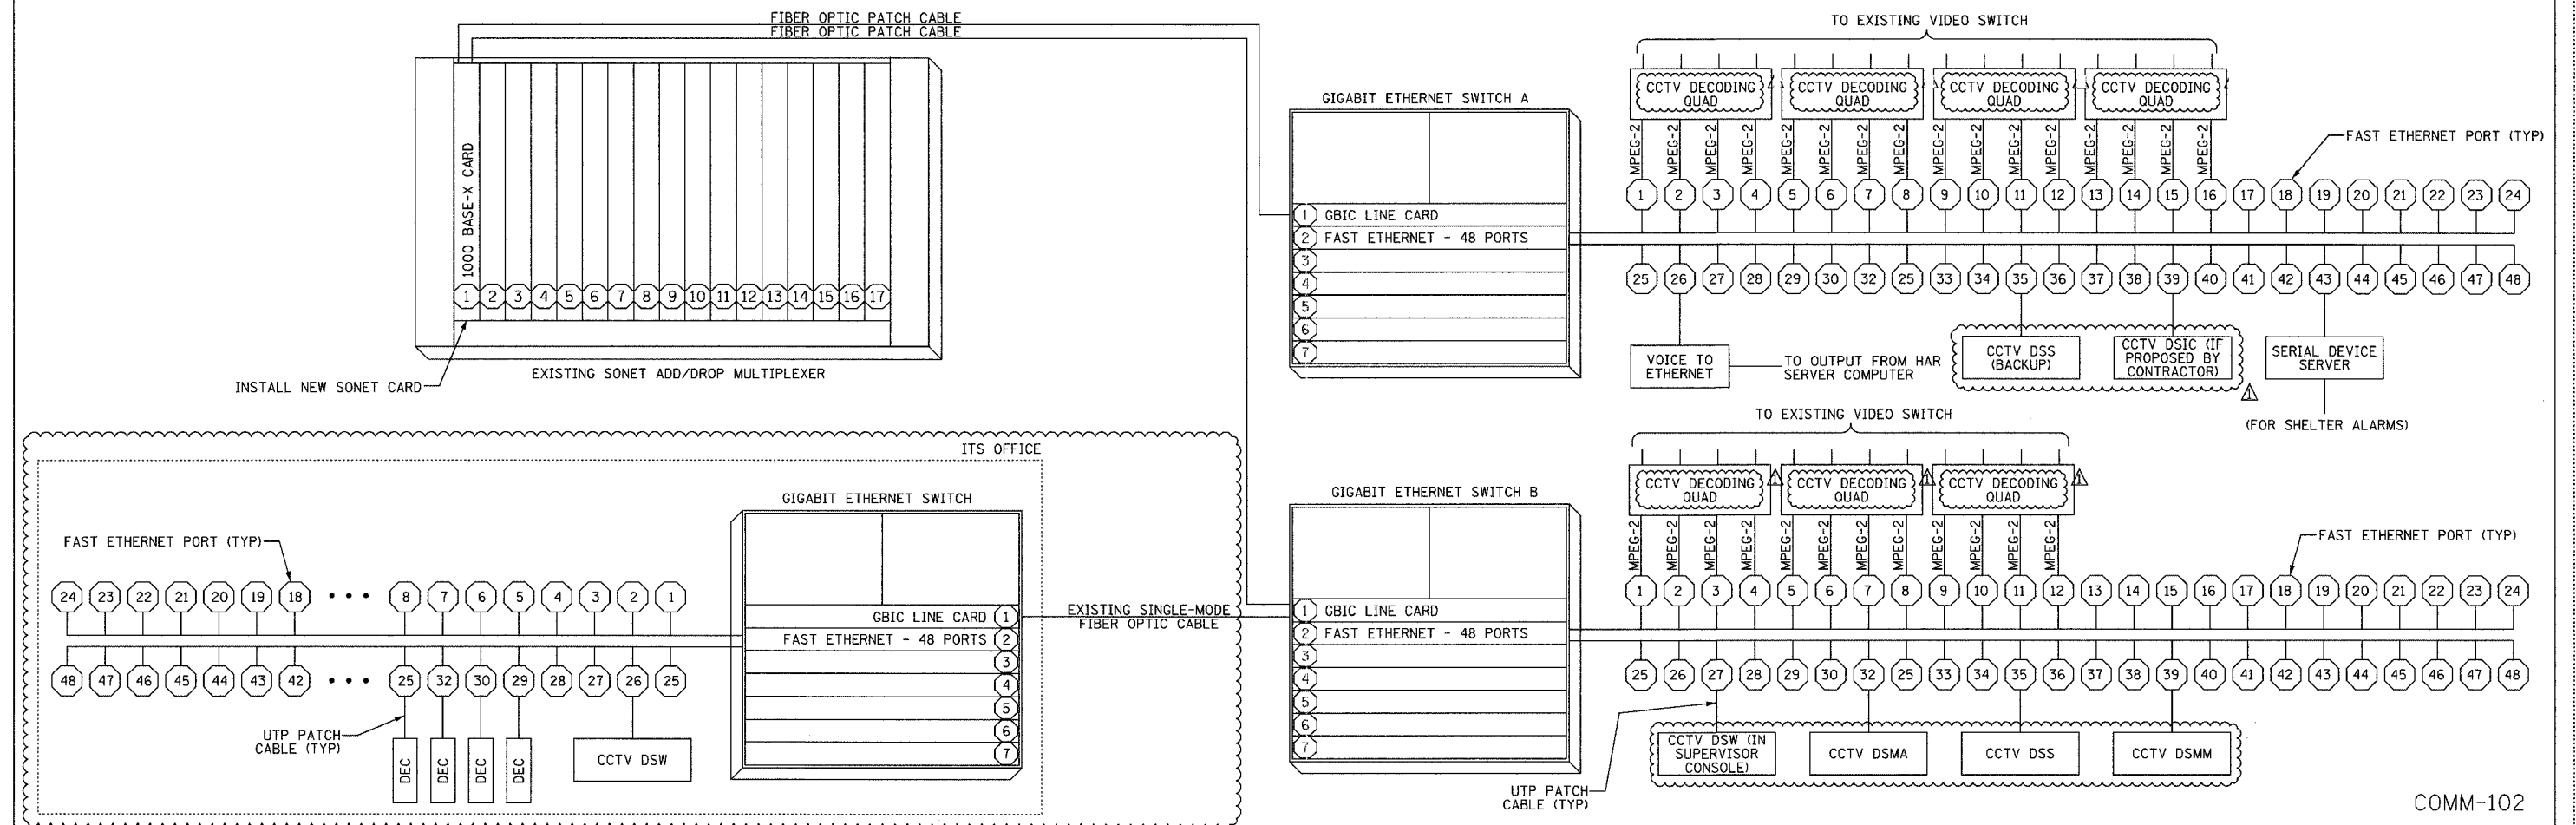

EQUIPMENT INTERCONNECT DIAGRAM
NOT TO SCALE

- NOTES:**
1. THIS DRAWING IS FOR REFERENCE ONLY AND PROVIDES AN OVERVIEW OF THE CCTV EQUIPMENT INTERCONNECTS AT THE COMMUNICATION SHELTER.
 2. CONTRACTOR SHALL PROVIDE NECESSARY POWER CONNECTIONS TO THE EQUIPMENT.
 3. EACH CCTV DECODING QUAD SHALL BE FULLY EQUIPPED WITH ALL HARDWARE.

LEGEND:

DEC	MPEG-2 DECODER
DSIC	DISTRIBUTION SYSTEM IMAGE CAPTURE
DSMA	DISTRIBUTION SYSTEM VIDEO MANAGEMENT & ARCHIVING
DSMM	DISTRIBUTION SYSTEM MAINTENANCE MONITOR
DSS	DISTRIBUTION SYSTEM SERVER
DSW	DISTRIBUTION SYSTEM WORKSTATION

REVISIONS

NAME	DATE
REVISION 1	12/17/04

ILLINOIS DEPARTMENT OF TRANSPORTATION
F.A.I. 94/90 (DAN RYAN EXPRESSWAY)
31st STREET to I-57

SCHAUBURG COMMUNICATION CENTER
EQUIPMENT WIRING DIAGRAM

SCALE: NOT TO SCALE
DATE: October 29, 2004
DRAWN BY: DHI
CHECKED BY: JEZ

Edwards AND Kelcey
ONE NORTH FRANKLIN
CHICAGO, IL 60606
PHONE: (312) 251-3000
FAX: (312) 251-3015
WEB: WWW.EKCORP.COM

12/15/2004 01:52:45 PM