
 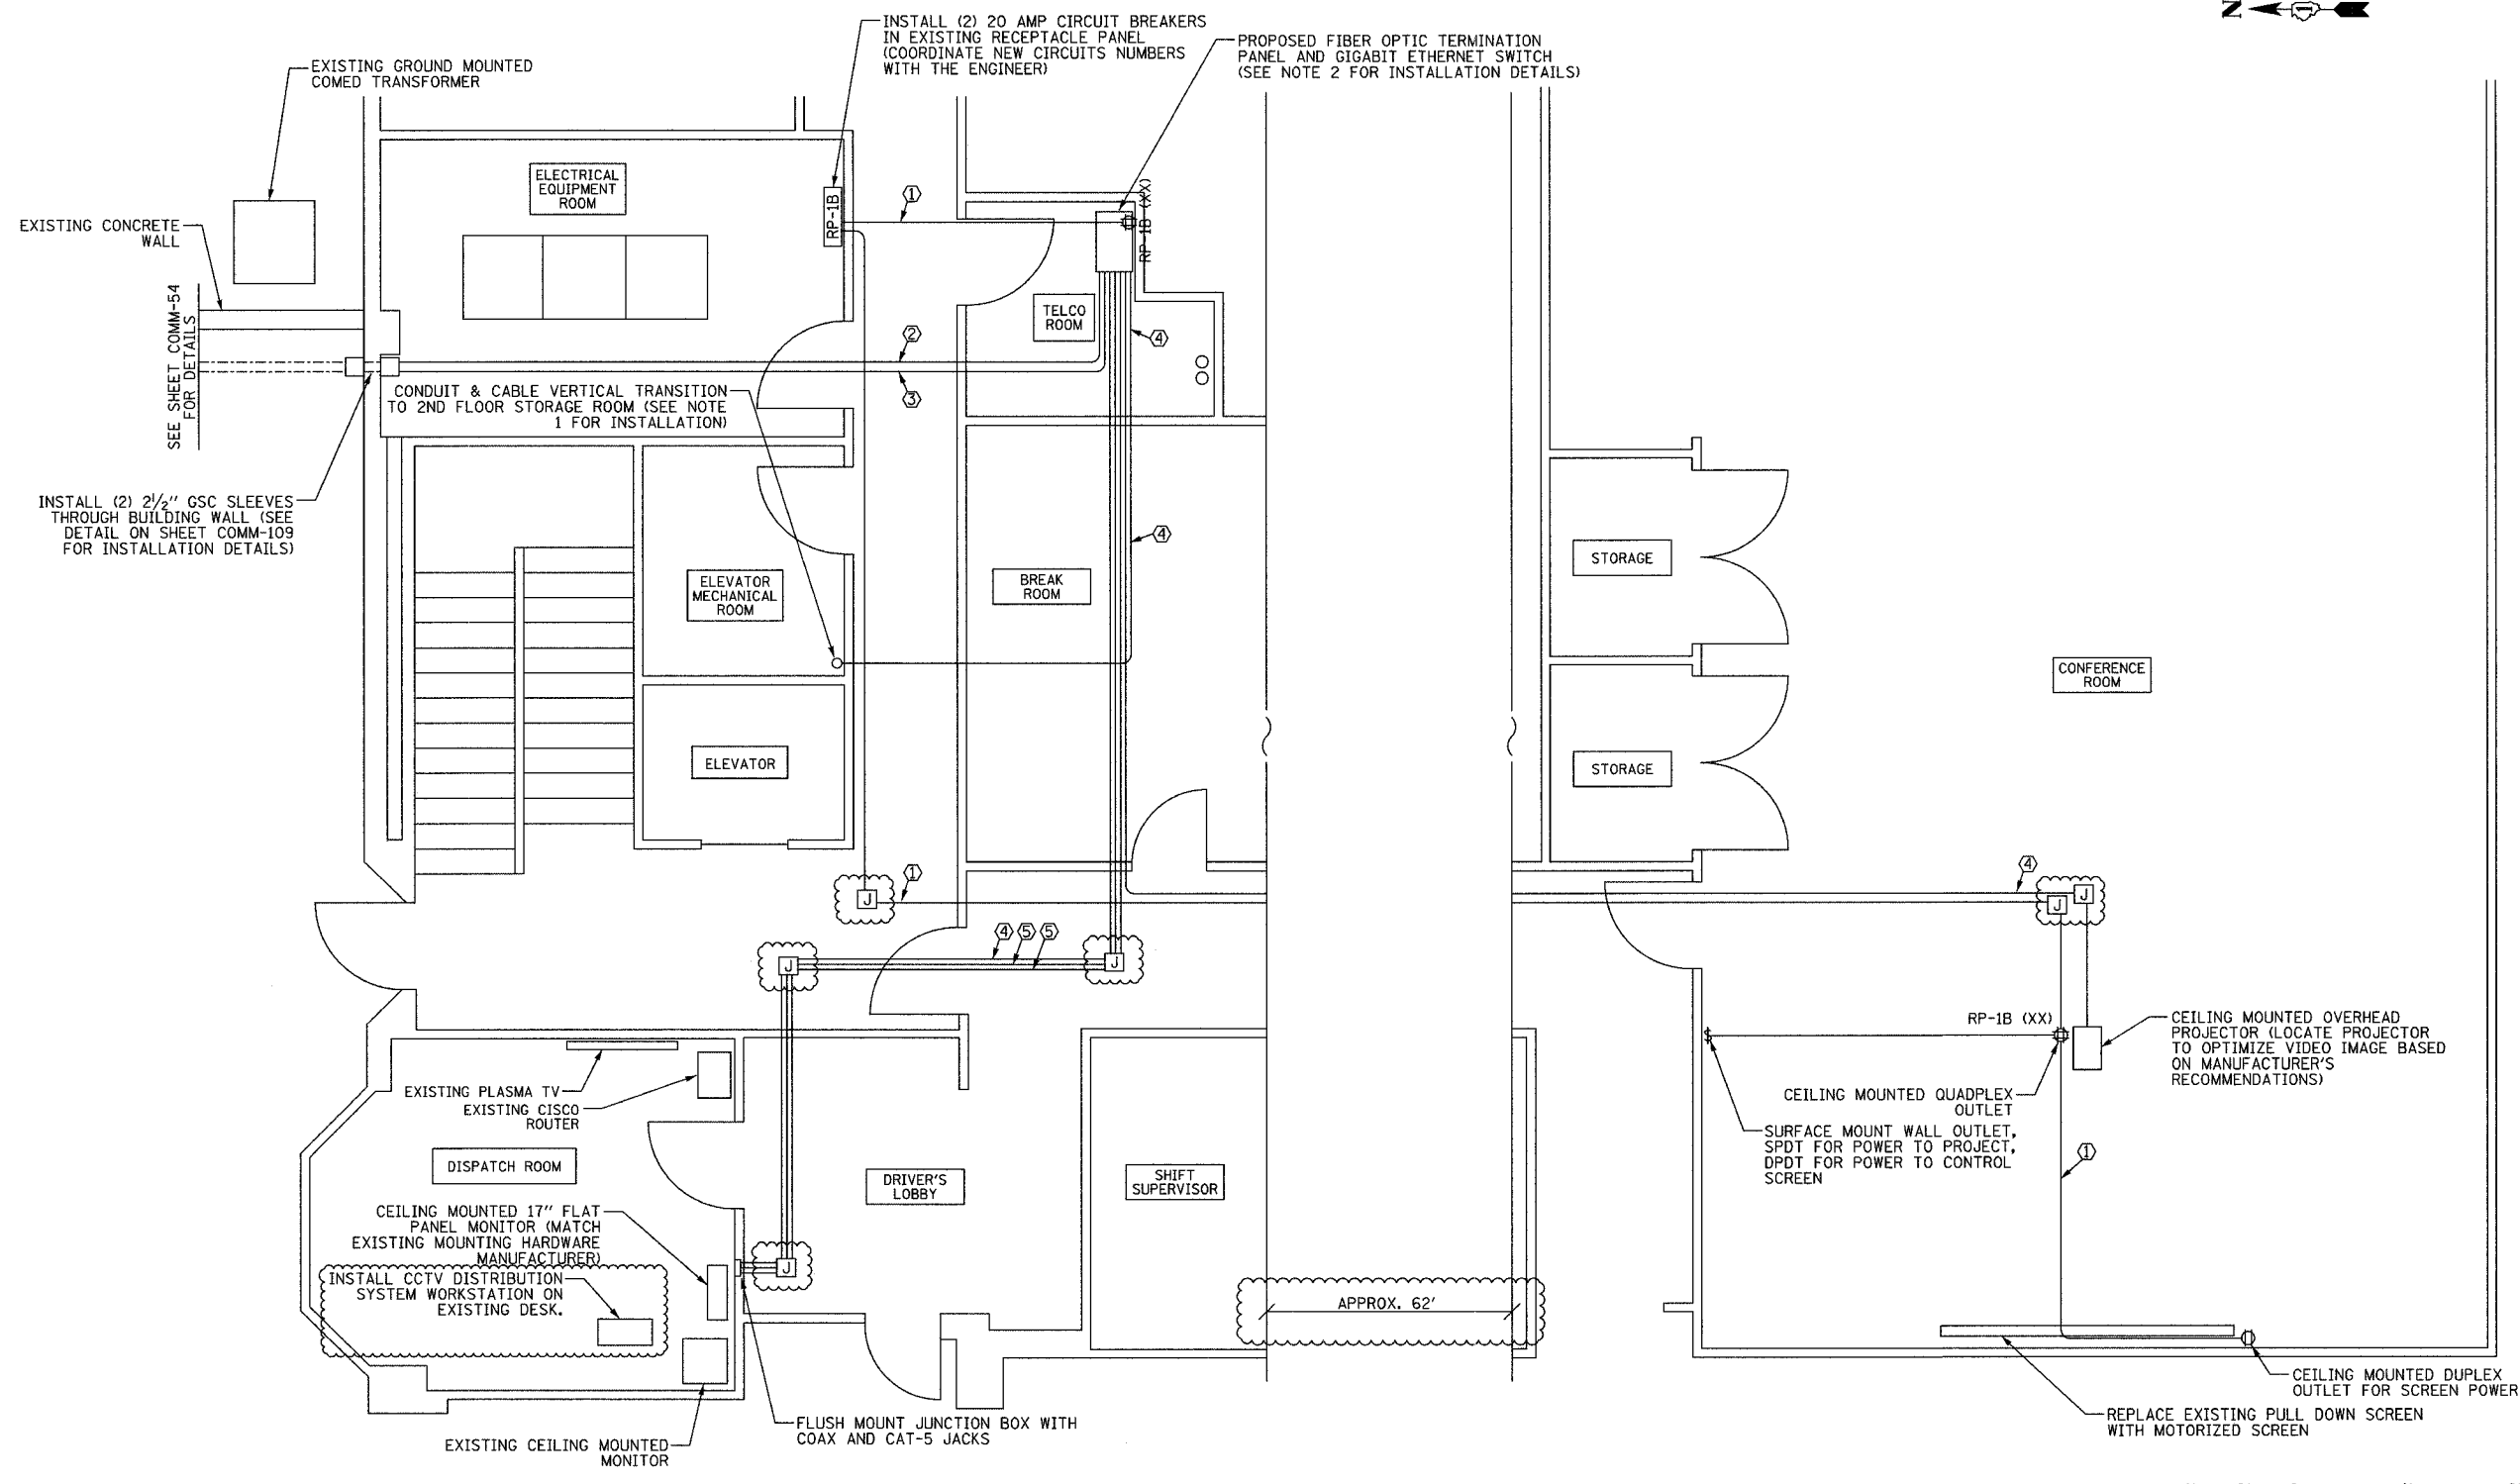


SECTION	COUNTY	TOTAL SHEETS	SHEET NO.
2003-031I	COOK	976	873
STA.	TO STA.		
FED. ROAD DIST. NO.	ILLINOIS	FED. AID PROJECT	
62583			



PARTIAL FIRST FLOOR PLAN  
NOT TO SCALE

- NOTES:**
- CONTRACTOR SHALL COORDINATE WITH EMERGENCY TRAFFIC PATROL (ETP) BUILDING ENGINEER PRIOR TO PERFORMING ANY WORK. CONTRACTOR SHALL COORDINATE THE CONDUIT AND CABLE ROUTING WITHIN THE ETP BUILDING.
  - CONTRACTOR SHALL INSTALL NEW COMMUNICATION EQUIPMENT IN WALL MOUNTED EQUIPMENT RACK. SEE SHEET COMM-109 FOR EQUIPMENT ELEVATION DETAILS.
  - WHEN POSSIBLE, CONTRACTOR SHALL CONCEAL CABLE AND CONDUIT INSTALLATION IN CEILING SPACE.

- CABLE/CONDUIT IDENTIFIERS**
- ① (2) #12 AND (1) #12 GND, 3/4" EMT
  - ② 24-FIBER OPTIC CABLE, 2" EMT
  - ③ SPARE, 2" EMT
  - ④ COAX CABLE
  - ⑤ UTP CAT-5 CABLE

REVISIONS	
NAME	DATE
REVISION 1	12/17/04

ILLINOIS DEPARTMENT OF TRANSPORTATION  
F.A.I. 94/90 (DAN RYAN EXPRESSWAY)  
31st STREET to I-57

EMERGENCY TRAFFIC PATROL (ETP)  
SITE PLAN

SCALE: NOT TO SCALE  
DATE: October 29, 2004

DRAWN BY: DHI  
CHECKED BY: JEZ

**Edwards AND Kelcey**  
ONE NORTH FRANKLIN  
CHICAGO, IL 60606  
PHONE: (312) 251-3000  
FAX: (312) 251-3015  
WEB: WWW.EDKORP.COM

P:\030010\035\10\1000\1000.dwg 12/15/2004 01:52:28 PM