
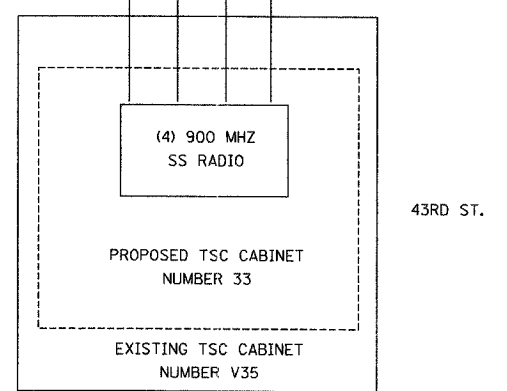
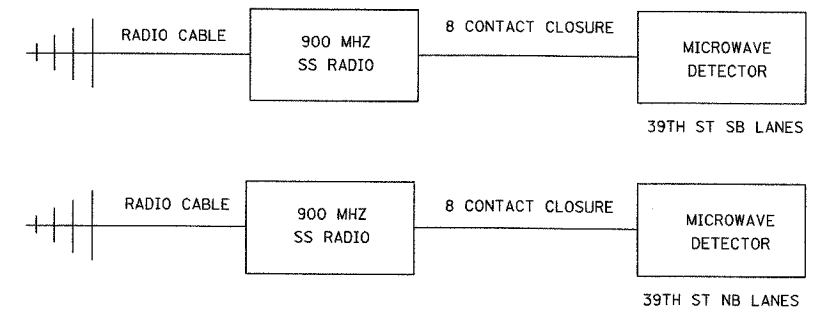
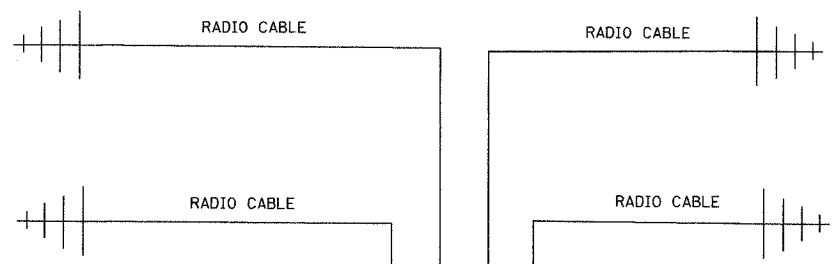
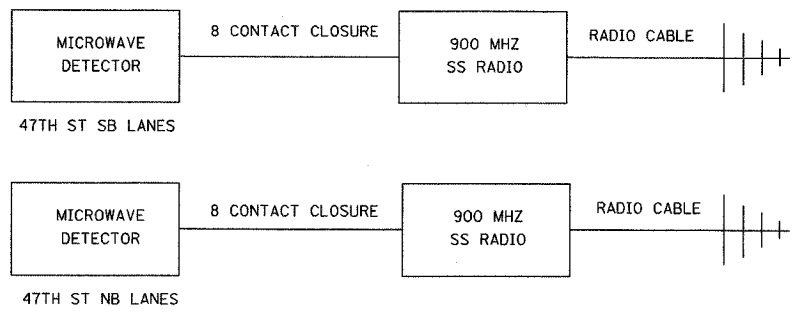
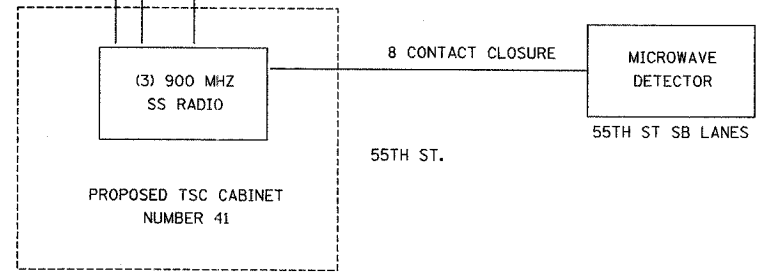
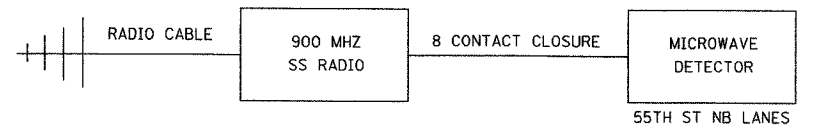
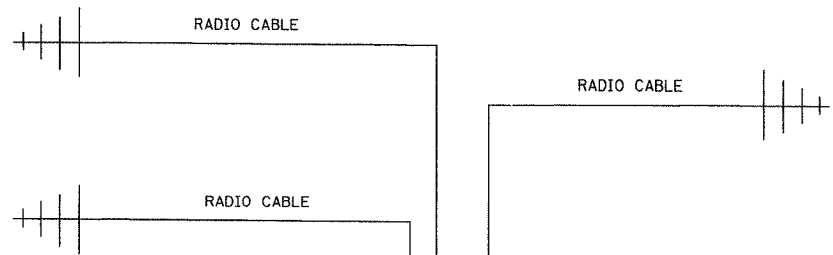


F.A.I. RTE.	SECTION	COUNTY	TOTAL SHEETS	SHEET NO.
94/90	2003-031I	COOK	976	294
STA.		TO STA.		
FED. ROAD DIST. NO. 62583		ILLINOIS FED. AID PROJECT		

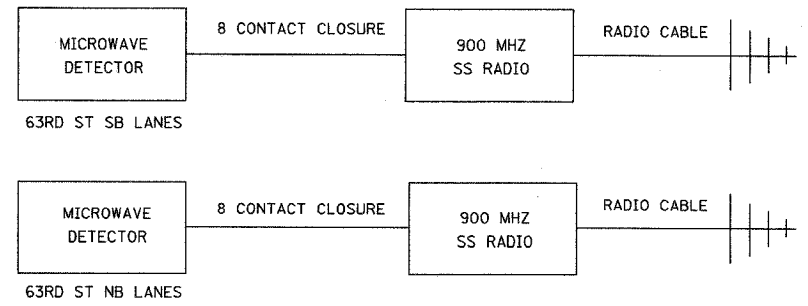

- NOTE:
- SEE SHEETS DT-53, DT-54, DT-55 FOR SITE INSTALLATION DETAILS.
 - EXISTING TSC CABINETS TO BE UTILIZED UNTIL REMOVAL.

REVISIONS	
NAME	DATE

ILLINOIS DEPARTMENT OF TRANSPORTATION
 F.A.I. 94/90 (DAN RYAN EXPRESSWAY)
 31st STREET to I-57
 TEMPORARY DETECTION
 COMMUNICATIONS LAYOUT
 (Sheet 2 of 3)
 SCALE: N.T.S. DRAWN BY: DHI
 DATE: October 29, 2004 CHECKED BY: JEZ

Edwards AND Kelcey
 ONE NORTH FRANKLIN
 CHICAGO, IL 60606
 PHONE: (312) 251-3000
 FAX: (312) 251-3015
 WEB: WWW.EKCORP.COM

COMM-128

P:\03009\035\16\cad\040203\262a.dwg 10/19/2004 04:49:00 PM