

F.A.I. RTE.	SECTION	COUNTY	TOTAL SHEETS	SHEET NO.
90/94	2004-069RS	COOK	61	31
STA. 576+75		TO STA. 581+75		
FED. ROAD DIST. NO. 1		ILLINOIS		FED. AID PROJECT

62808

LEGEND: EXISTING

- INLET
- CATCH BASIN
- MANHOLE
- STORM SEWER
- COMBINED SEWER
- PIPE UNDERDRAIN
- [R] STRUCTURE TO BE REMOVED
- [AD] STRUCTURE TO BE ADJUSTED
- //// STORM SEWER REMOVAL
- //// COMBINED SEWER REMOVAL

NOTE:  
ALL EXISTING OPEN LID DRAINAGE STRUCTURES TO REMAIN THRU STAGE 2 OF CONTRACT 62586 SHALL HAVE INLET FILTERS INSTALLED.

EXISTING CONDITIONS AND REMOVAL

PROPOSED IMPROVEMENTS

- INLET
- CATCH BASIN
- MANHOLE
- STORM SEWER
- COMBINED SEWER
- PIPE UNDERDRAIN
- PROPOSED SWALE
- EA 01 PROPOSED STORM SEWER PIPE
- △ EA 01 PROPOSED STRUCTURE
- WORK TO BE DONE BY OTHERS
- ◆ INLET FILTERS
- HANDHOLE



NOTES:  
1. SEE DRAINAGE SCHEDULES FOR STRUCTURE AND PIPE INFORMATION.  
2. INLET FILTERS TO BE INSTALLED ON ALL PROP. DRAINAGE STR.

REVISIONS	
NAME	DATE

ILLINOIS DEPARTMENT OF TRANSPORTATION  
F.A.I. 90/94 (DAN RYAN EXPRESSWAY)  
53rd ST TO 51st ST (WELLS STREET)

DRAINAGE AND UTILITY PLANS  
WELLS STREET

SCALE: 1"=20'  
DATE: December 17, 2004  
DRAWN BY: PHP  
CHECKED BY: JB

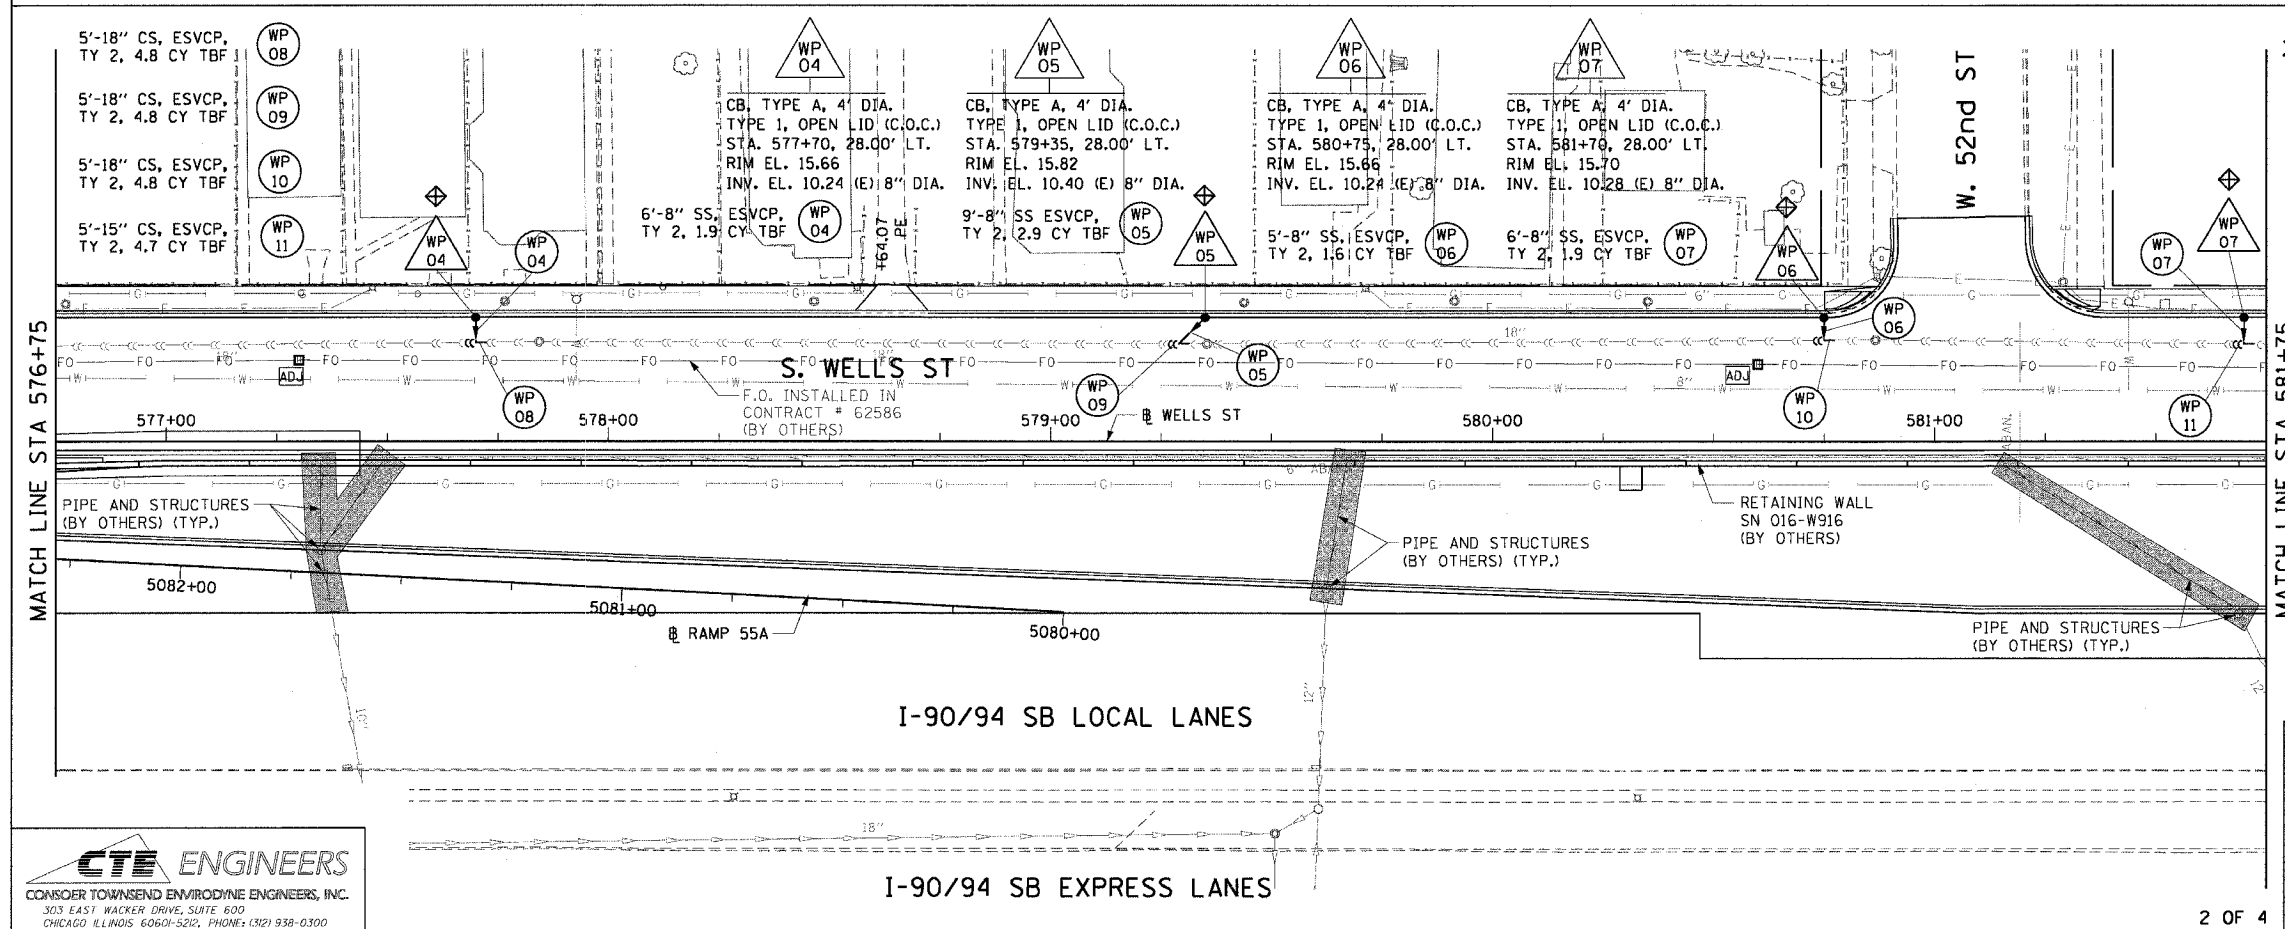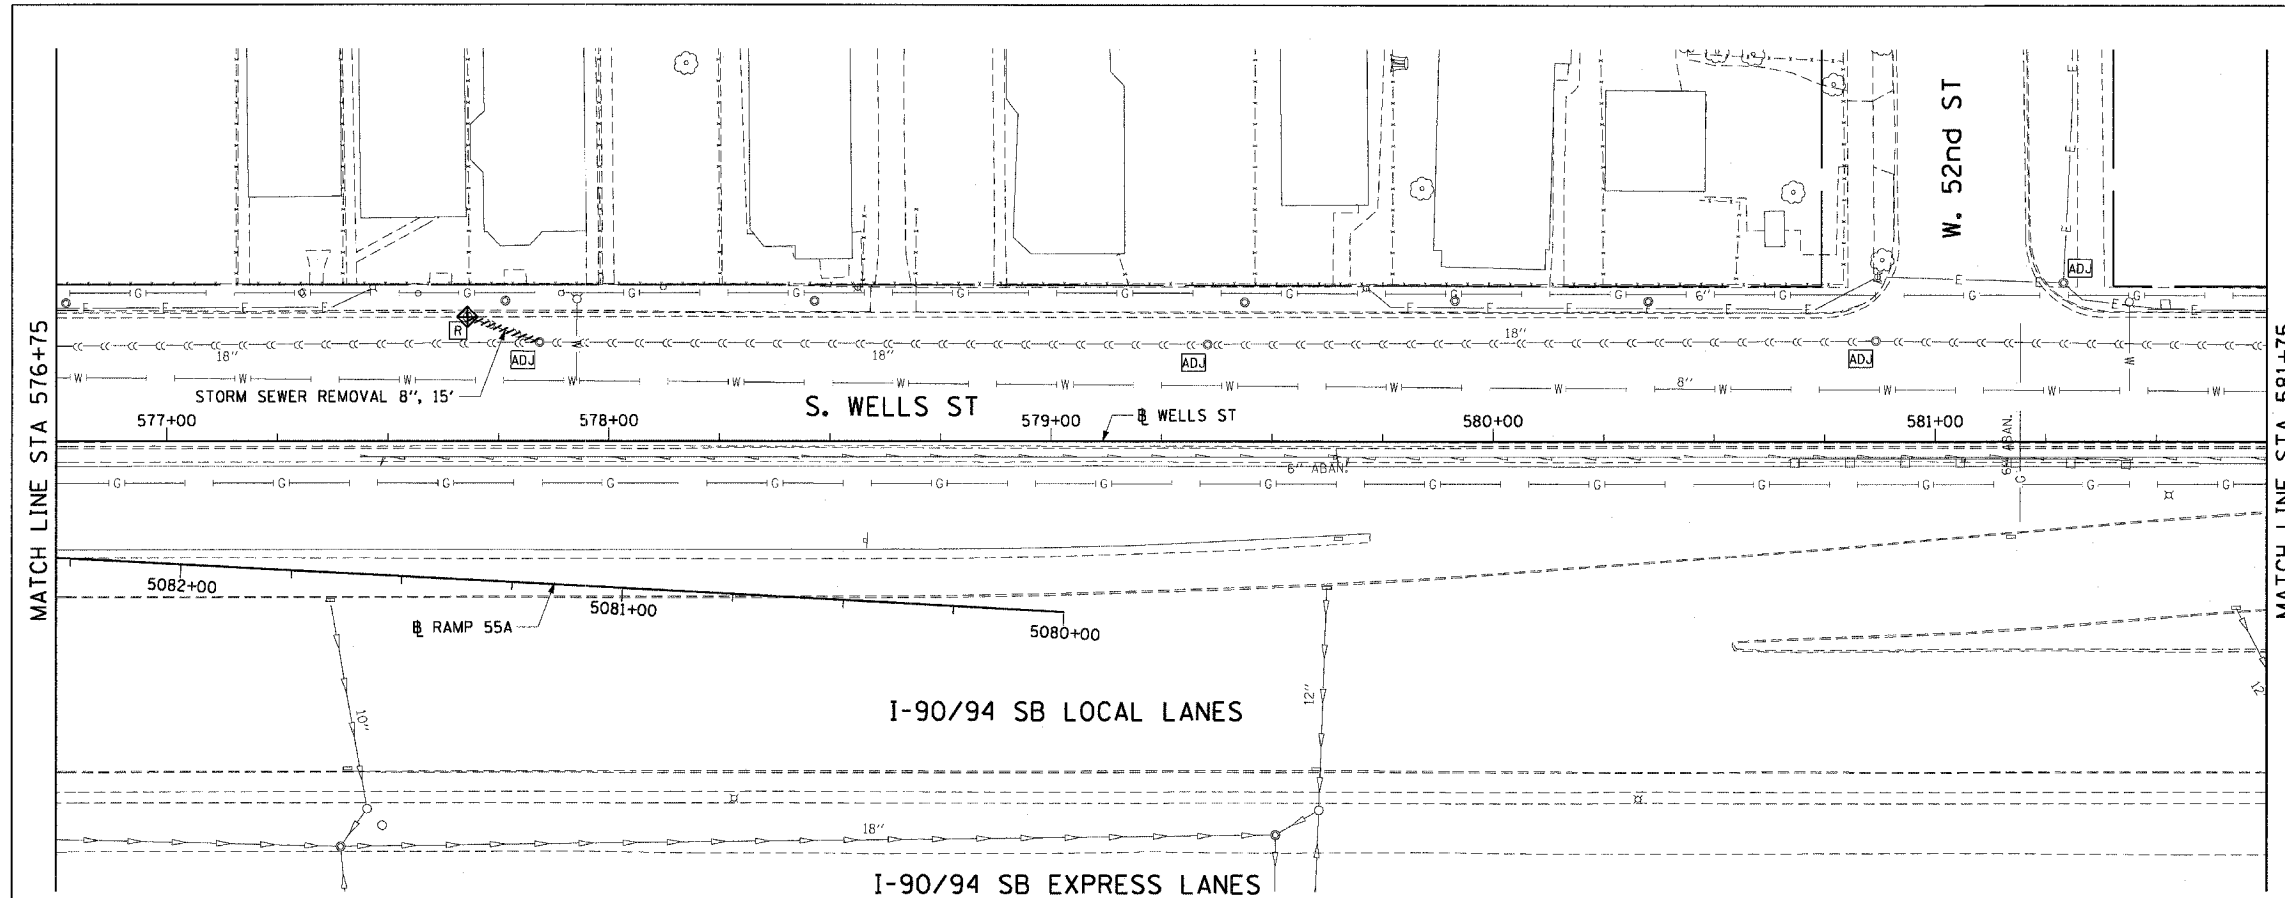

**CTE ENGINEERS**  
CONSER TOWNSEND ENVIRONMENTAL ENGINEERS, INC.  
303 EAST WACKER DRIVE, SUITE 600  
CHICAGO, ILLINOIS 60601-5202, PHONE: (312) 938-0300

12/15/2004 4:13:38 PM